




**BENNETT ENGINEERING**  
MECHANICAL - ELECTRICAL  
(207) 855-9475

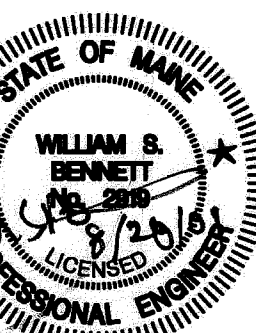

Owner:  
**Avesta Munjoy Commons, LP.**  
307 Cumberland Ave.  
Portland, Maine 04101  
TEL. 207-553-7780

**Munjoy Commons Apartments**

Portland, Maine


Project No: 07429

Drawing Title:  
**SHAILER FIRST FLOOR ELECTRICAL PLAN**

Scale: 1/4" = 1'-0"  
Date: August 28, 2009  
Revisions:

- ▲
- ▲
- ▲
- ▲
- ▲
- ▲

Drawing Number:  
**SHAILER E1.3**

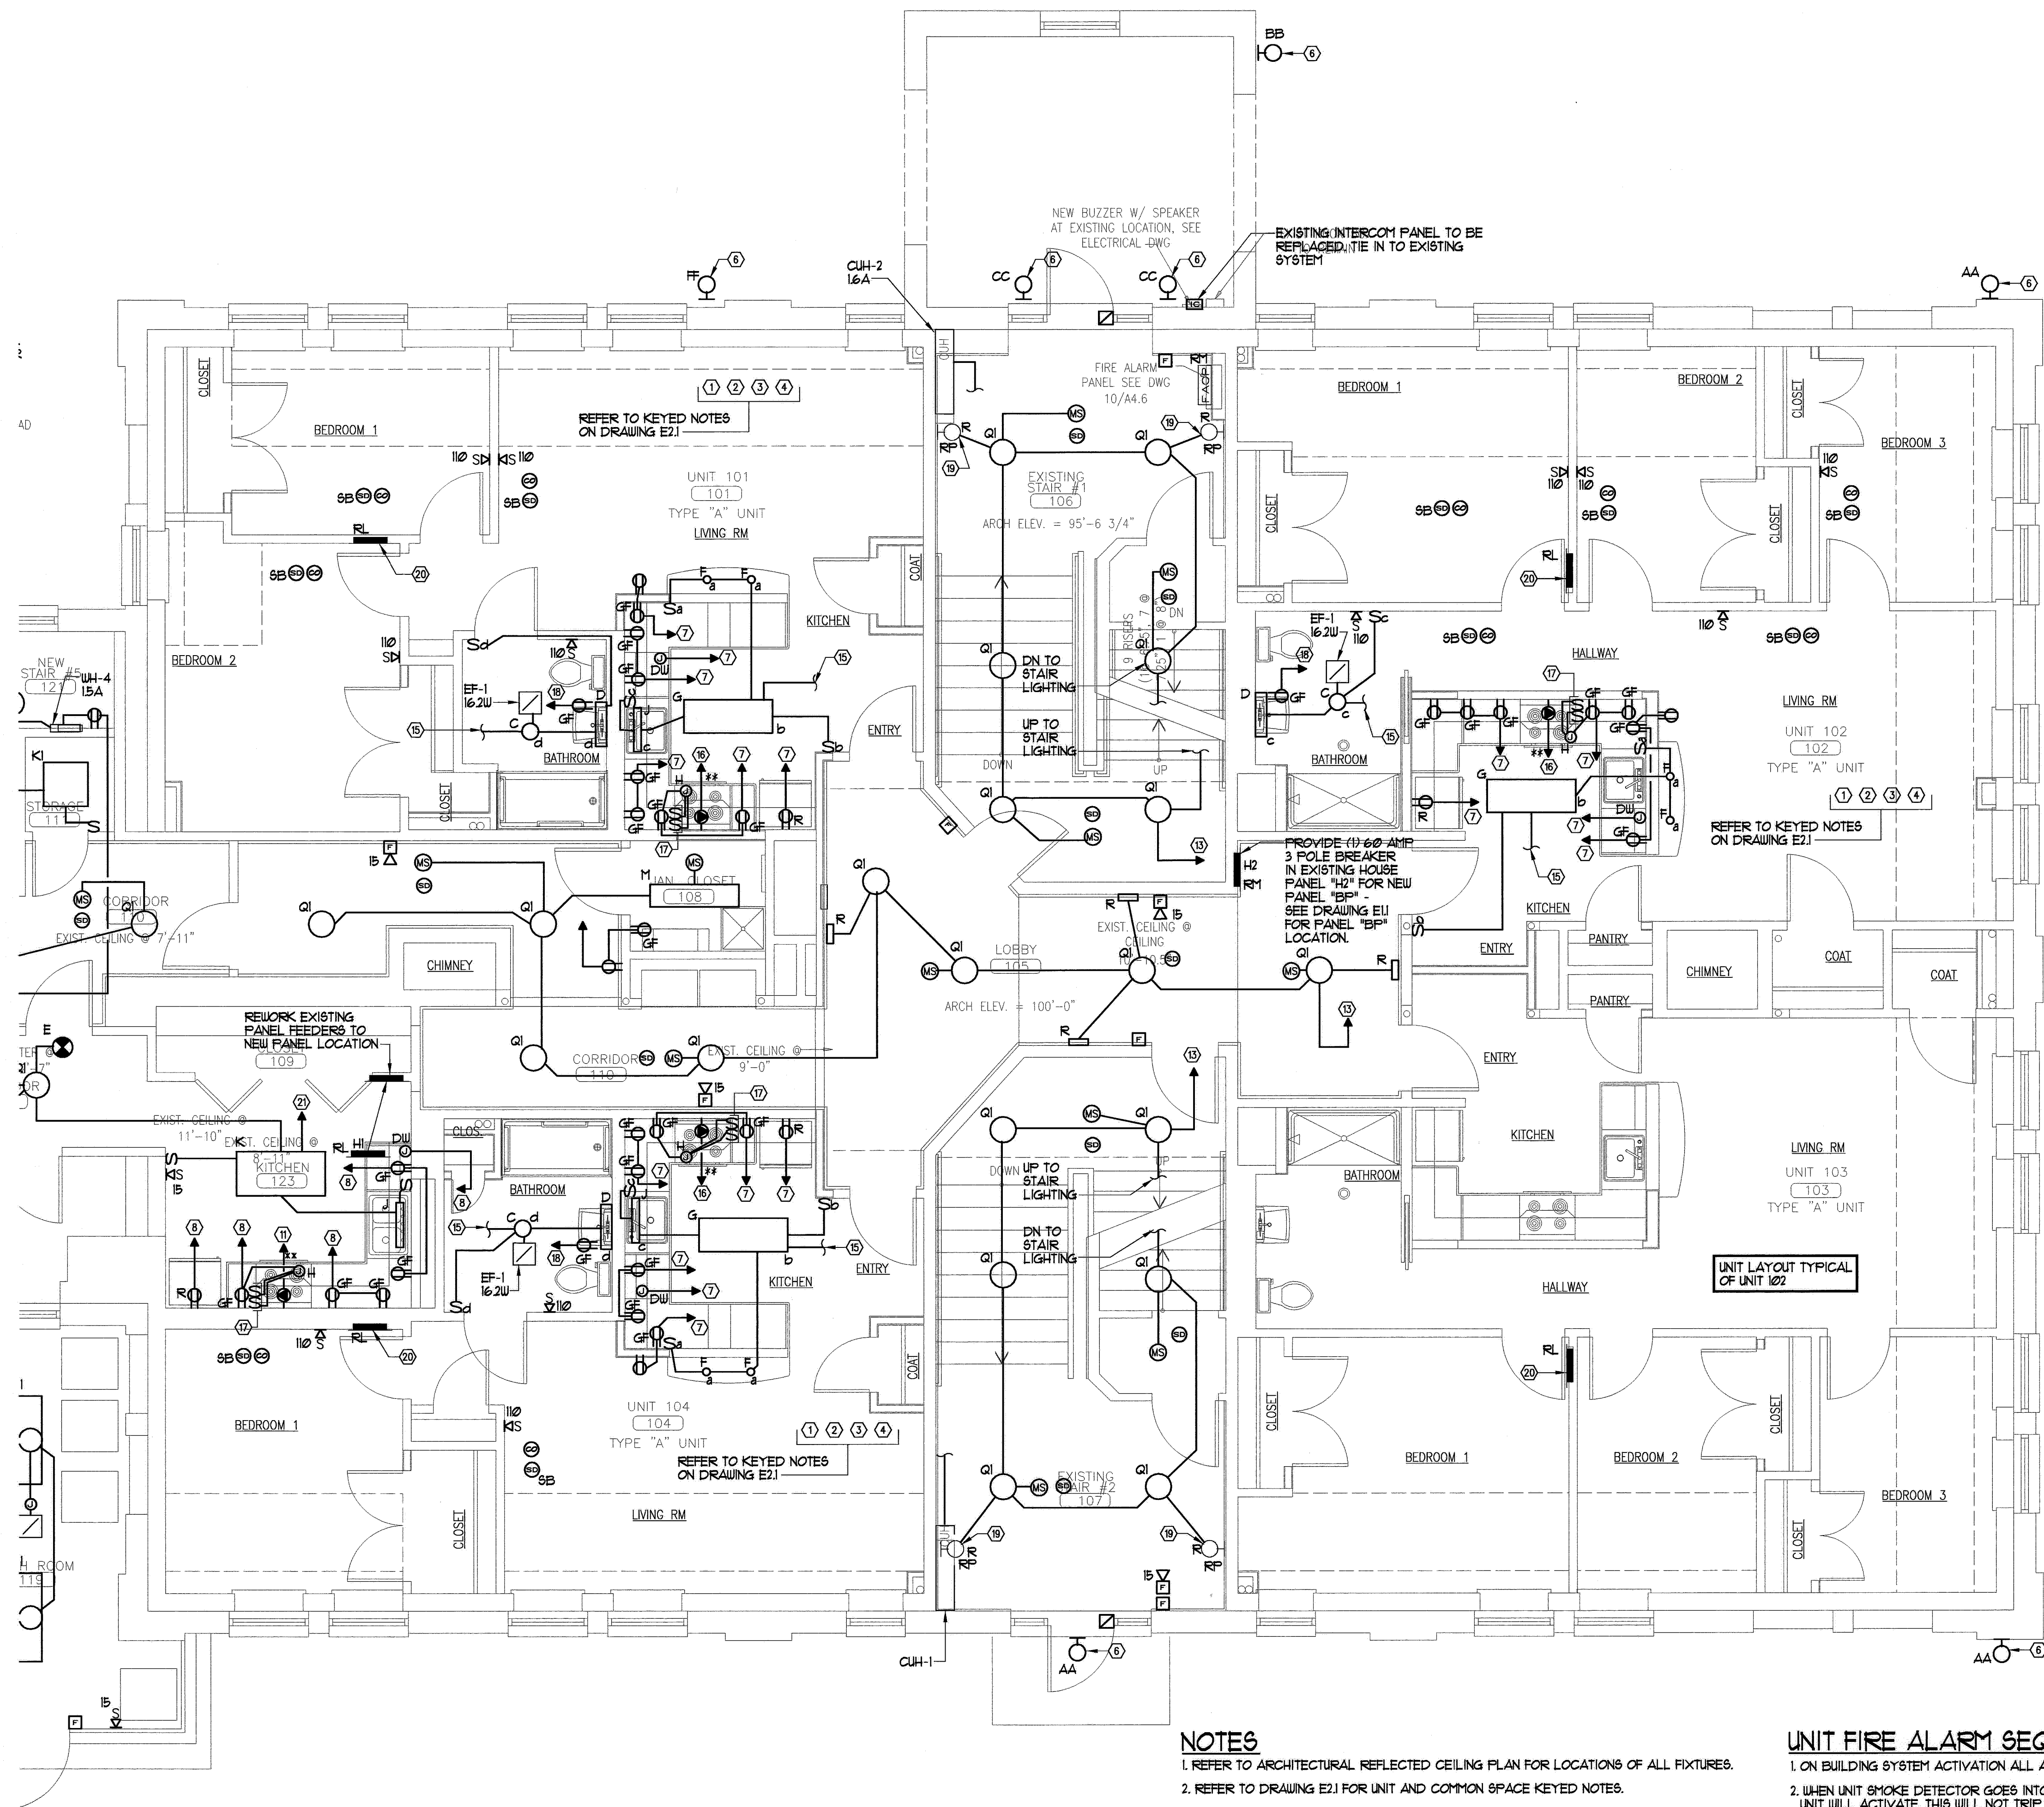

**NOTES**

1. REFER TO ARCHITECTURAL REFLECTED CEILING PLAN FOR LOCATIONS OF ALL FIXTURES.
2. REFER TO DRAWING E21 FOR UNIT AND COMMON SPACE KEYED NOTES.

**UNIT FIRE ALARM SEQUENCE NOTES**

1. ON BUILDING SYSTEM ACTIVATION ALL AUDIOVISUAL AND VISUAL ONLY DEVICES SHALL ALARM.
2. WHEN UNIT SMOKE DETECTOR GOES INTO ALARM ALL AUDIOVISUAL AND VISUAL ONLY DEVICES WITHIN THAT UNIT WILL ACTIVATE. THIS WILL NOT TRIP THE ENTIRE BUILDING SYSTEM. IT WILL ANNUNCIATE AT THE FAC.