

© 2007 TFH ARCHITECTS

SHERIDAN HEIGHTS
 PROPOSED CONDOMINIUMS AT
 135 SHERIDAN STREET, PORTLAND MAINE
 FOR SHERIDAN STREET LLC

TFH ARCHITECTS
 100 COMMERCIAL STREET
 PORTLAND MAINE 04101
 TELEPHONE 207 775 6141
 ARCHITECTURE PLANNING

CONSULTANTS:
 REFER TO TITLE SHEET FOR
 CONSULTANT INFORMATION

OWNERS' REPRESENTATIVE

477 CONGRESS STREET, 5TH FLOOR,
 PORTLAND, ME 04101
 TEL: 207 523 3410

REVISIONS:
 2/13/2007

DATE: 06/25/07

PROJECT No.: 507


DRAWN BY: RTLRJS

CHECKED BY: TST

SCALE: AS NOTED

SHEET TITLE:
 2ND. FLOOR LIGHTING,
 ELECTRICAL PANEL,
 & VOICE/DATA
 PLAN

E2.1

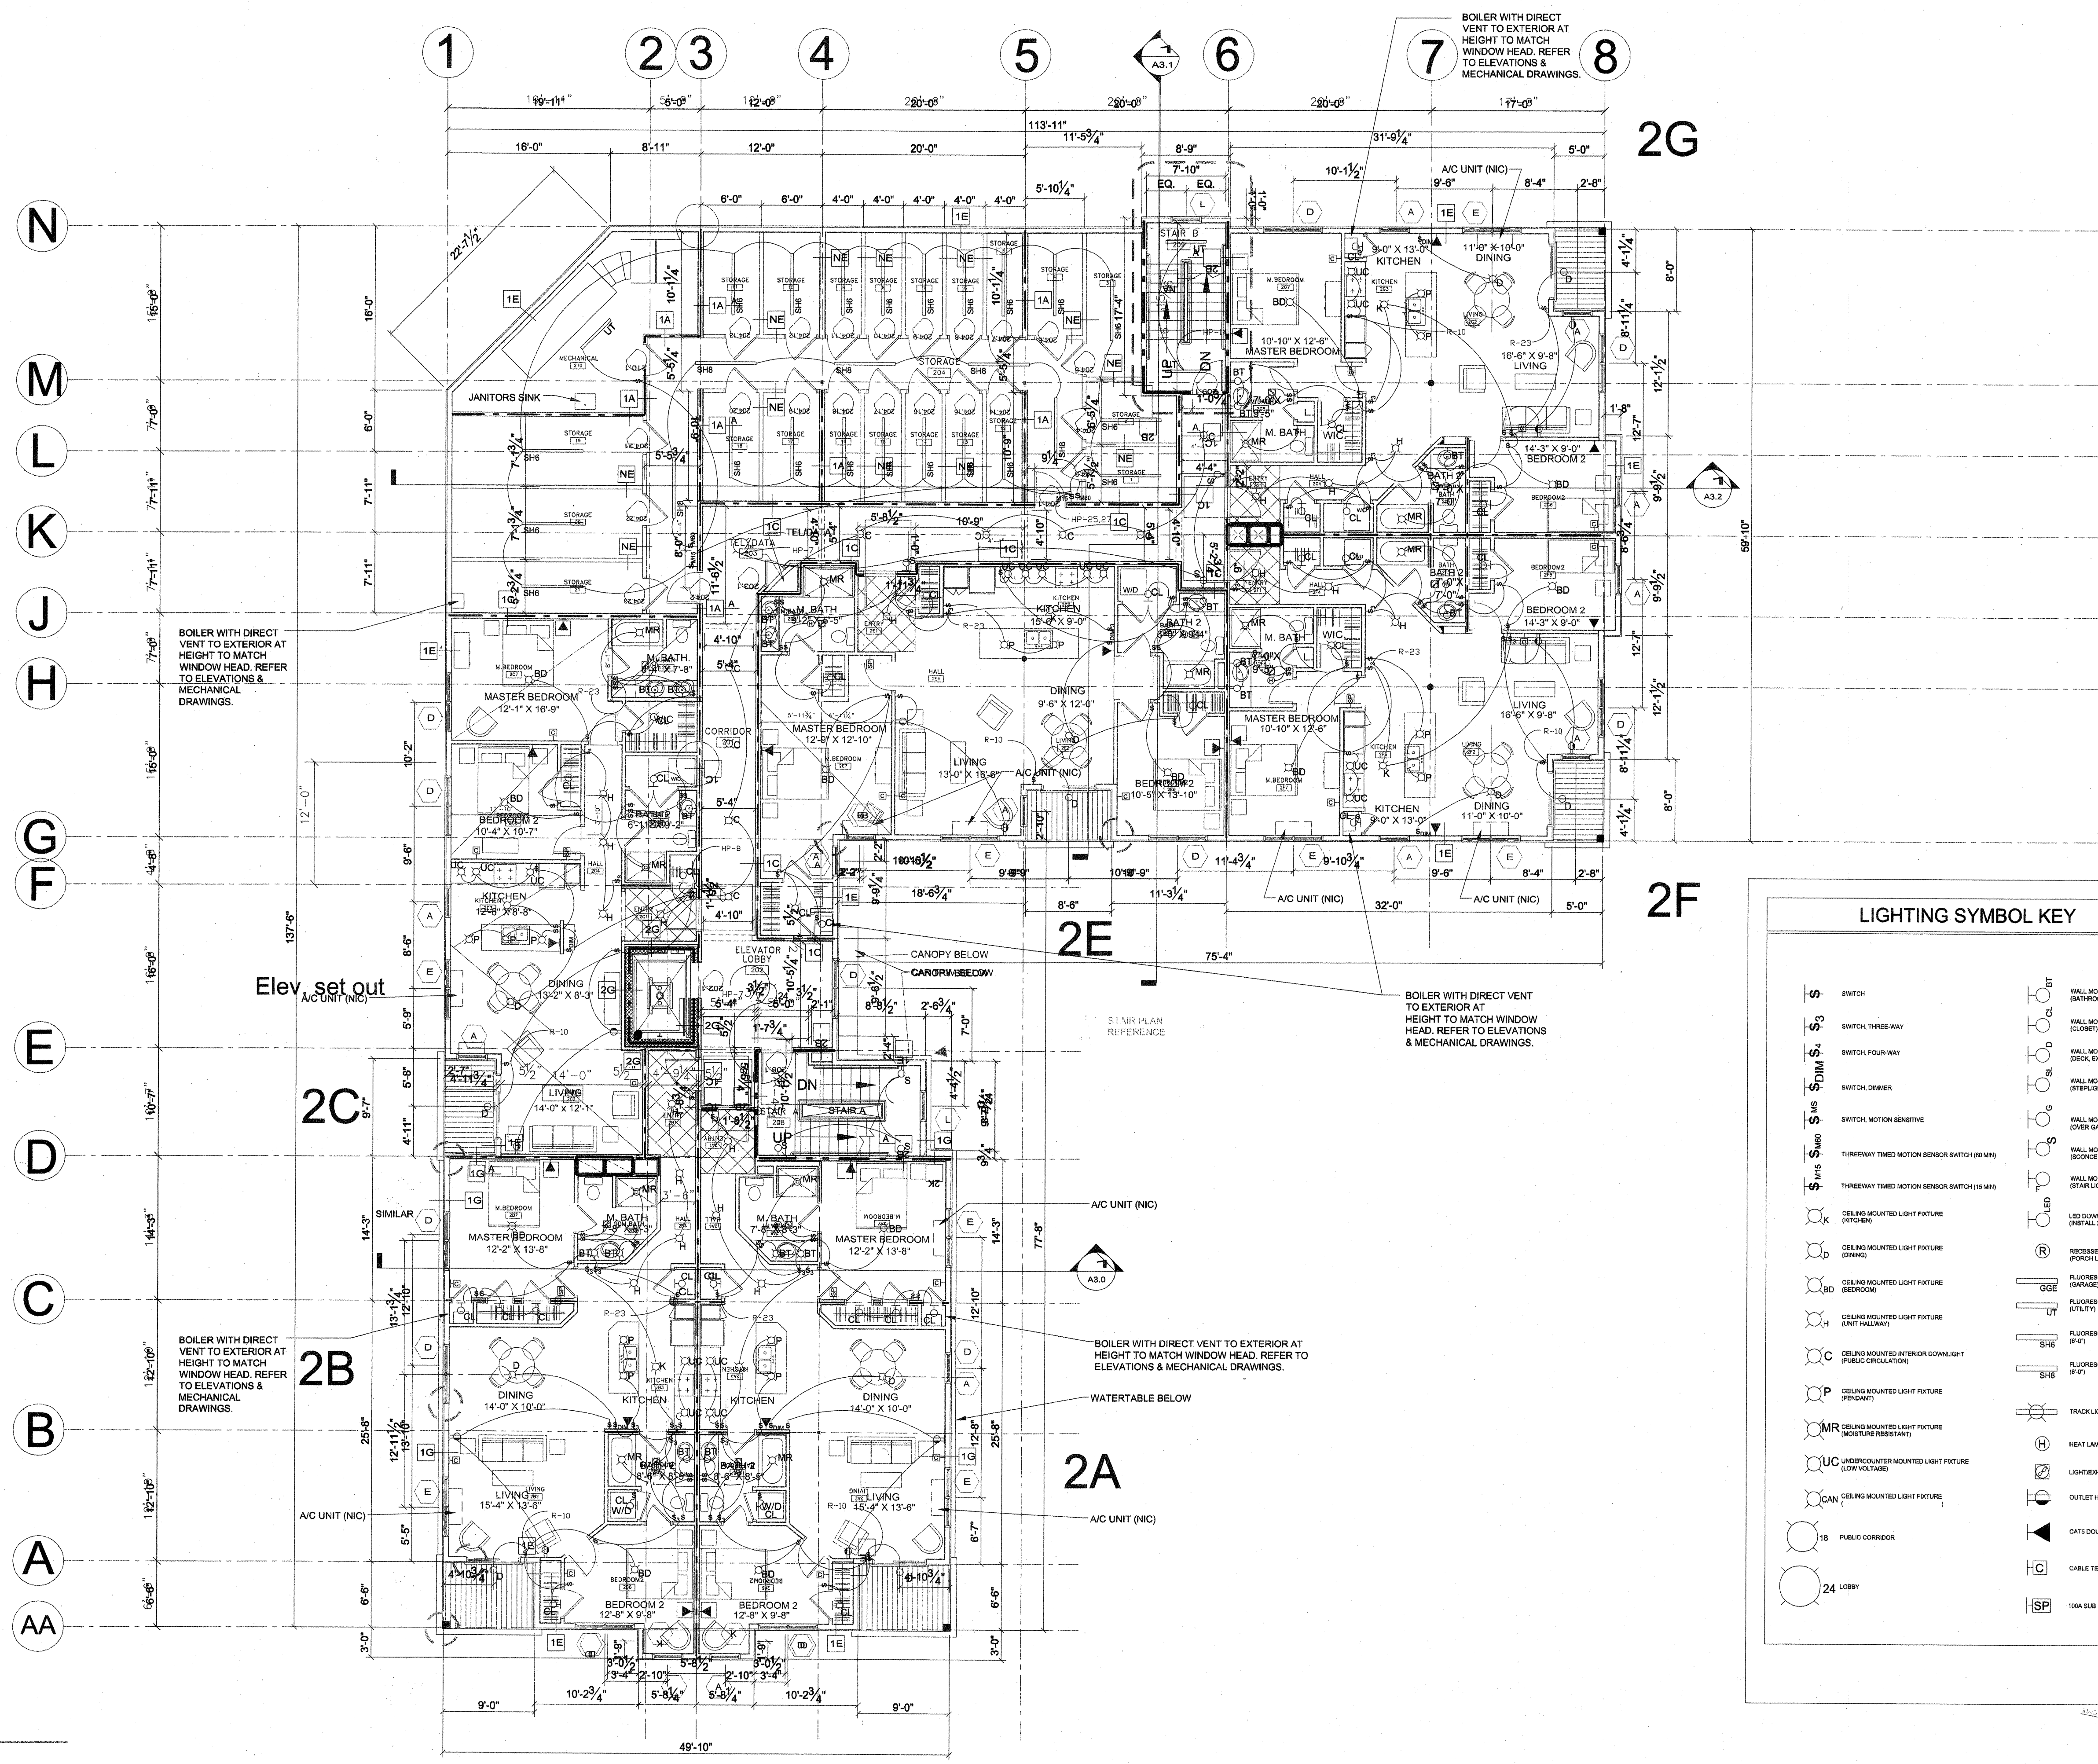

LIGHTING SYMBOL KEY

SWITCH	WALL MOUNTED LIGHT FIXTURE (RECTOR)
SWITCH, THREE-WAY	WALL MOUNTED LIGHT FIXTURE (CLOSET)
SWITCH, FOUR-WAY	WALL MOUNTED LIGHT FIXTURE (DECK, EXTERIOR)
SWITCH, DIMMER	WALL MOUNTED LIGHT FIXTURE (STAIRLIGHTS, EXTERIOR)
SWITCH, MOTION SENSITIVE	WALL MOUNTED LIGHT FIXTURE (OVER GARAGE DOOR, EXTERIOR)
THREEWAY TIMED MOTION SENSOR SWITCH (30 MIN)	WALL MOUNTED LIGHT FIXTURE (RECORD)
THREEWAY TIMED MOTION SENSOR SWITCH (15 MIN)	WALL MOUNTED LIGHT FIXTURE (STAR LIGHT)
CEILING MOUNTED LIGHT FIXTURE (KITCHEN)	LED DOWNLIGHT (INSTALL BY FINISH CHECK)
CEILING MOUNTED LIGHT FIXTURE (DINING)	RECESSED LIGHT (PORCH LIGHT)
CEILING MOUNTED LIGHT FIXTURE (BEDROOM)	FLUORESCENT FIXTURE (GARAGE)
CEILING MOUNTED LIGHT FIXTURE (UNIT HALLWAY)	FLUORESCENT FIXTURE (UTILITY)
CEILING MOUNTED INTERIOR DOWNLIGHT (PUBLIC CIRCULATION)	FLUORESCENT FIXTURE SHIELDED (R-0)
CEILING MOUNTED LIGHT FIXTURE (PENTON)	FLUORESCENT FIXTURE SHIELDED (R-0)
MR (MOISTURE RESISTANT) CEILING MOUNTED LIGHT FIXTURE	TRACK LIGHTING FIXTURE
UC (UNDERCOUNTER MOUNTED LIGHT FIXTURE (LOW VOLTAGE))	HEAT LAMP
CAN CEILING MOUNTED LIGHT FIXTURE	LIGHT EXHAUST FAN
18 PUBLIC CORRIDOR	OUTLET HALF-SWITCHED
24 LOBBY	CATS HEIGHT PHONE/TELECOM JACK
	CABLE TELEVISION JACK
	100A SUB PANEL

SECOND FLOOR LIGHTING PLAN
 A8.1