


© 2007 TFH ARCHITECTS

ELECTRICAL SYMBOLS KEY

- ⊕ Receptacles
- ⊕ Switched Receptacles
- ⊕ Weatherproof Receptacles
- ⊕ GFI receptacle
- ⊕ Electrical Panel
- ⊕ Dryer Receptacle
- ⊕ Range Receptacle

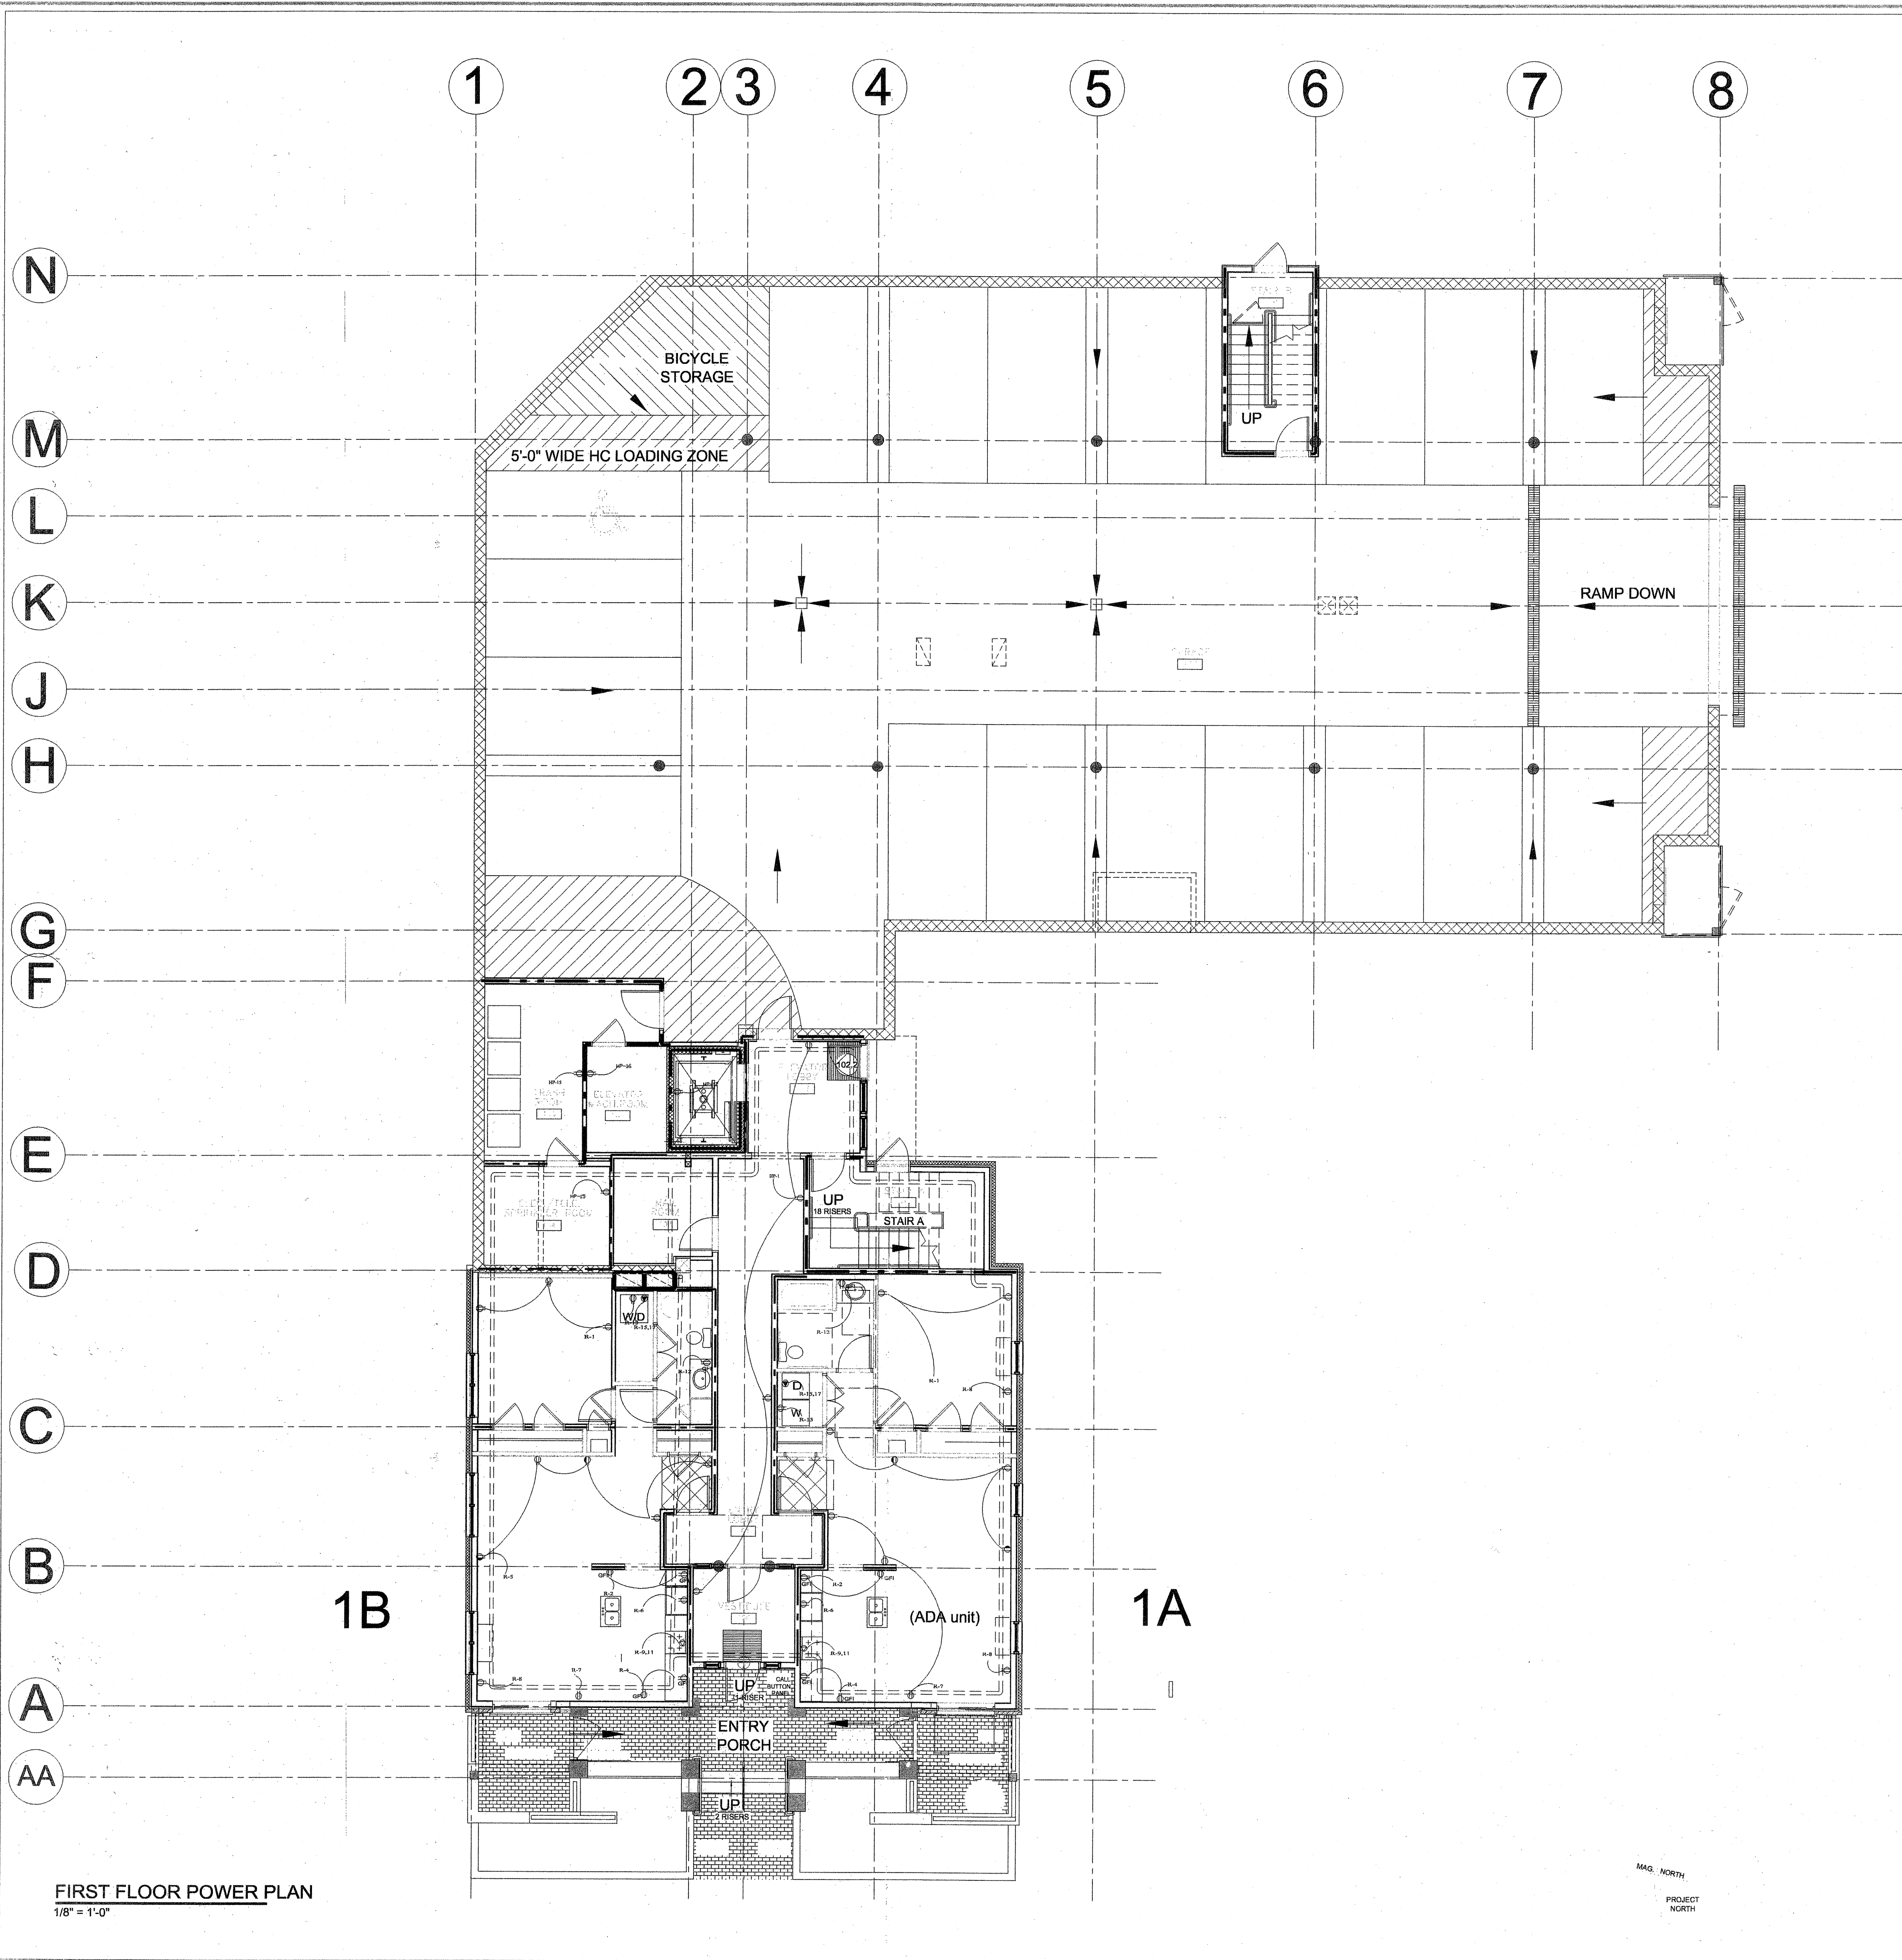

FIRST FLOOR POWER PLAN
1/8" = 1'-0"

MAG. NORTH
PROJECT NORTH

TFH ARCHITECTS
100 COMMERCIAL STREET
PORTLAND MAINE 04101
TELEPHONE 207 775 6144
ARCHITECTURE PLANNING

CONSULTANTS:

OWNERS' REPRESENTATIVE

477 CONGRESS STREET, 5TH FLOOR
PORTLAND, ME 04101
TEL: 207 523 3410

REVISIONS:

DATE: 06/25/07

PROJECT No. 507

DRAWN BY: RTL,RJS

CHECKED BY: TST

SCALE: AS NOTED

SHEET TITLE:
FIRST FLOOR
POWER PLAN

E1.0