

© 2005 TFH ARCHITECTS

**SUMNER COURT**  
A QUALITY RESIDENTIAL DEVELOPMENT BY FORT SUMNER, LLC  
117 SHERIDAN STREET, PORTLAND, MAINE

**TFH ARCHITECTS**  
100 COMMERCIAL STREET  
PORTLAND MAINE 04101  
TELEPHONE 207 775 6141  
ARCHITECTURE PLANNING

CONSULTANTS:  
**STRUCTURAL:**  
Structural Design Consulting  
22 Oakmont Drive  
Old Orchard Beach, ME 04064  
207-934-8038

REVISIONS:

DATE: January 19, 2005

PROJECT No. 0418


DRAWN BY: CSC, TST

CHECKED BY: TST


SCALE: As Noted

SHEET TITLE:  
Electrical Plans

**E1-3**

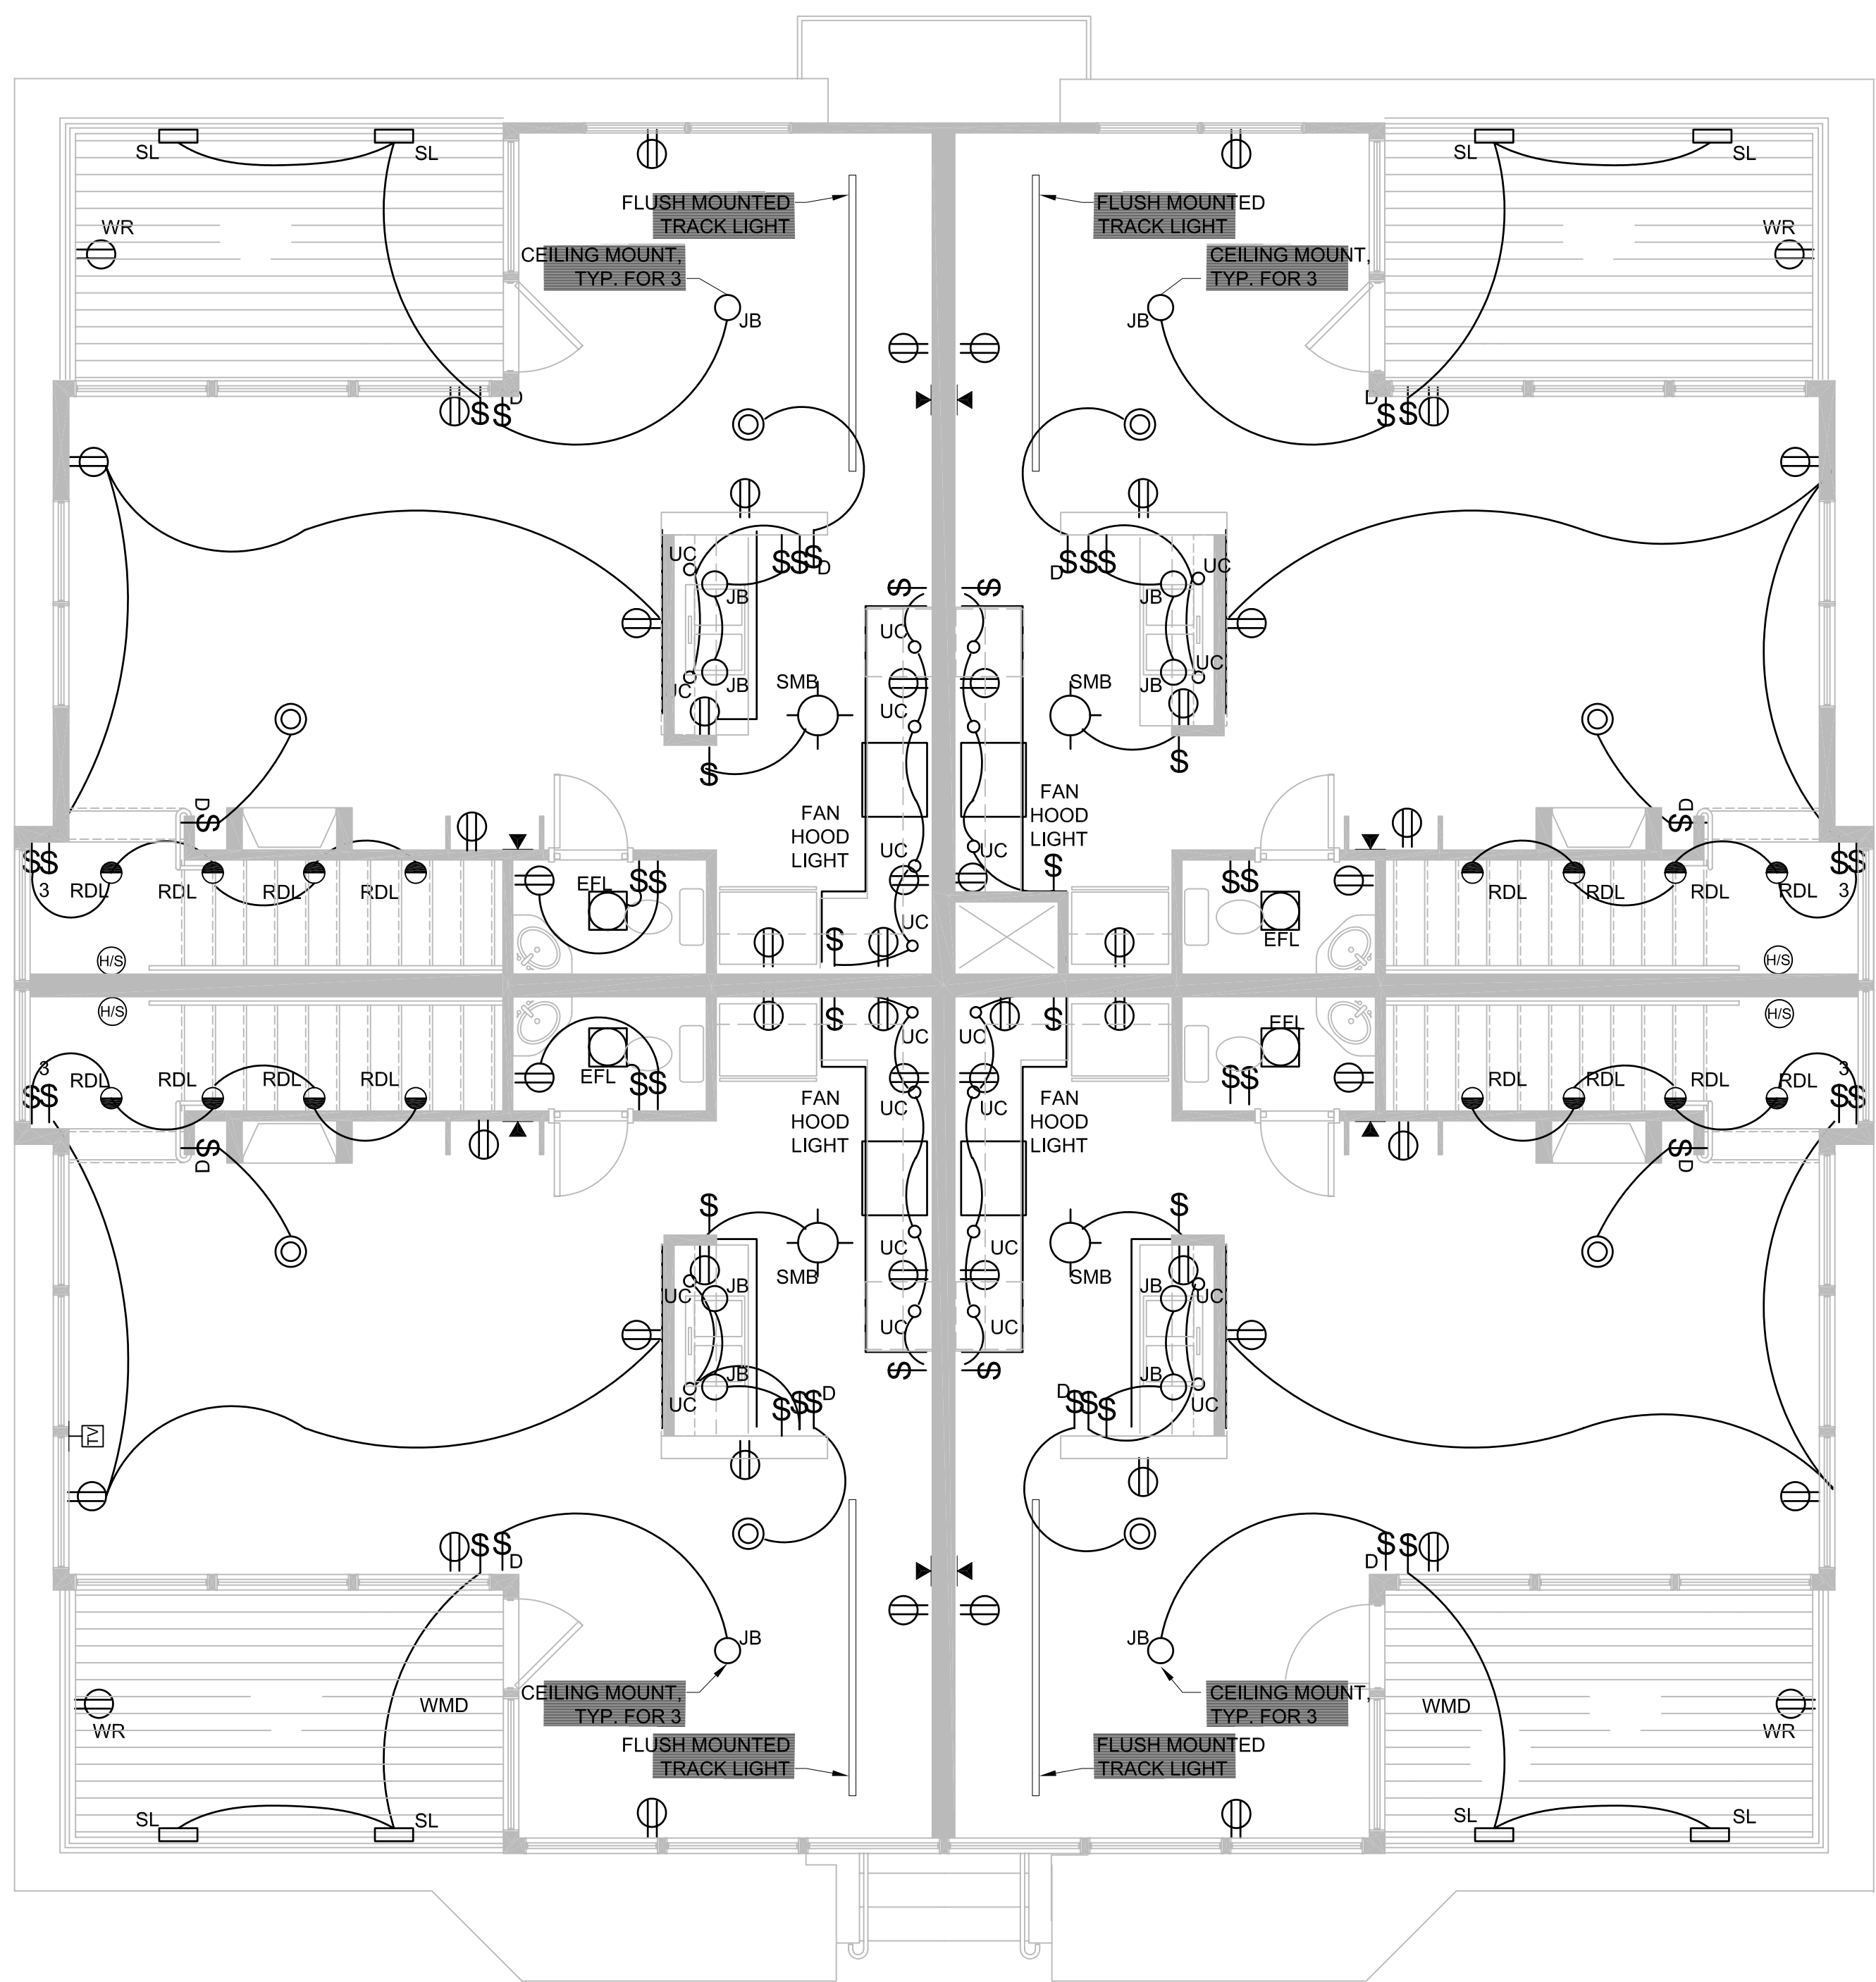

**2 FOURTH FLOOR PLAN**  
A1-3 SCALE: 1/4" = 1'-0"

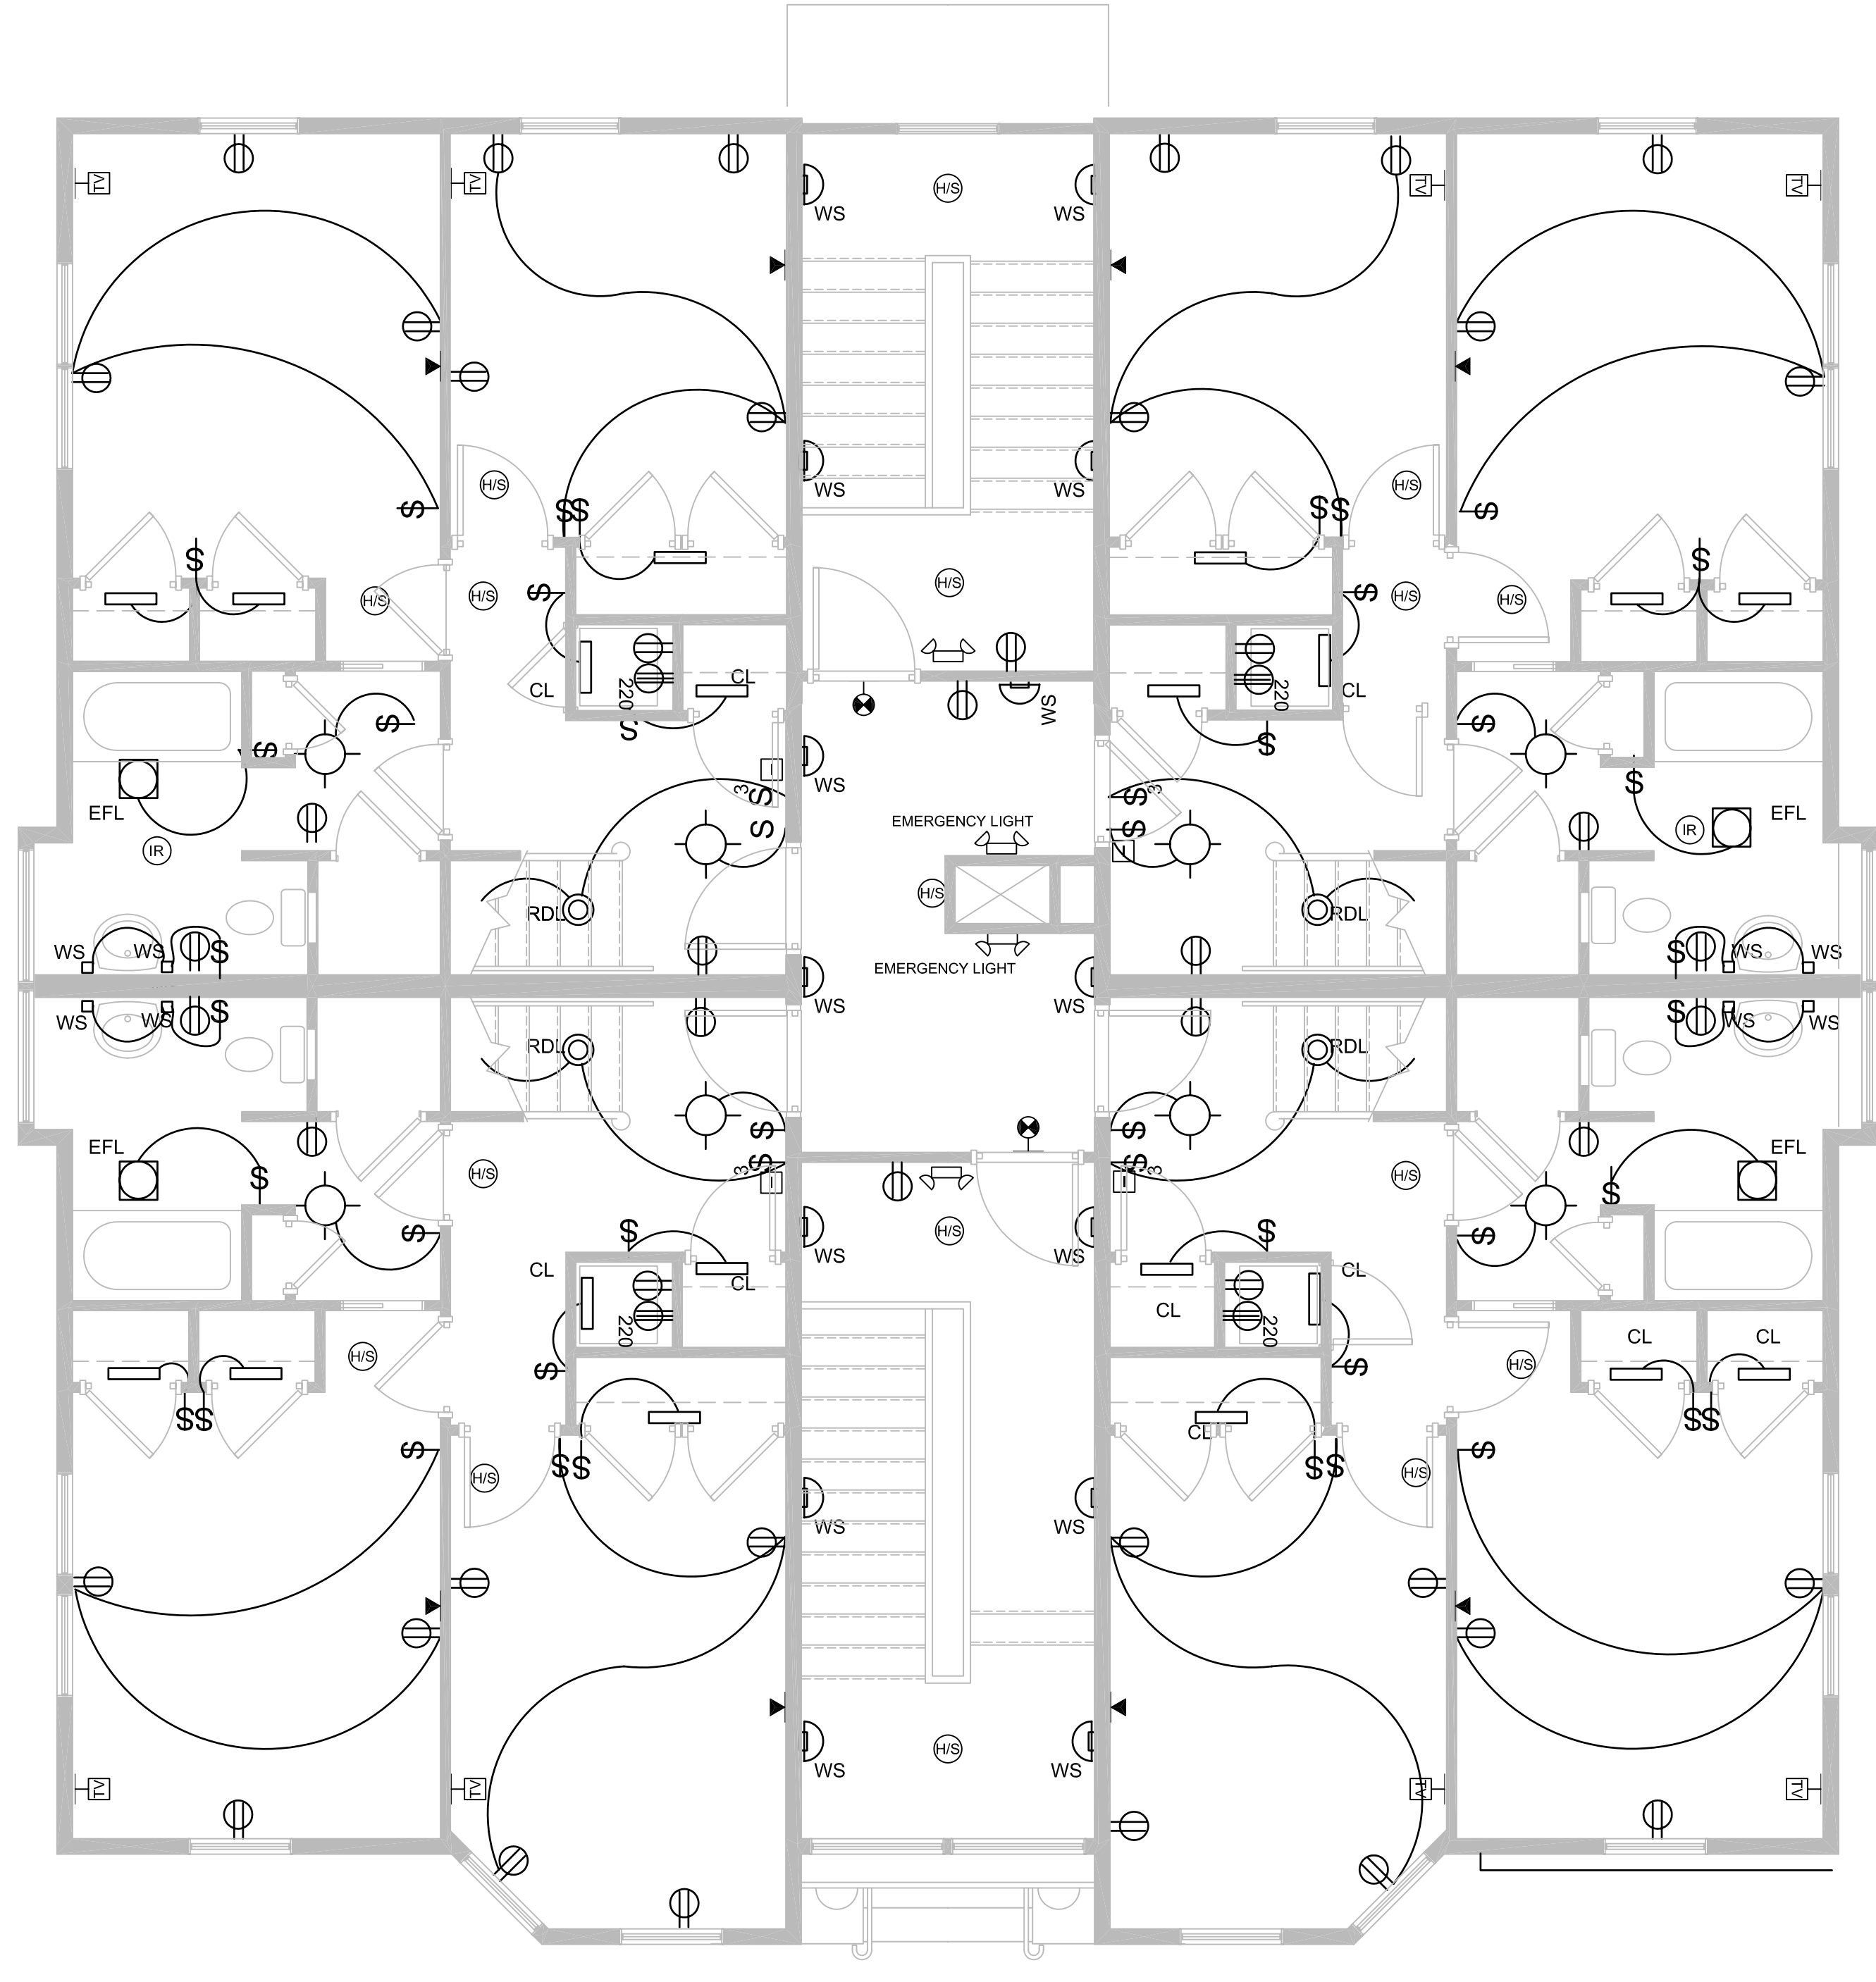

**1 THIRD FLOOR PLAN**  
A1-3 SCALE: 1/4" = 1'-0"

