


© 2005 TFH ARCHITECTS

**SUMNER COURT**  
A QUALITY RESIDENTIAL DEVELOPMENT BY FORT SUMNER, LLC  
117 SHERIDAN STREET, PORTLAND, MAINE

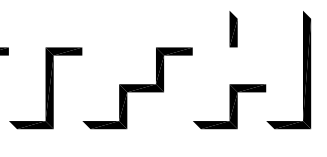

TFH ARCHITECTS  
100 COMMERCIAL STREET  
PORTLAND MAINE 04101  
TELEPHONE 207 775 6141  
ARCHITECTURE PLANNING

CONSULTANTS:  
**STRUCTURAL:**  
Structural Design Consulting  
22 Oakmont Drive  
Old Orchard Beach, ME 04064  
207-934-8038

REVISIONS:

DATE: February 3, 2005

PROJECT No. 0418


DRAWN BY: CSC, TST

CHECKED BY: TST


SCALE: As Noted

SHEET TITLE:  
Mechanical Plans

M1-2

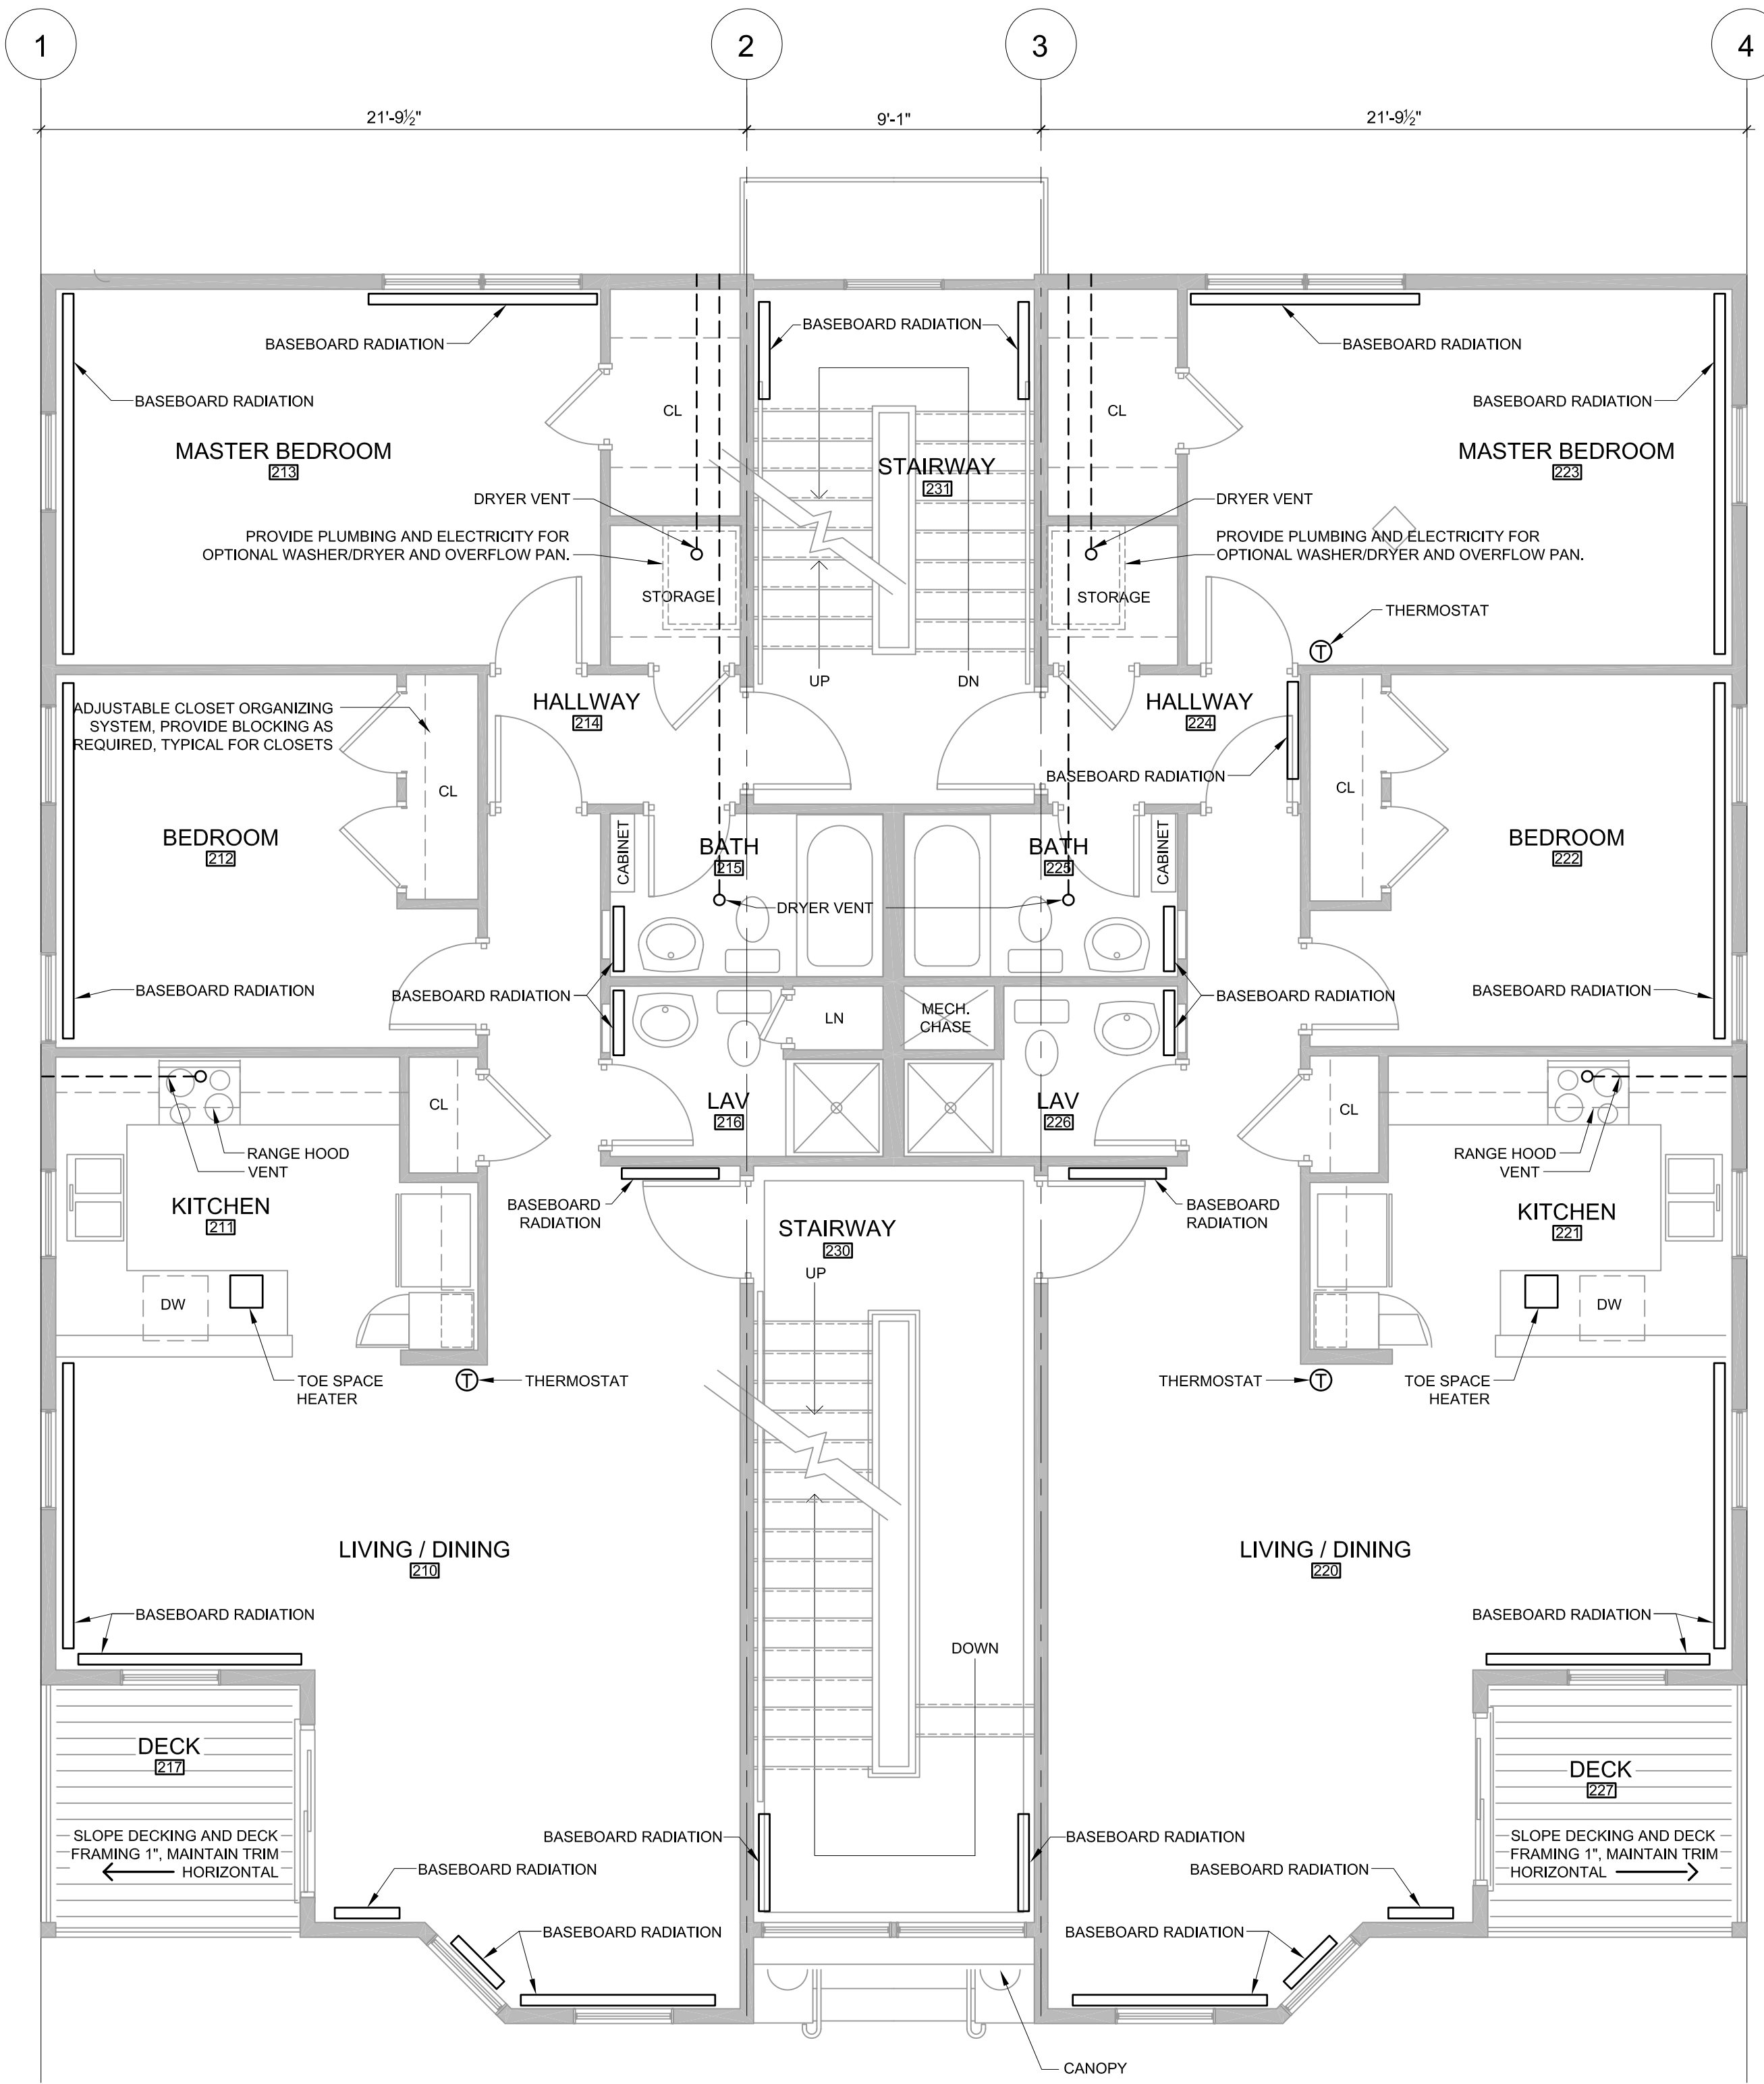

**2 SECOND FLOOR PLAN**  
A1-2 SCALE: 1/4" = 1'-0"

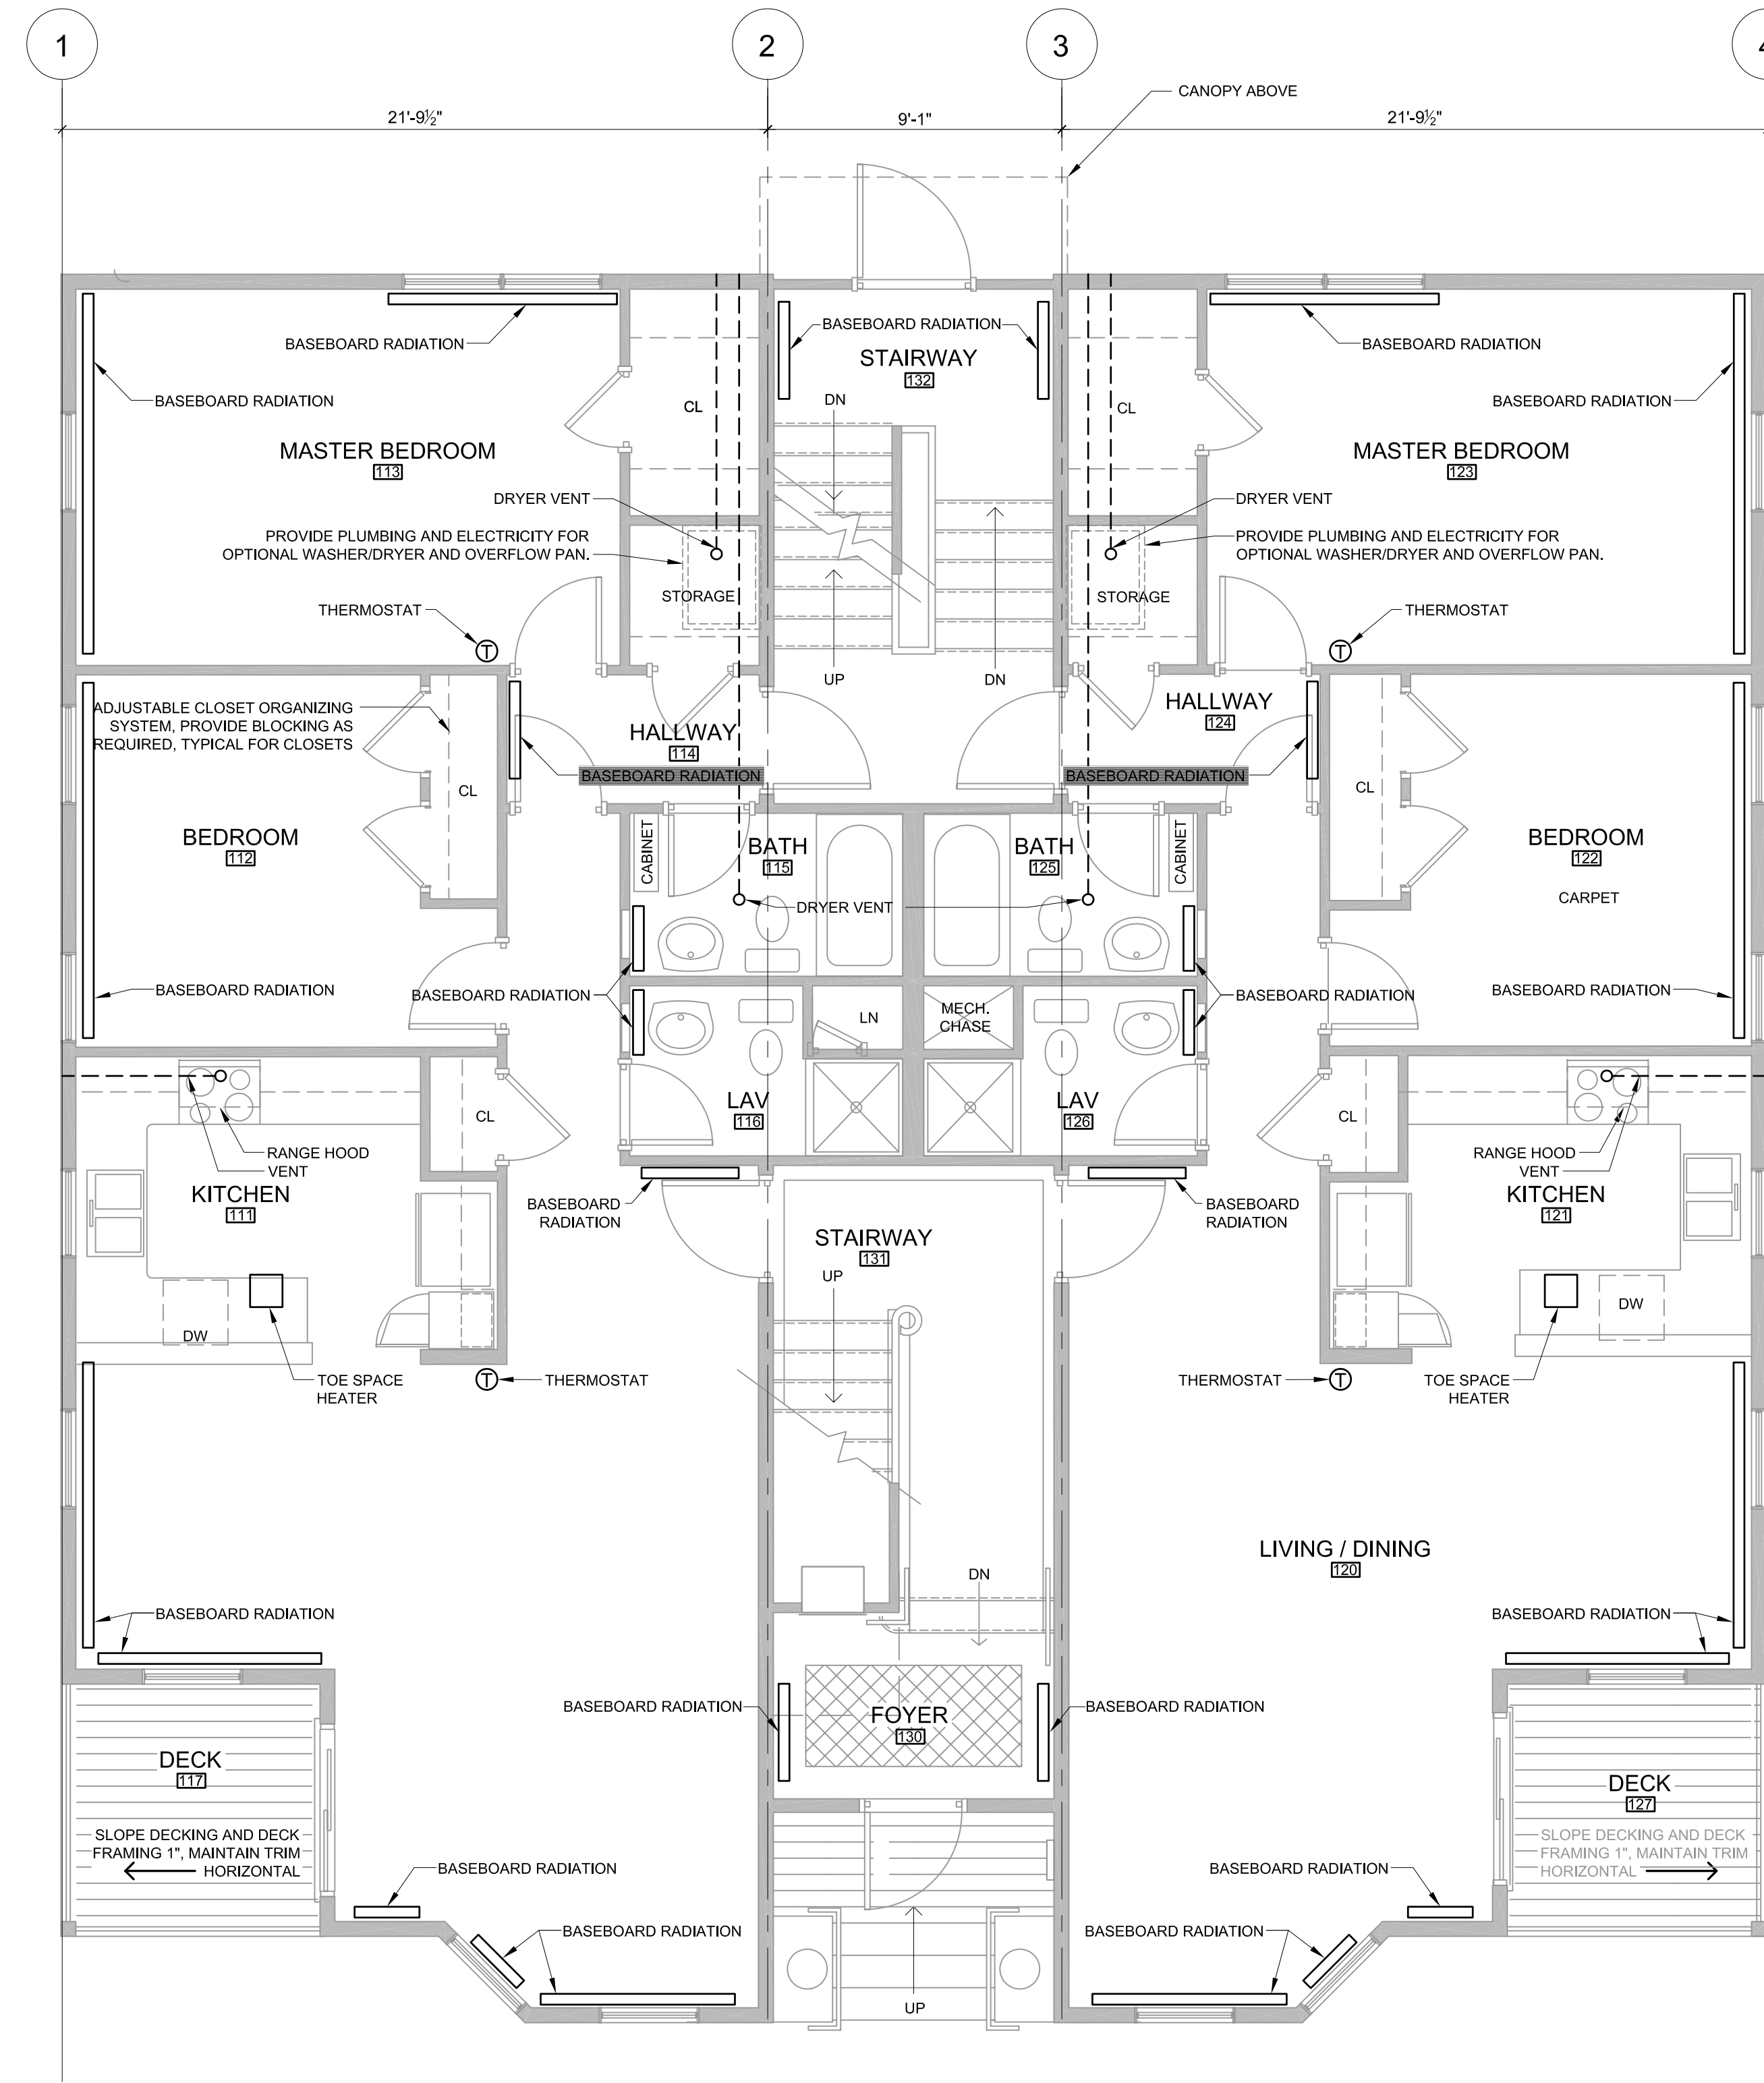

**1 FIRST FLOOR PLAN**  
A1-2 SCALE: 1/4" = 1'-0"

