



DEVICE LEGEND


ITEM	QTY	SYM	ITEM	P/N	NOTE
1	1	FAQP	FIRE ALARM CONTROL PANEL	SXL-EX	
2	0	FANN	FIRE ALARM ANNUNCIATOR	N/A	
3	1	CELL	CELLULAR COMMUNICATOR	CS3055-0F	DSC
4	1	F	MANUAL PULL STATION	MSM-KD	
5	1	P	SMOKE DETECTOR	PE-11	
6	0	P _R	SMOKE DETECTOR W/RELAY BASE	N/A	N/A
7	1	H _R	HORN/STROBE	ZH-MC-R	MT, 80" AFF.
8	0	H	STROBE	N/A	MT, 80" AFF.
9	0	H	HEAT DETECTOR	HFT-11	
10	0	T _M	SINGLE INPUT INTERFACE MINI MODULE	HTR-M	
11	0	T _S	SINGLE INPUT INTERFACE MODULE	HTR-S	
12	0	T _R	SINGLE INPUT INTERFACE MODULE WITH RELAY	HTR-R	
13	1	T _S	TAMPER SWITCH	OSYSU-2	POTTER
14	1	F _S	FLOW SWITCH	VSR-S	POTTER

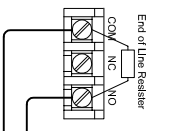


OSYSU-2 Outside Screw and Yoke Valve Supervisory Switch

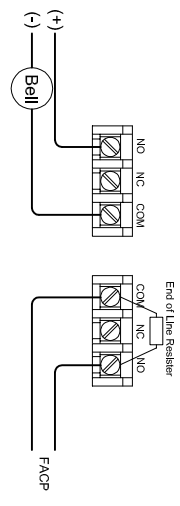


VSR or VSR-S Potter Vane Type Water Flow Switch w/Relay

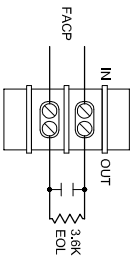


MSM-KD Pull Station

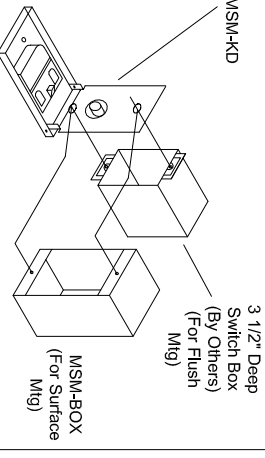


MSM-K & MSM-KD
3 1/2" Deep Switch Box (By Others) (For Flush Mtg)
MSM-BOX (For Surface Mtg)

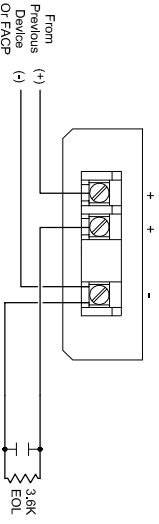


ZH/ZR NOTIFICATION APPLIANCES

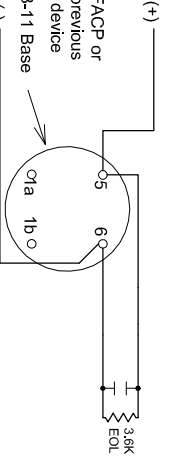

Used for PE-11 Detectors

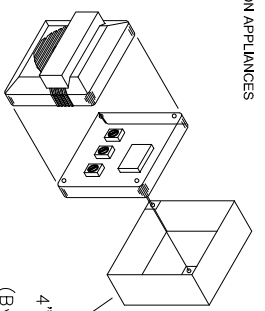


4" Square Box (By Others) Flush Mtg.

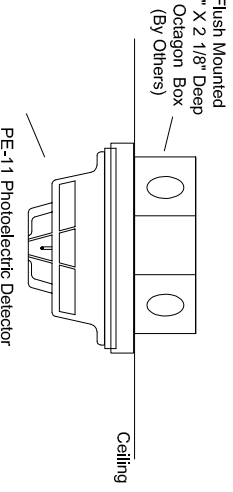

Flush Mounted 4" X 2 1/8" Deep Octagon Box (By Others)
PE-11 Photoelectric Detector
Ceiling

DEVICE MOUNTING & WIRING DETAIL

SCALE: N.T.S.

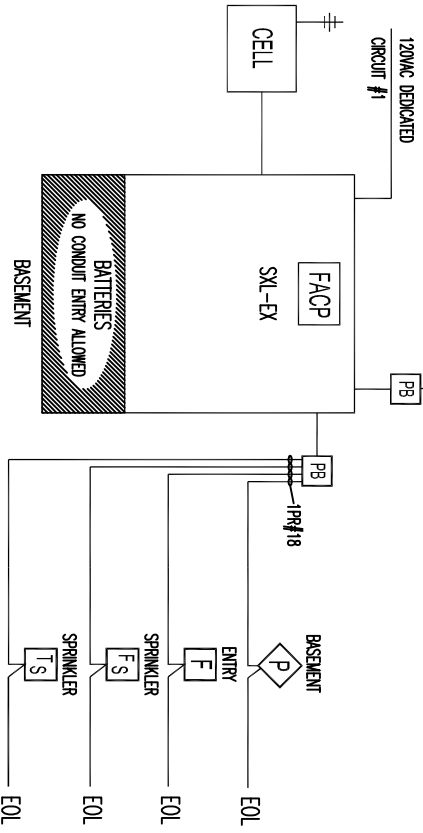

FIRE ALARM RISER DETAIL

SCALE: N.T.S.

<p>EASTERN FIRE SERVICES, INC. 170 WITTENBERG AVENUE, P.O. BOX 1380 AUBURN, MAINE 04210 Phone: 207/794-4597 Fax: 207/782-8988</p>		<p>FIRE ALARM CONTRACTOR: ISLAND CARPENTRY</p>	
<p>CONTRACT WITH: ISLAND CARPENTRY</p>		<p>DWG. NO.: FA-1</p>	
<p>PROJECT: 62 CUMBERLAND AVENUE PORTLAND, MAINE</p>		<p>JOB NUMBER: EF5FA46106</p>	
<p>CONTRACTOR/ENGINEER LOCAL FIRE DEPARTMENT</p>		<p>SCALE: 1/8" = 1'-0"</p>	
<p>REQUIRED APPROVALS</p>		<p>DATE: 7/29/11</p>	
<p>DRAWN BY: DRS</p>		<p>RISER DETAIL</p>	
<p>CHECKED BY: BWB</p>			