


[K] Knox Box
[A] Annunciator

PARKING LOT

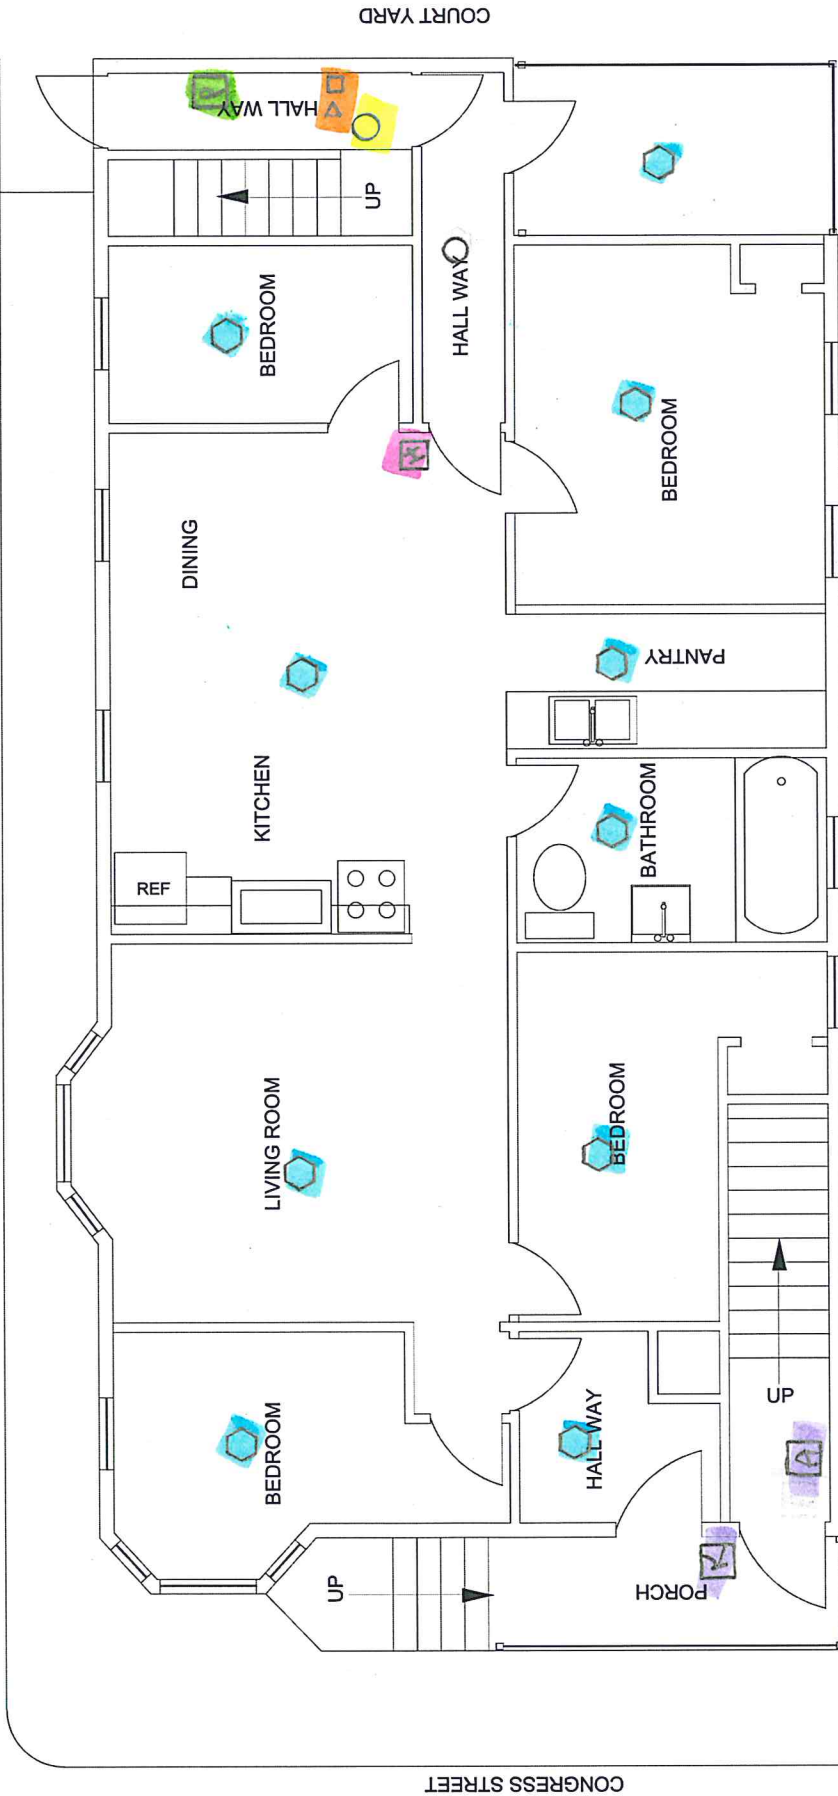

COURT YARD

Basement: 4 Smoke Detectors
 2 horn strobes
 1 CO Detector
 1 Main Panel
 1 Pull Station

Horn only
 normal strobe
 Heat Detector
 Smoke Detector

119 CONGRESS STREET 1ST FLOOR
 SCALE: N.T.S.
 Pull Station

DRAFTSMAN:
 Stephen S. Andrews
 22 Prince Park Plaza, Rd.
 Raymond, Maine 04077
 207-415-5065

PROJECT NAME:
 119 CONGRESS STREET
 4 STORY APARTMENT BUILDING

REV.	DESCRIPTION	BY	DATE

CODE: Portland, Me
 TOWN: 11-19-16
 DATE:
 SCALE: SSA
 DESIGNED: SSA
 DRAWN:
 TITLE: 1st Floor Plan
 FILE:
 SHEET: FP1


DRAFTSMAN:
 Stephen S. Andrews
 23 Parker Pond Pines Rd.
 Raymond, Maine 04071
 207-415-6065

PROJECT NAME:
 119 CONGRESS STREET
 4 STORY APARTMENT BUILDING

REV.	DESCRIPTION	BY	DATE


CODE: Portland, Me
 TOWN: 11-9-18
 DATE: 11-9-18
 SCALE: SSA
 DESIGNED: SSA
 DRAWN: SSA
 TITLE: 2ND Floor Plan
 FILE:
 SHEET: PP1

CITY OF PORTLAND

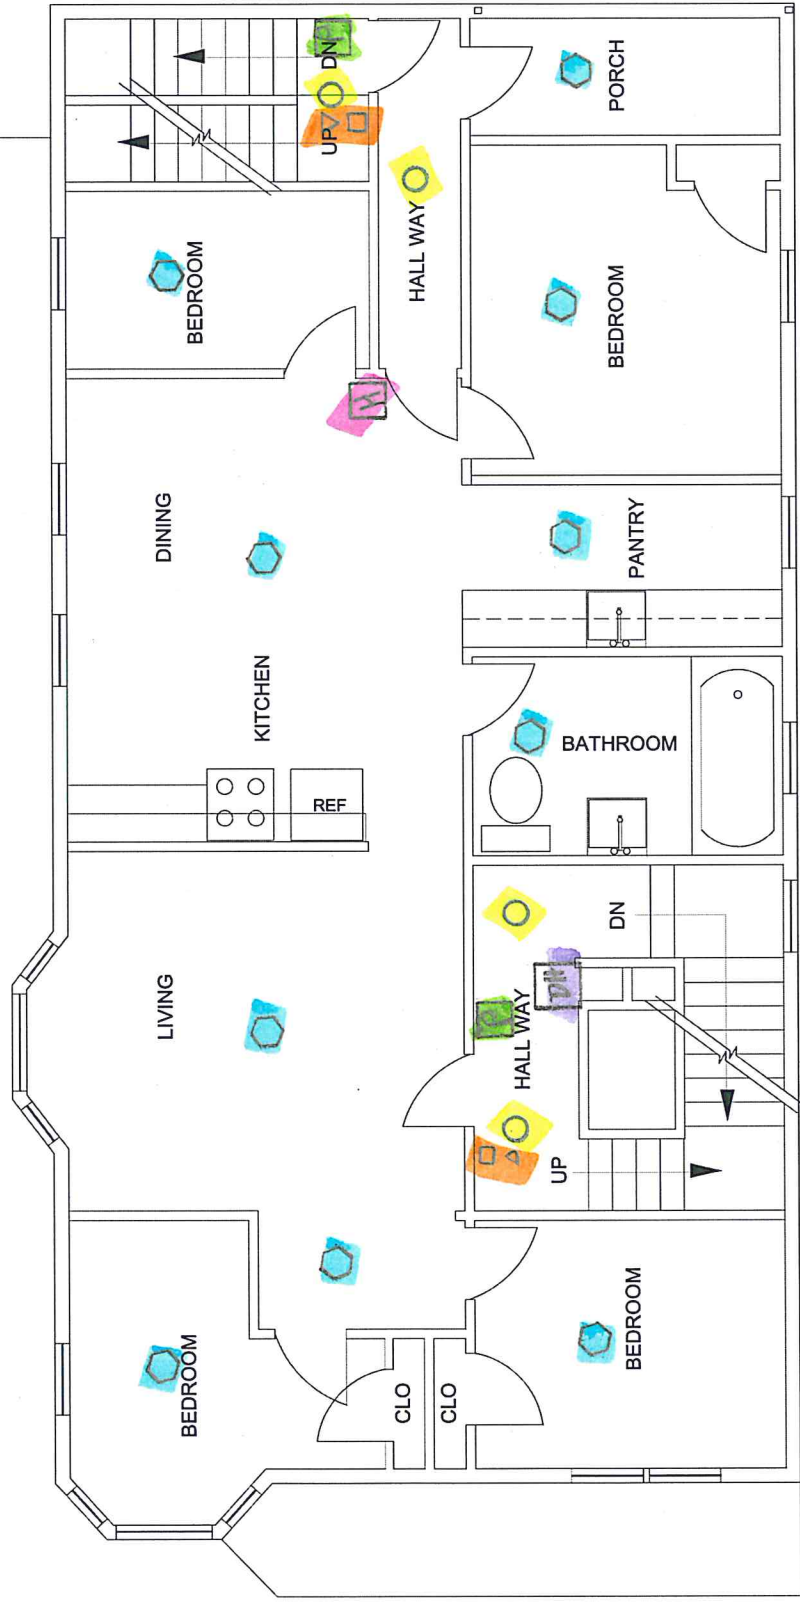

PH DOOR HOLDER

119 CONGRESS STREET 2ND FLOOR
 SCALE: N.T.S.

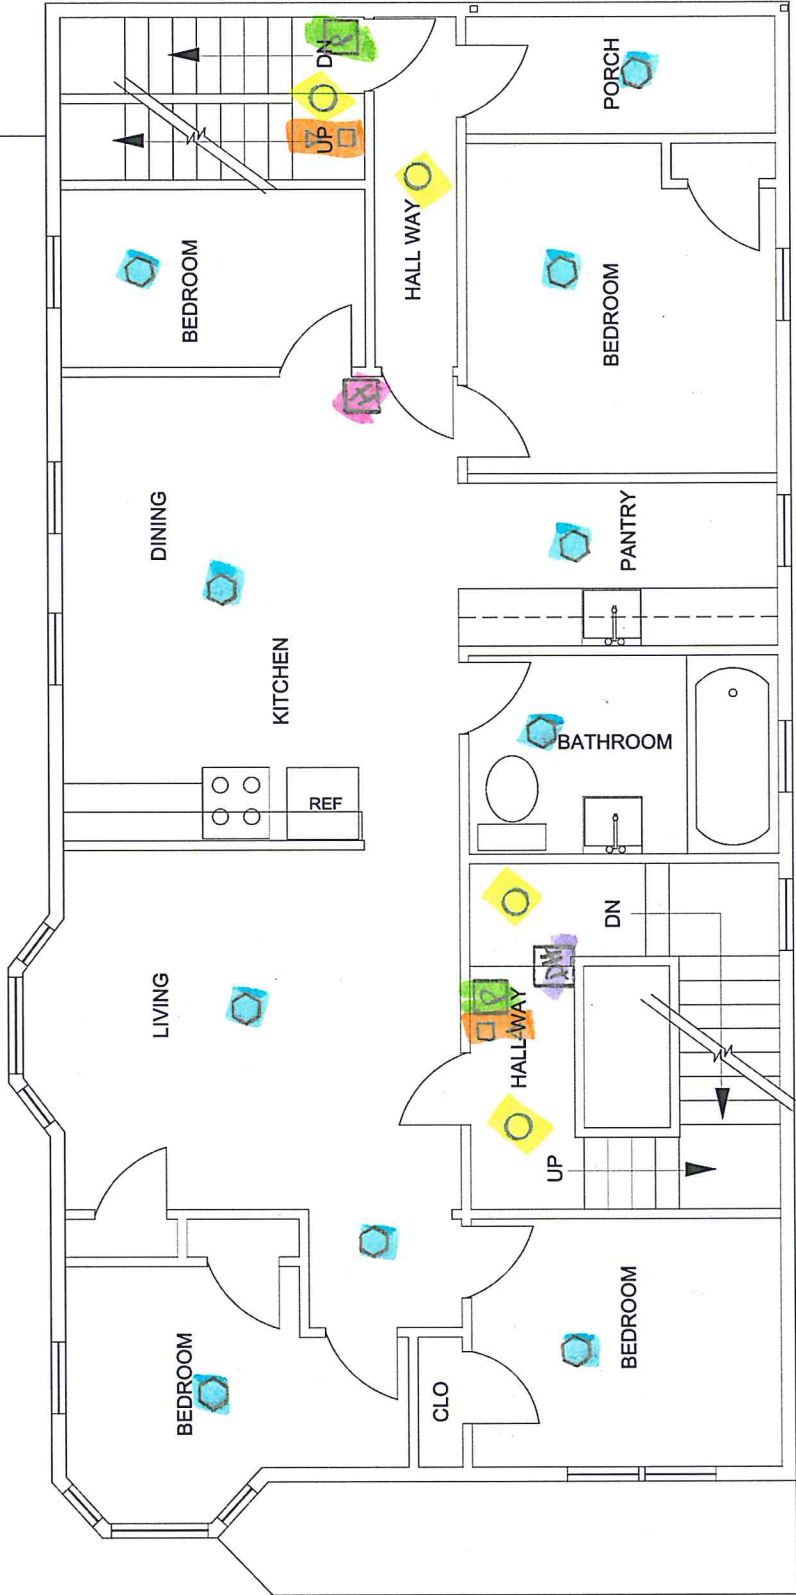


119 CONGRESS STREET 3RD FLOOR
SCALE: N.T.S.

DRAFTSMAN:
Stephen S. Andrews
23 Parker Pond Pines Rd.
Raymond, Maine 04071
207-415-5065

PROJECT NAME:
119 CONGRESS STREET
4 STORY APARTMENT BUILDING

REV#	DESCRIPTION	BY	DATE

CODE: Portland, Me
TOWN: 11-19-16
DATE:
SCALE: SSA
DESIGNED: SSA
DRAWN: SSA
TITLE: 3RD Floor Plan
FILE:
SHEET: FP1

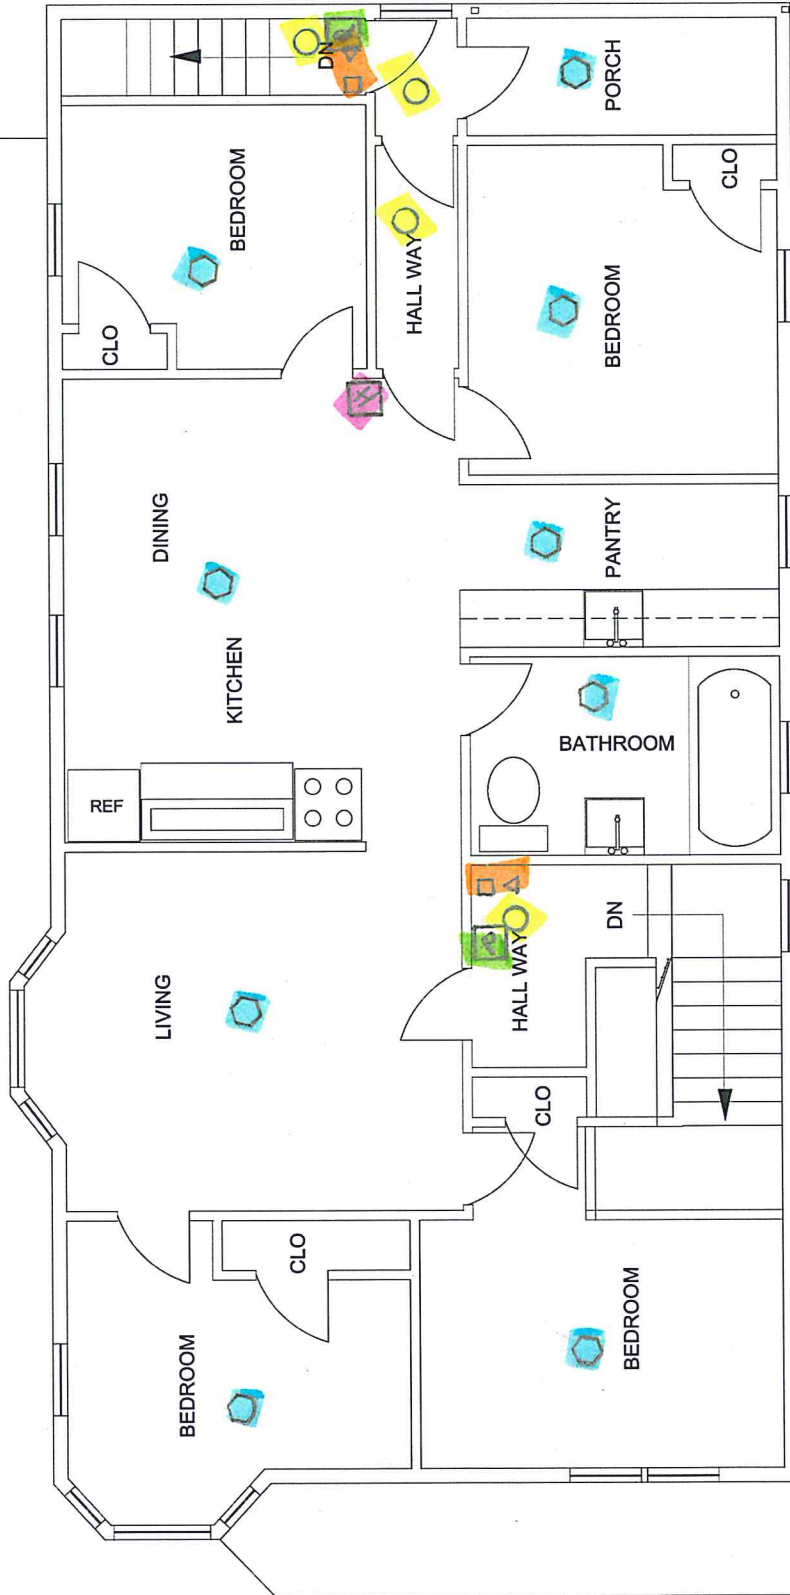

119 CONGRESS STREET 4TH FLOOR.
SCALE: N.T.S.

DRAFTSMAN:
Stephen S. Andrews
23 Palmer Park Plaza Rd.
Portland, Maine 04071
207-415-5065

PROJECT NAME:
119 CONGRESS STREET
4 STORY APARTMENT BUILDING

REV	DESCRIPTION	BY	DATE

CODE: Portland, Me
TOWN: 11-18-18
DATE: 11-18-18
SCALE: SSA
DESIGNED: SSA
DRAWN: SSA
TITLE: 4TH Floor Plan
FILE: FPI
SHEET: FPI