


3 FOURTH FLOOR
SCALE: 1/4" = 1'-0"

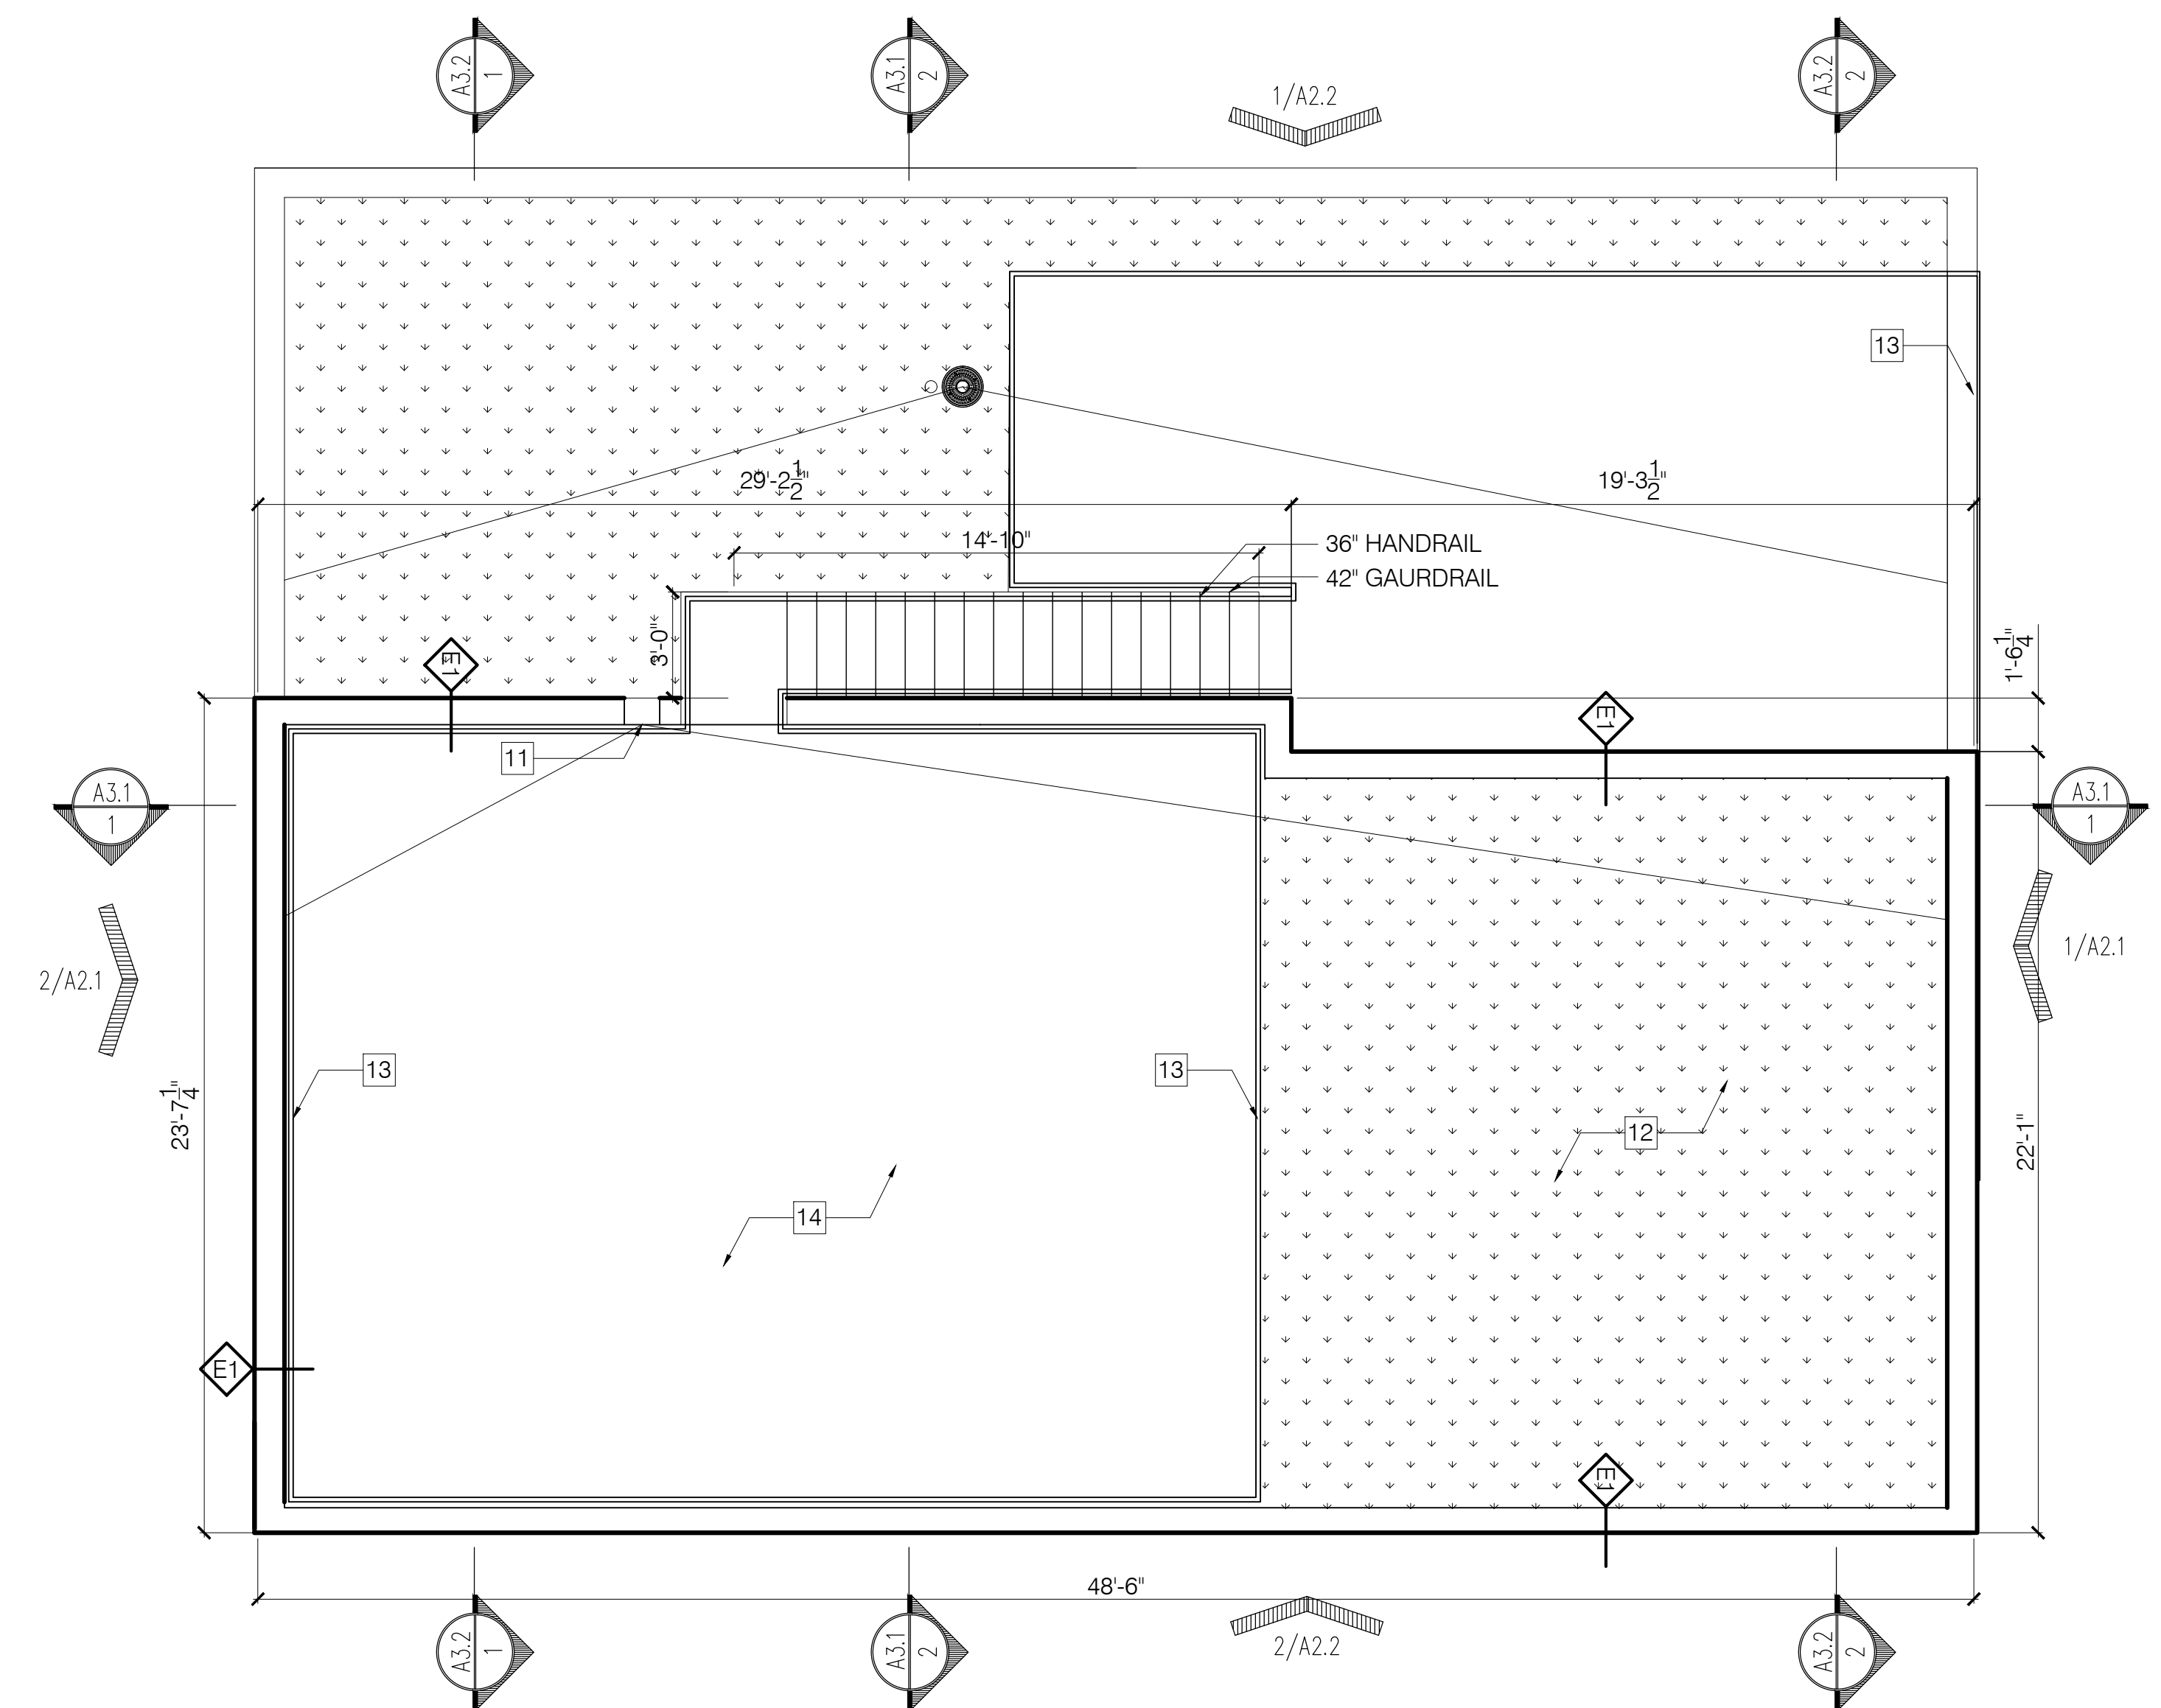

4 ROOF PLAN
SCALE: 1/4" = 1'-0"

- X KEYNOTES:
1. CONCRETE PLANTER
 2. WATER HEATERS
 3. ELECTRICAL PANELS
 4. FRAMED STAIR OPENING ABOVE
 5. LINE OF AWNING ABOVE
 6. LINE OF LOWER CEILING
 7. LOCATION FOR INSTALLATION OF HEAT PUMP UNITS
 8. ROOF DRAIN
 9. OVERFLOW DRAIN
 10. MEMBRANE ROOF
 11. 1/8" TAPERED INSULATION TO PROVIDE POSITIVE SLOPE OF ROOF DRAIN /SCUPPER
 12. AREA FOR GREEN ROOF TRAY SYSTEM
 13. FABRICATED METAL RAILING
 14. TILE ON PEDESTAL ROOF DECK SYSTEM

ISSUE DATE 07 / 15 / 16
DRAWN BY EMW
SHEET SCALE 1/4" = 1'-0"

SITE APPLICATION
NOT FOR CONSTRUCTION

REVISIONS
1 -
2 -
3 -
4 -
5 -

PROJECT NO. 15018
PROJECT NAME MERRILL STREET - 7 UNIT
PORTLAND, ME

A

1.3