




# 7 CUMBERLAND AVE Portland, ME Parking Lot Lighting

Symbol	Label	Quantity	Manufacturer	Catalog Number	Description	Lamp	Number Lamps	Filename	Lumens Per Lamp	Light Loss Factor	Wattage
	A3	1	Brownlee Lighting	7171 8 B6LED 40K ES	Canopy Fixture; mounted at 7ft	LED	1	7171-C37LED-35K.ies	2 961	0.17	9
	A4	2	V2 Lighting	Q2SS-DVW-078340-XX	Exterior Wall Sconce; mounted at 6ft	LED	1	QUBE 2 00 700lm 80CRI 600deg.IES	700	0.23	10
	B2	2	JUNO LIGHTING GROUP, INC	MSL2-35K-UN-BZ	Mini Wall Pack; mounted at 8ft	LED	1	MSL2-35K-UN-XX Led (164CHI-001).IES	662.7201	0.9	11

Statistics						
Description	Symbol	Avg	Max	Min	Max/Min	Avg/Min
Front of Building	+	0.2 fc	3.9 fc	0.0 fc	N/A	N/A
Outside of Parking Lot	+	0.4 fc	4.2 fc	0.0 fc	N/A	N/A
Parking Lot	+	0.3 fc	3.3 fc	0.0 fc	N/A	N/A

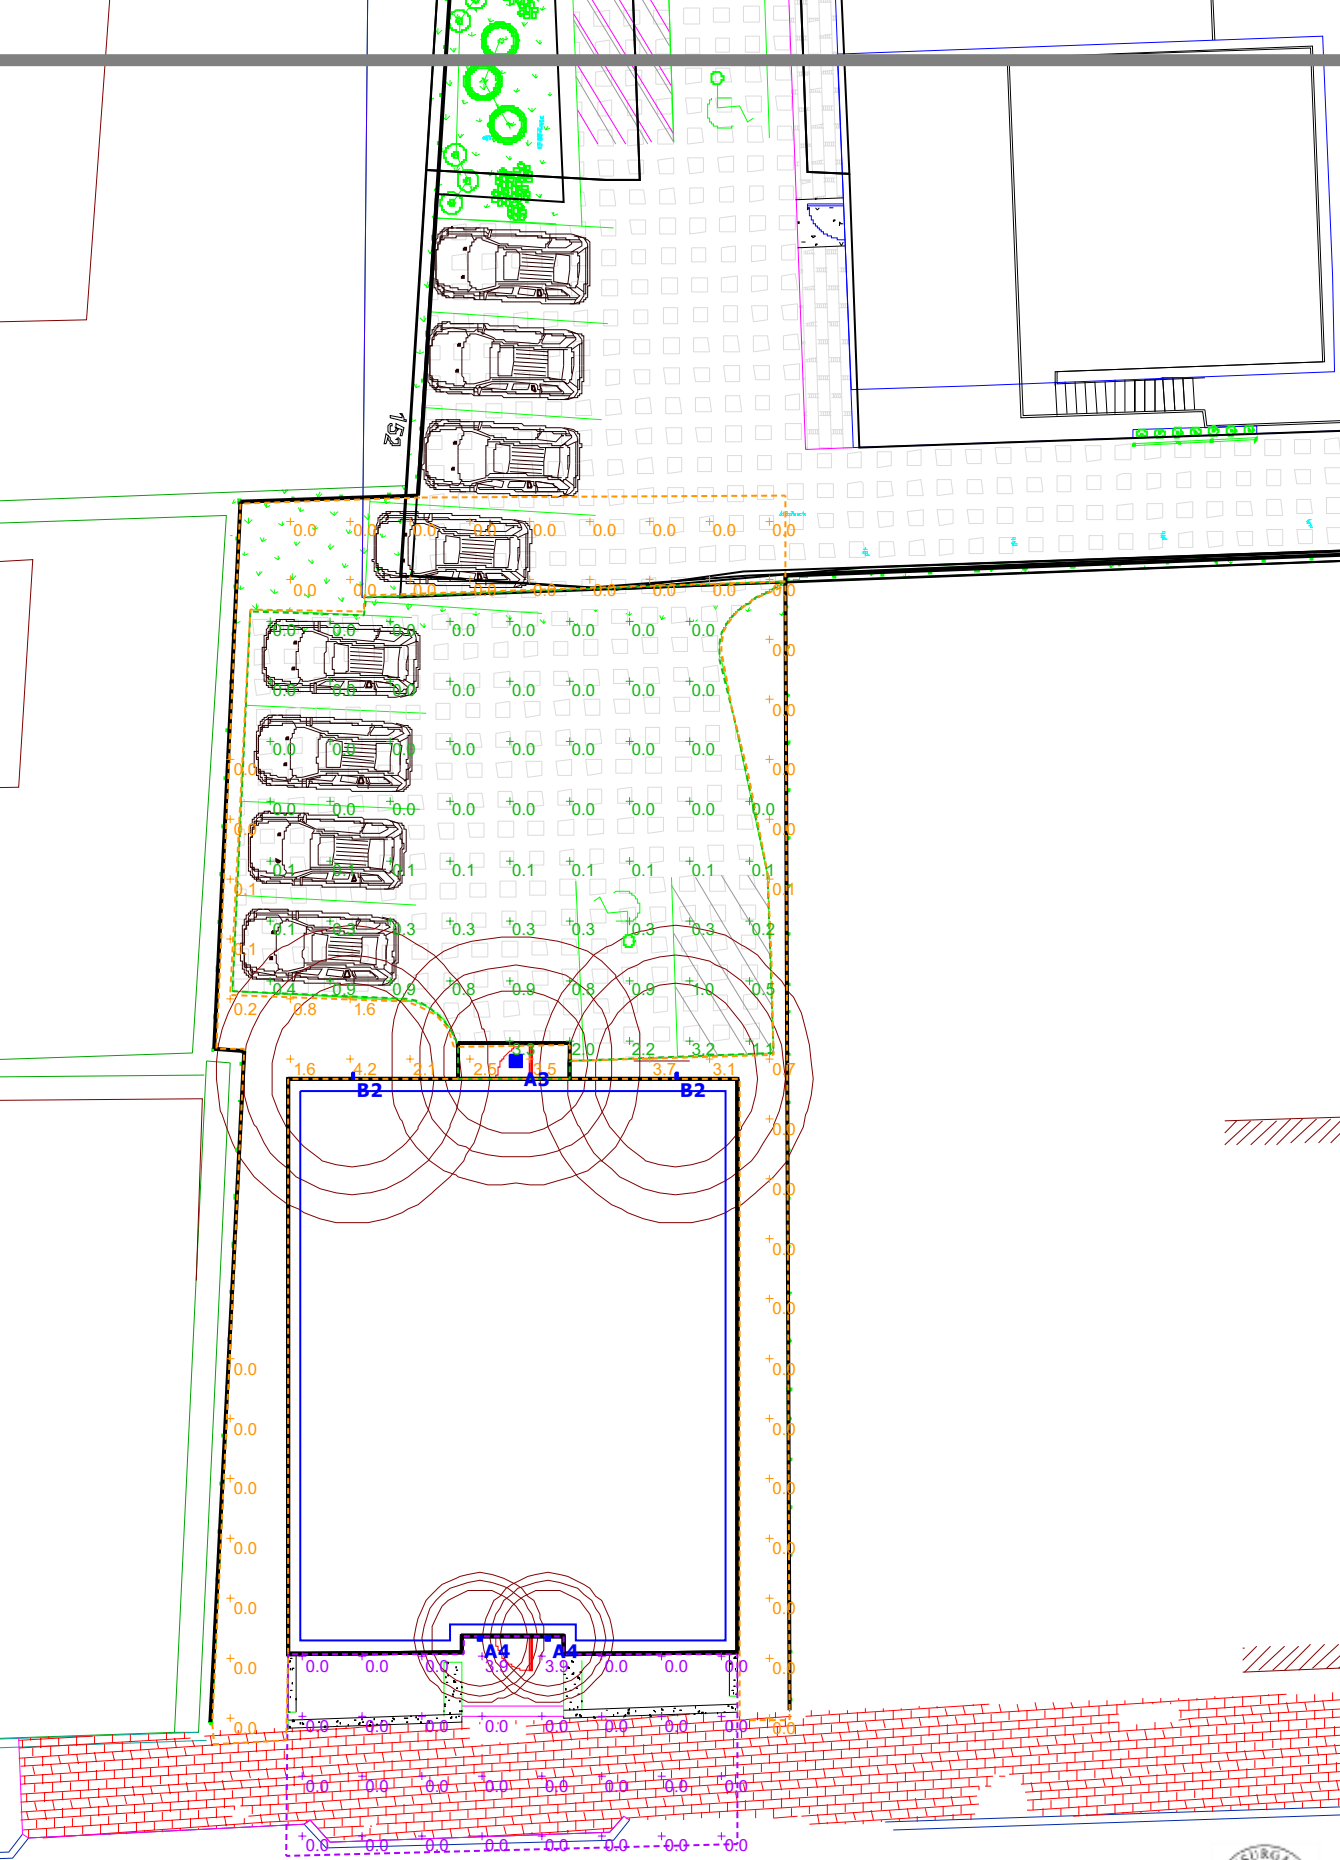

**Plan View**  
Scale - 1" = 16ft



**Designer**  
Heidi G. Connors  
Visible Light, Inc.  
24 Stickney Terrace  
Suite 6  
Hampton, NH 03842

**Date**  
2/20/2017

**Scale**  
Not to Scale

**Drawing No.**  
**CITY OF PORTLAND**  
**APPROVED SITE PLAN**  
**Summary**  
Subject to Conditions of Approval  
and Standard Conditions

**DATE of APPROVAL** May 24, 2017  
**PLANNER** Matthew Grooms  
**PROJECT NO.** 2017-045