


FOURTH FLOOR
SCALE: 1/4" = 1'-0"

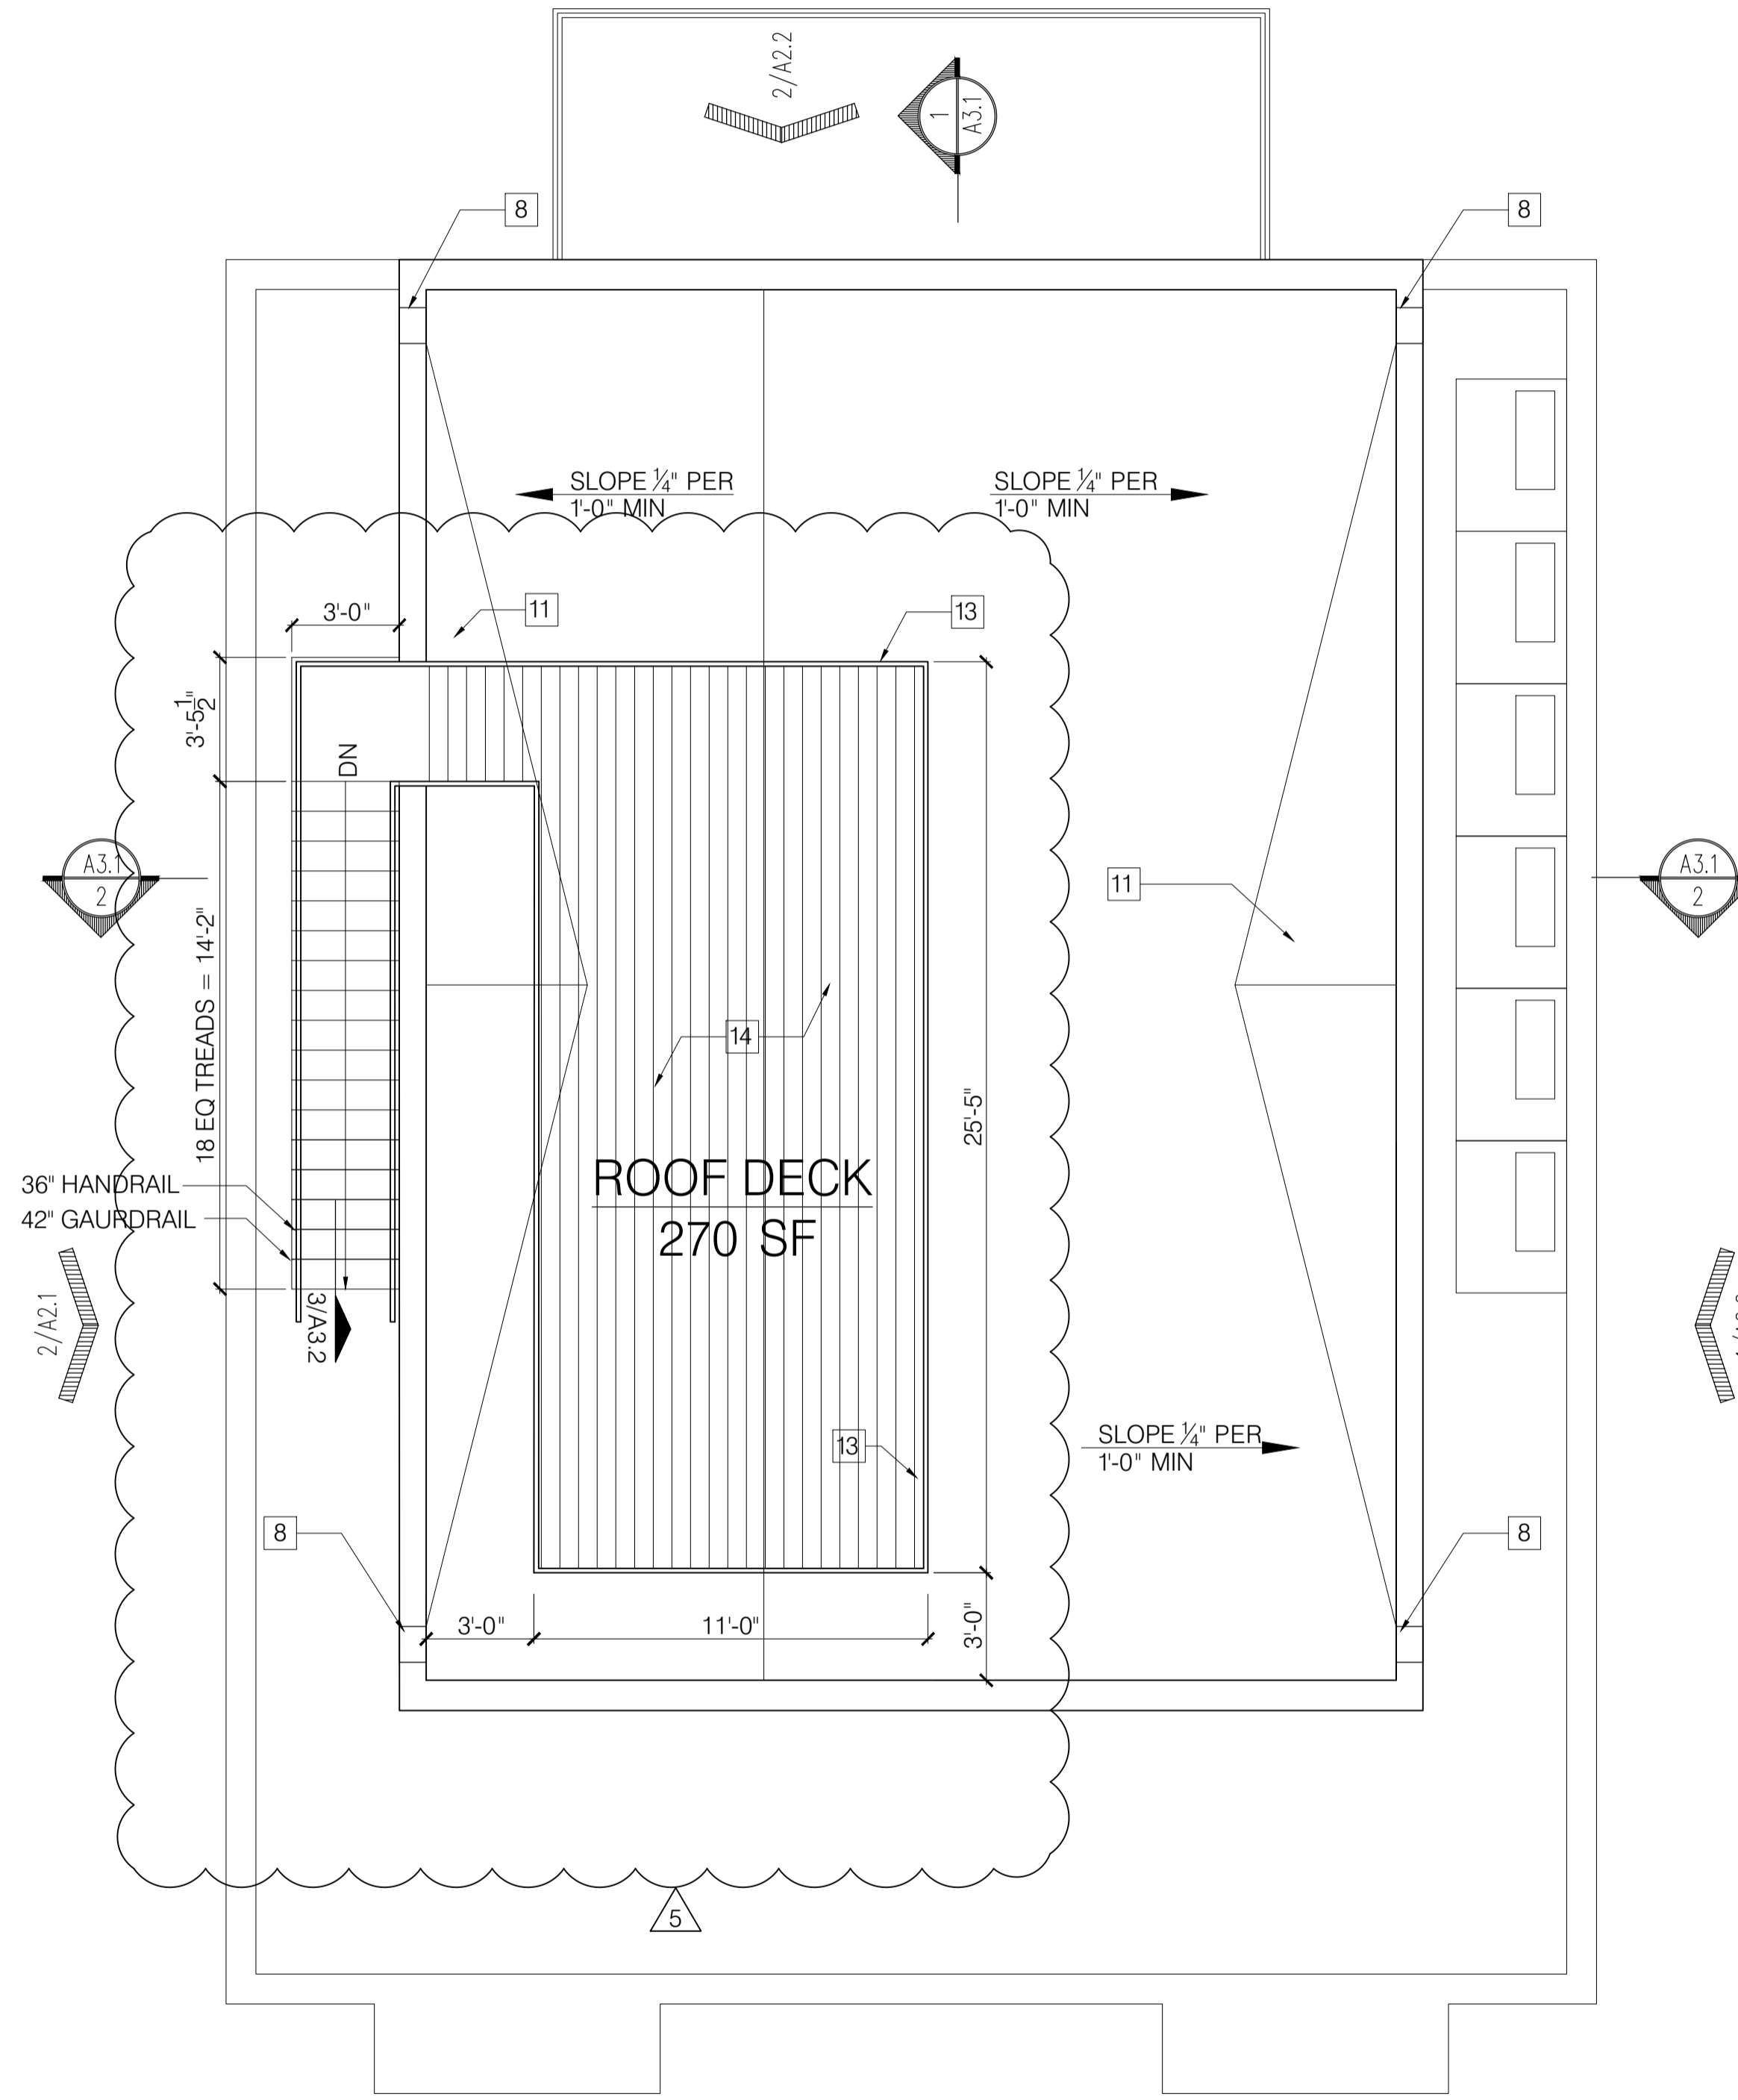

ROOF DECK
SCALE: 1/4" = 1'-0"

- KEYNOTES:**
- - WATER HEATERS
 - ELECTRICAL PANELS
 - FRAMED STAIR OPENING ABOVE
 - LINE OF AWNING ABOVE
 - LINE OF LOWER CEILING
 - PROPOSED LOCATION FOR INSTALLATION OF 6 HEAT PUMP UNITS - VERIFY WITH CONTACTOR
 - ROOF SCUPPER - SEE 10/A3.2 FOR DETAIL
 - NOT USED -
 - MEMBRANE ROOF
 - 1/8" TAPERED INSULATION CRICKET TO PROVIDE POSITIVE SLOPE TO TOP OF ROOF DRAIN /SCUPPER
 - NOT USED -
 - FABRICATED METAL RAILING
 - ROOF DECK SYSTEM
 - CONCRETE STEPS AND PORCH

Bild Architecture
PO Box 8235
Portland, ME
04104
207.408.0168
evan@bildarchitecture.com

licensed ARCHITECT
2/24/17
EVAN A. CARROLL
No. 3887
STATE OF MAINE

PERMIT SET
NOT FOR CONSTRUCTION

PROJECT NO. **16035**
PROJECT NAME **7 CUMBERLAND PORTLAND, ME**

REVISIONS

1	03-15-2017	
2	05-12-2017	
3	07-01-2017	
4	08-07-2017	
5	08-16-2017	

DRAWN BY **EAC**
SHEET TITLE **4TH AND ROOF**

ISSUE DATE **2/24/17**
SHEET SCALE **1/4" = 1'-0"**

A

1-3 CITY OF PORTLAND
APPROVED SITE PLAN
Subject to Conditions of Approval
and Standard Conditions