

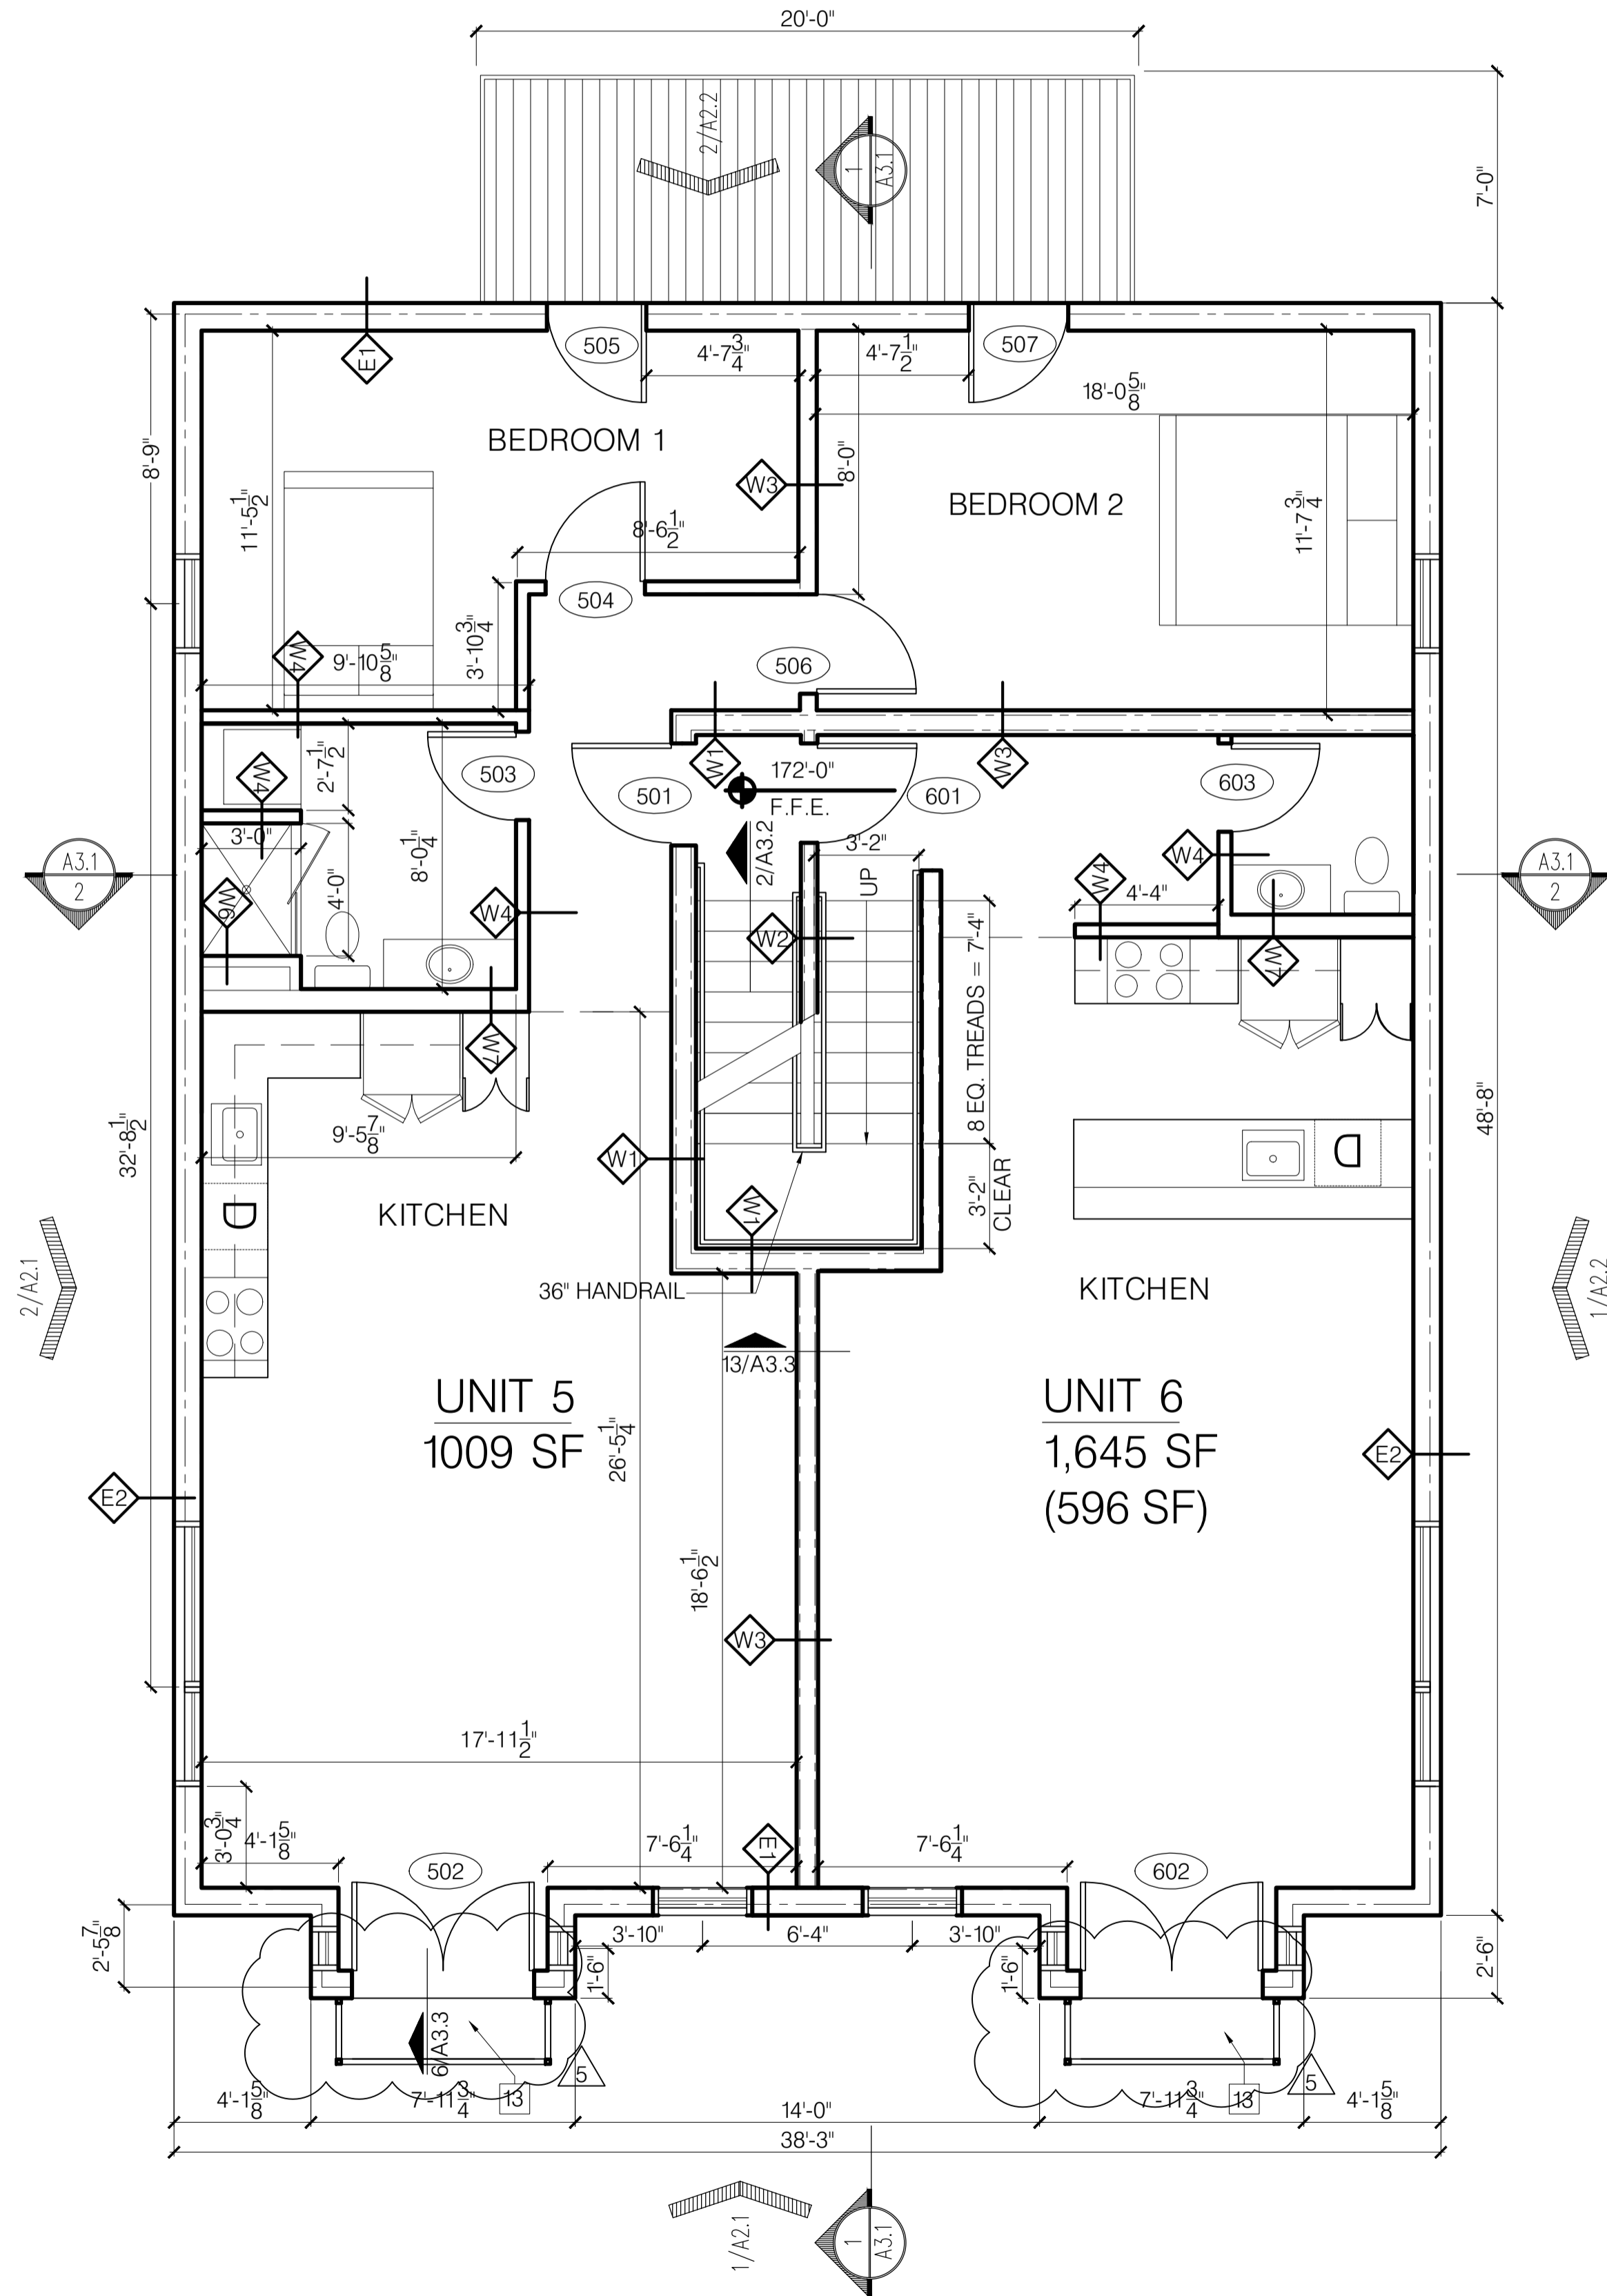


3 SECOND FLOOR
SCALE: 1/4" = 1'-0"

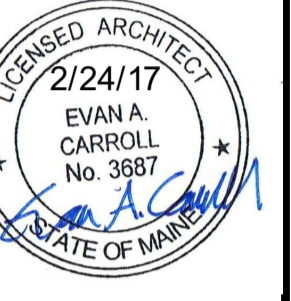

4 THIRD FLOOR
SCALE: 1/4" = 1'-0"

- KEYNOTES:**
- - WATER HEATERS
 - ELECTRICAL PANELS
 - FRAMED STAIR OPENING ABOVE
 - LINE OF AWNING ABOVE
 - LINE OF LOWER CEILING
 - PROPOSED LOCATION FOR INSTALLATION OF 6 HEAT PUMP UNITS - VERIFY WITH CONTACTOR
 - ROOF SCUPPER - SEE 10/A3.2 FOR DETAIL
 - NOT USED -
 - MEMBRANE ROOF
 - 1/8" TAPERED INSULATION CRICKET TO PROVIDE POSITIVE SLOPE TO TOP OF ROOF DRAIN /SCUPPER
 - NOT USED -
 - FABRICATED METAL RAILING
 - ROOF DECK SYSTEM
 - CONCRETE STEPS AND PORCH

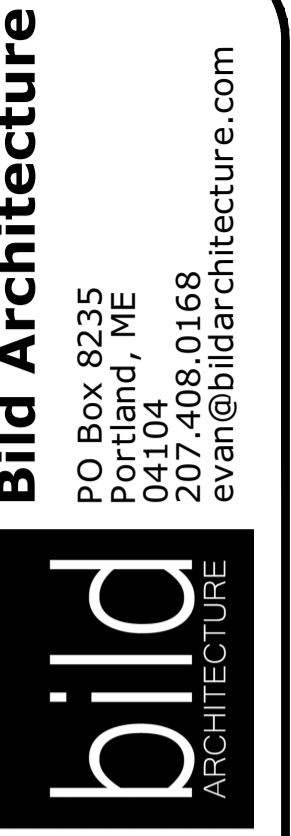

PROJECT NO. 16035
PROJECT NAME 7 CUMBERLAND PORTLAND, ME

REVISIONS

1	03-15-2017	
2	05-12-2017	
3	07-01-2017	
4	08-07-2017	
5	08-16-2017	

PERMIT SET
NOT FOR CONSTRUCTION

DRAWN BY EAC
SHEET TITLE 2ND 3RD FLOOR

ISSUE DATE 2/24/17
DATE OF APPROVAL 2/24/17

1.2
CITY OF PORTLAND
APPROVED SITE PLAN
Subject to Conditions of Approval and Standard Conditions

