



SECOND FLOOR
1/4" = 1'-0"

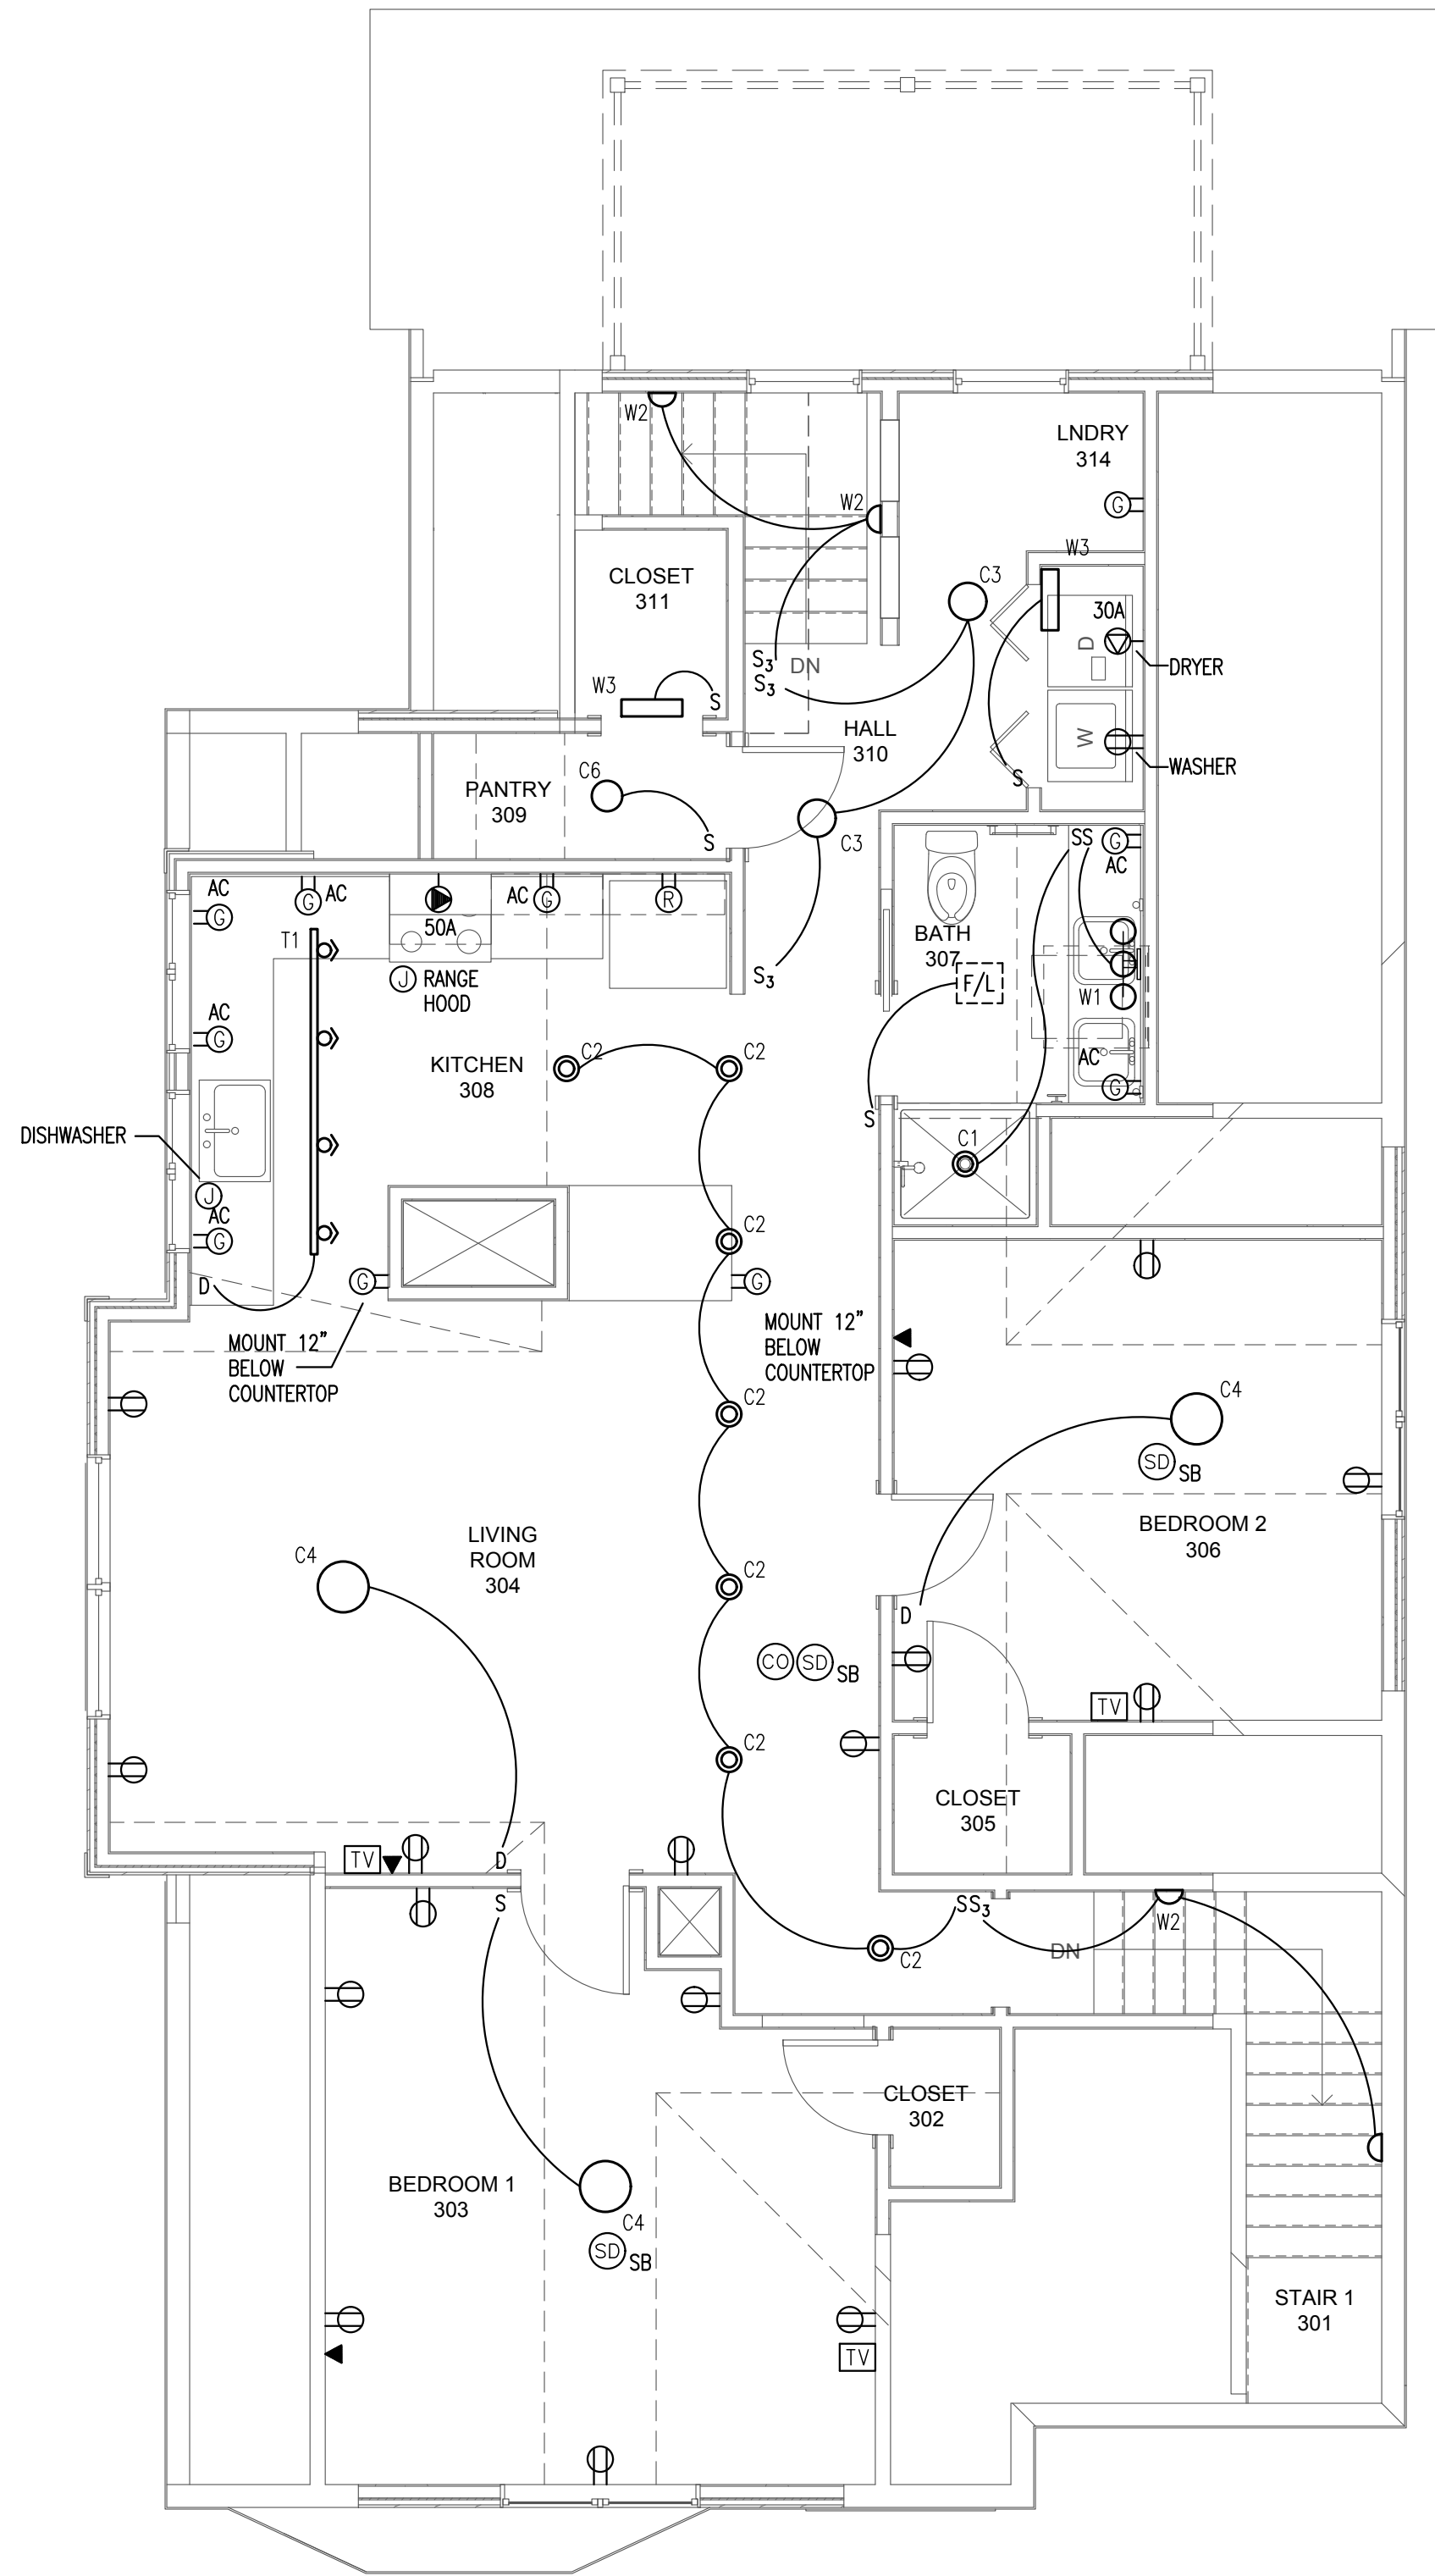

THIRD FLOOR
1/4" = 1'-0"

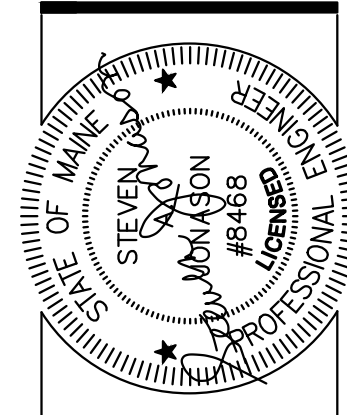

Ella Housing
 77-79 Congress Street

BRIBURN
 architecture for life
28 Maple St | Suite 202 | Portland, ME 04107 | 207.774.8482

CONSULTANTS:

PROJECT NO: 1706
 ISSUED: 11/03/17
 DRAWN BY: JLC
 CHECKED BY: WSB
 SHEET TITLE:
 2ND AND
 3RD FLOOR
 ELECTRICAL PLANS

A-E102

ISSUED FOR CONSTRUCTION