

**ELLA HOUSING - 79 CONGRESS**  
 79 CONGRESS ST, PORTLAND, ME  
 RENOVATIONS



CONSULTANTS:

REVISIONS:

No.	Name	Date
1	REV 1	11/21/17
2	REV 2	12/5/17

**ISSUED FOR PERMITTING**


ISSUED: 10/13/2017  
 PROJECT No: 1706  
 DRAWN BY: LG  
 CHECKED BY: HH

SHEET TITLE:  
 DEMOLITION PLANS


**C-D101**

DEMOLITION KEY NOTE LEGEND	
Key Value	Keynote Text
D6	DEMO WALL AS REQUIRED FOR NEW DOOR/WINDOW OPENING
D7	DEMO WALL AS INDICATED
D9	REMOVE PLUMBING FIXTURE AND ASSOCIATED PIPING BACK TO SOURCE
D10	REMOVE BUILT-IN CASEWORK/CABINERY
D13	REMOVE BRICK CHIMNEY/FIREPLACE
D14	REMOVE PANELLING FROM WALL
D15	REMOVE WALLPAPER
D17	REMOVE PANELLING FROM CEILING
D23	REMOVE CARPET, PAD, AND VINYL SHEET
D24	REMOVE SHEET VINYL AND WOOD UNDERLAYMENT
D25	REMOVE VINYL TILES
D26	REMOVE VINYL TILE AND SHEET VINYL
D27	REMOVE LAMINATE FLOORING, CARPET, AND PAD

REMOVE ALL WINDOWS AND PREPARE FOR REPLACEMENT UNLESS NOTED OTHERWISE

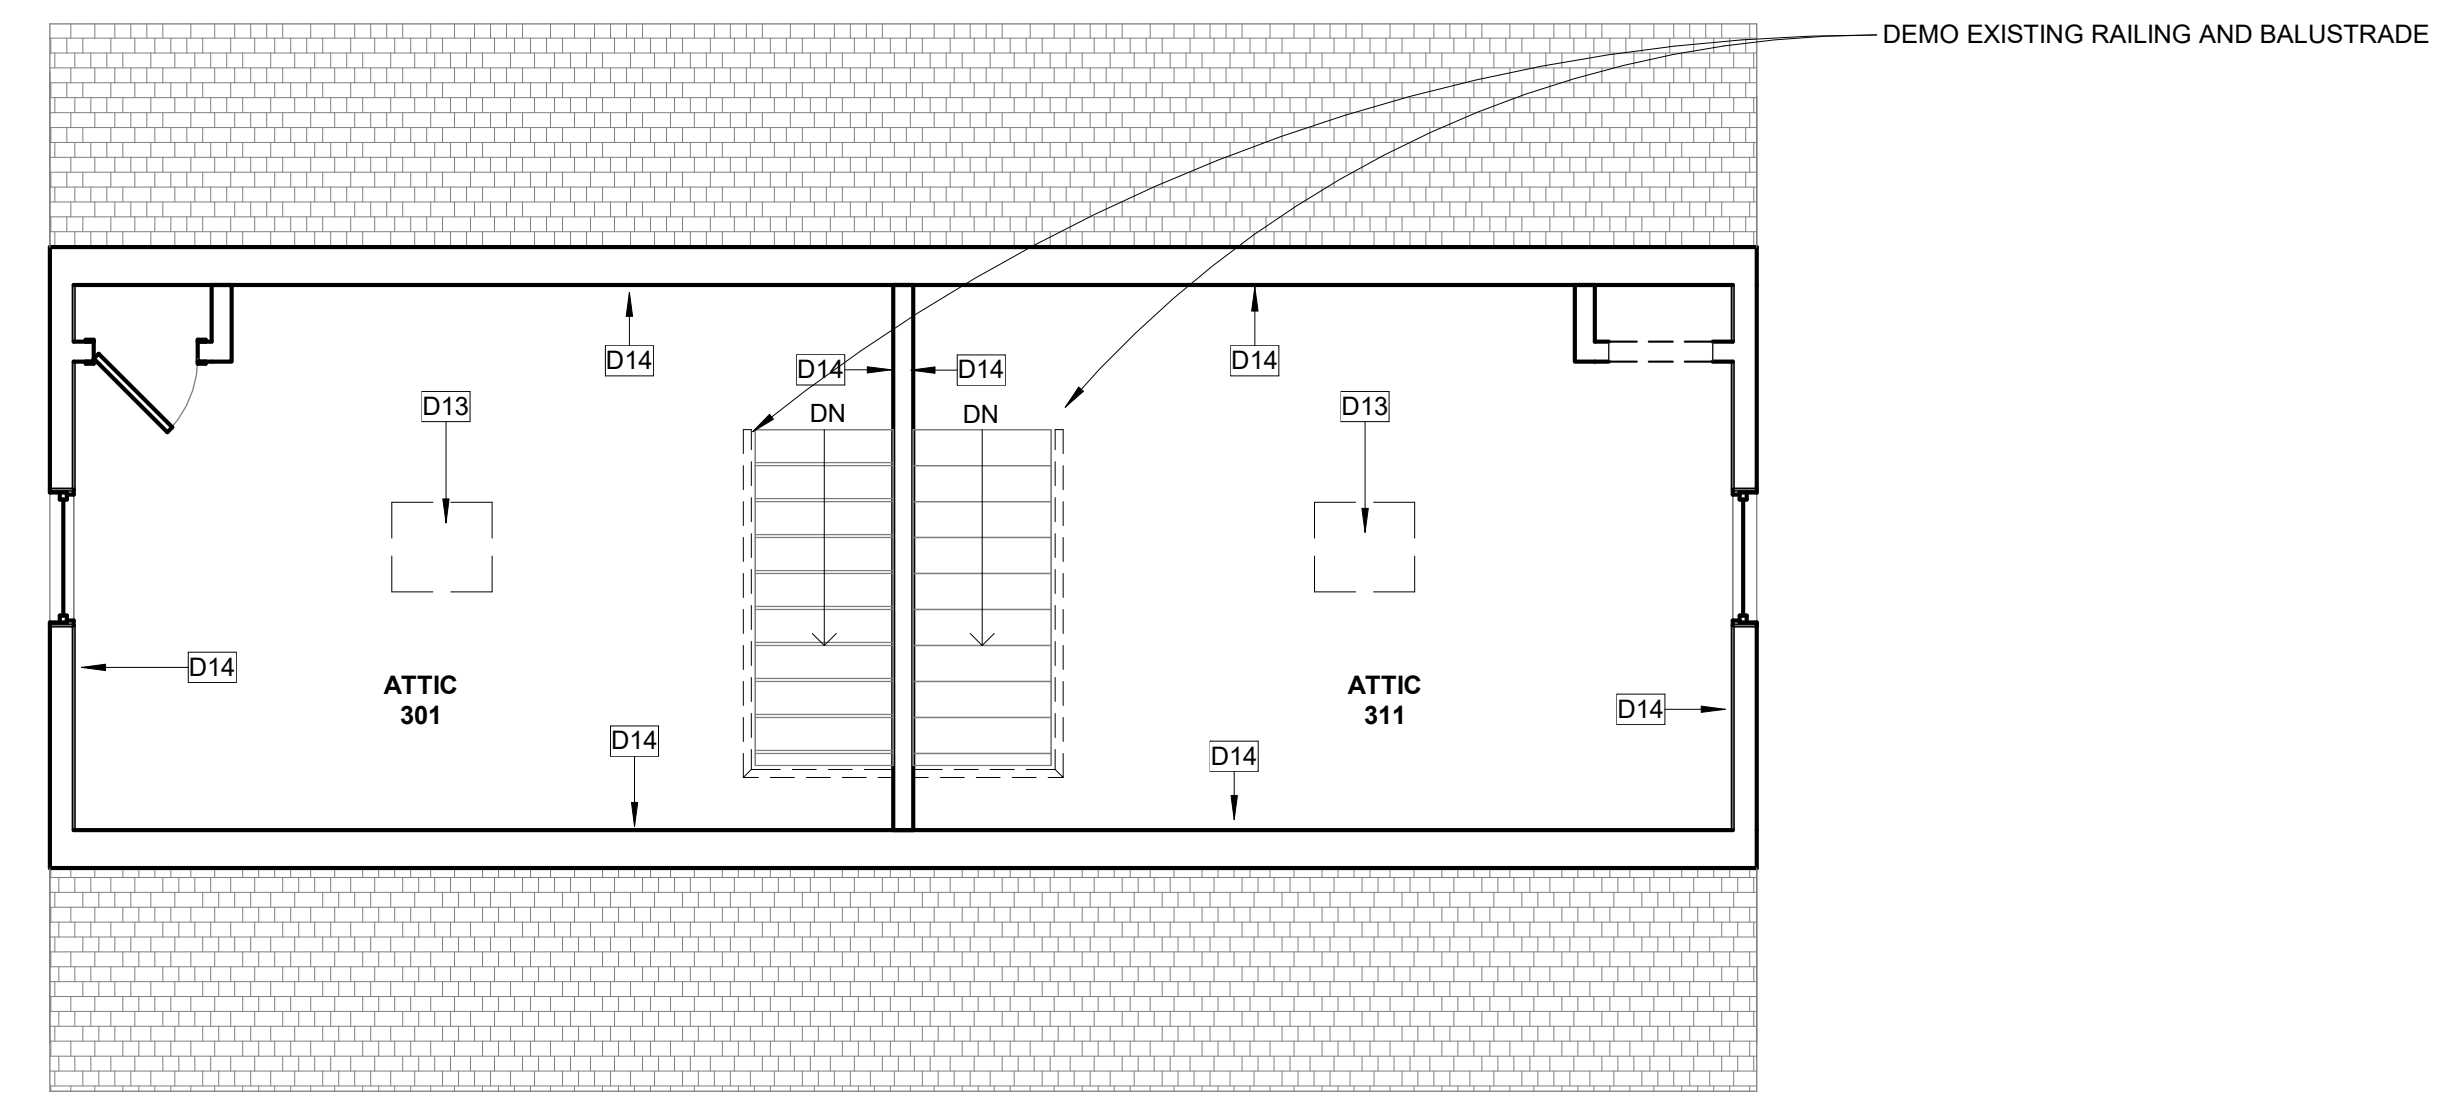

④ Level 03 Demo Floor Plan  
 1/4" = 1'-0"

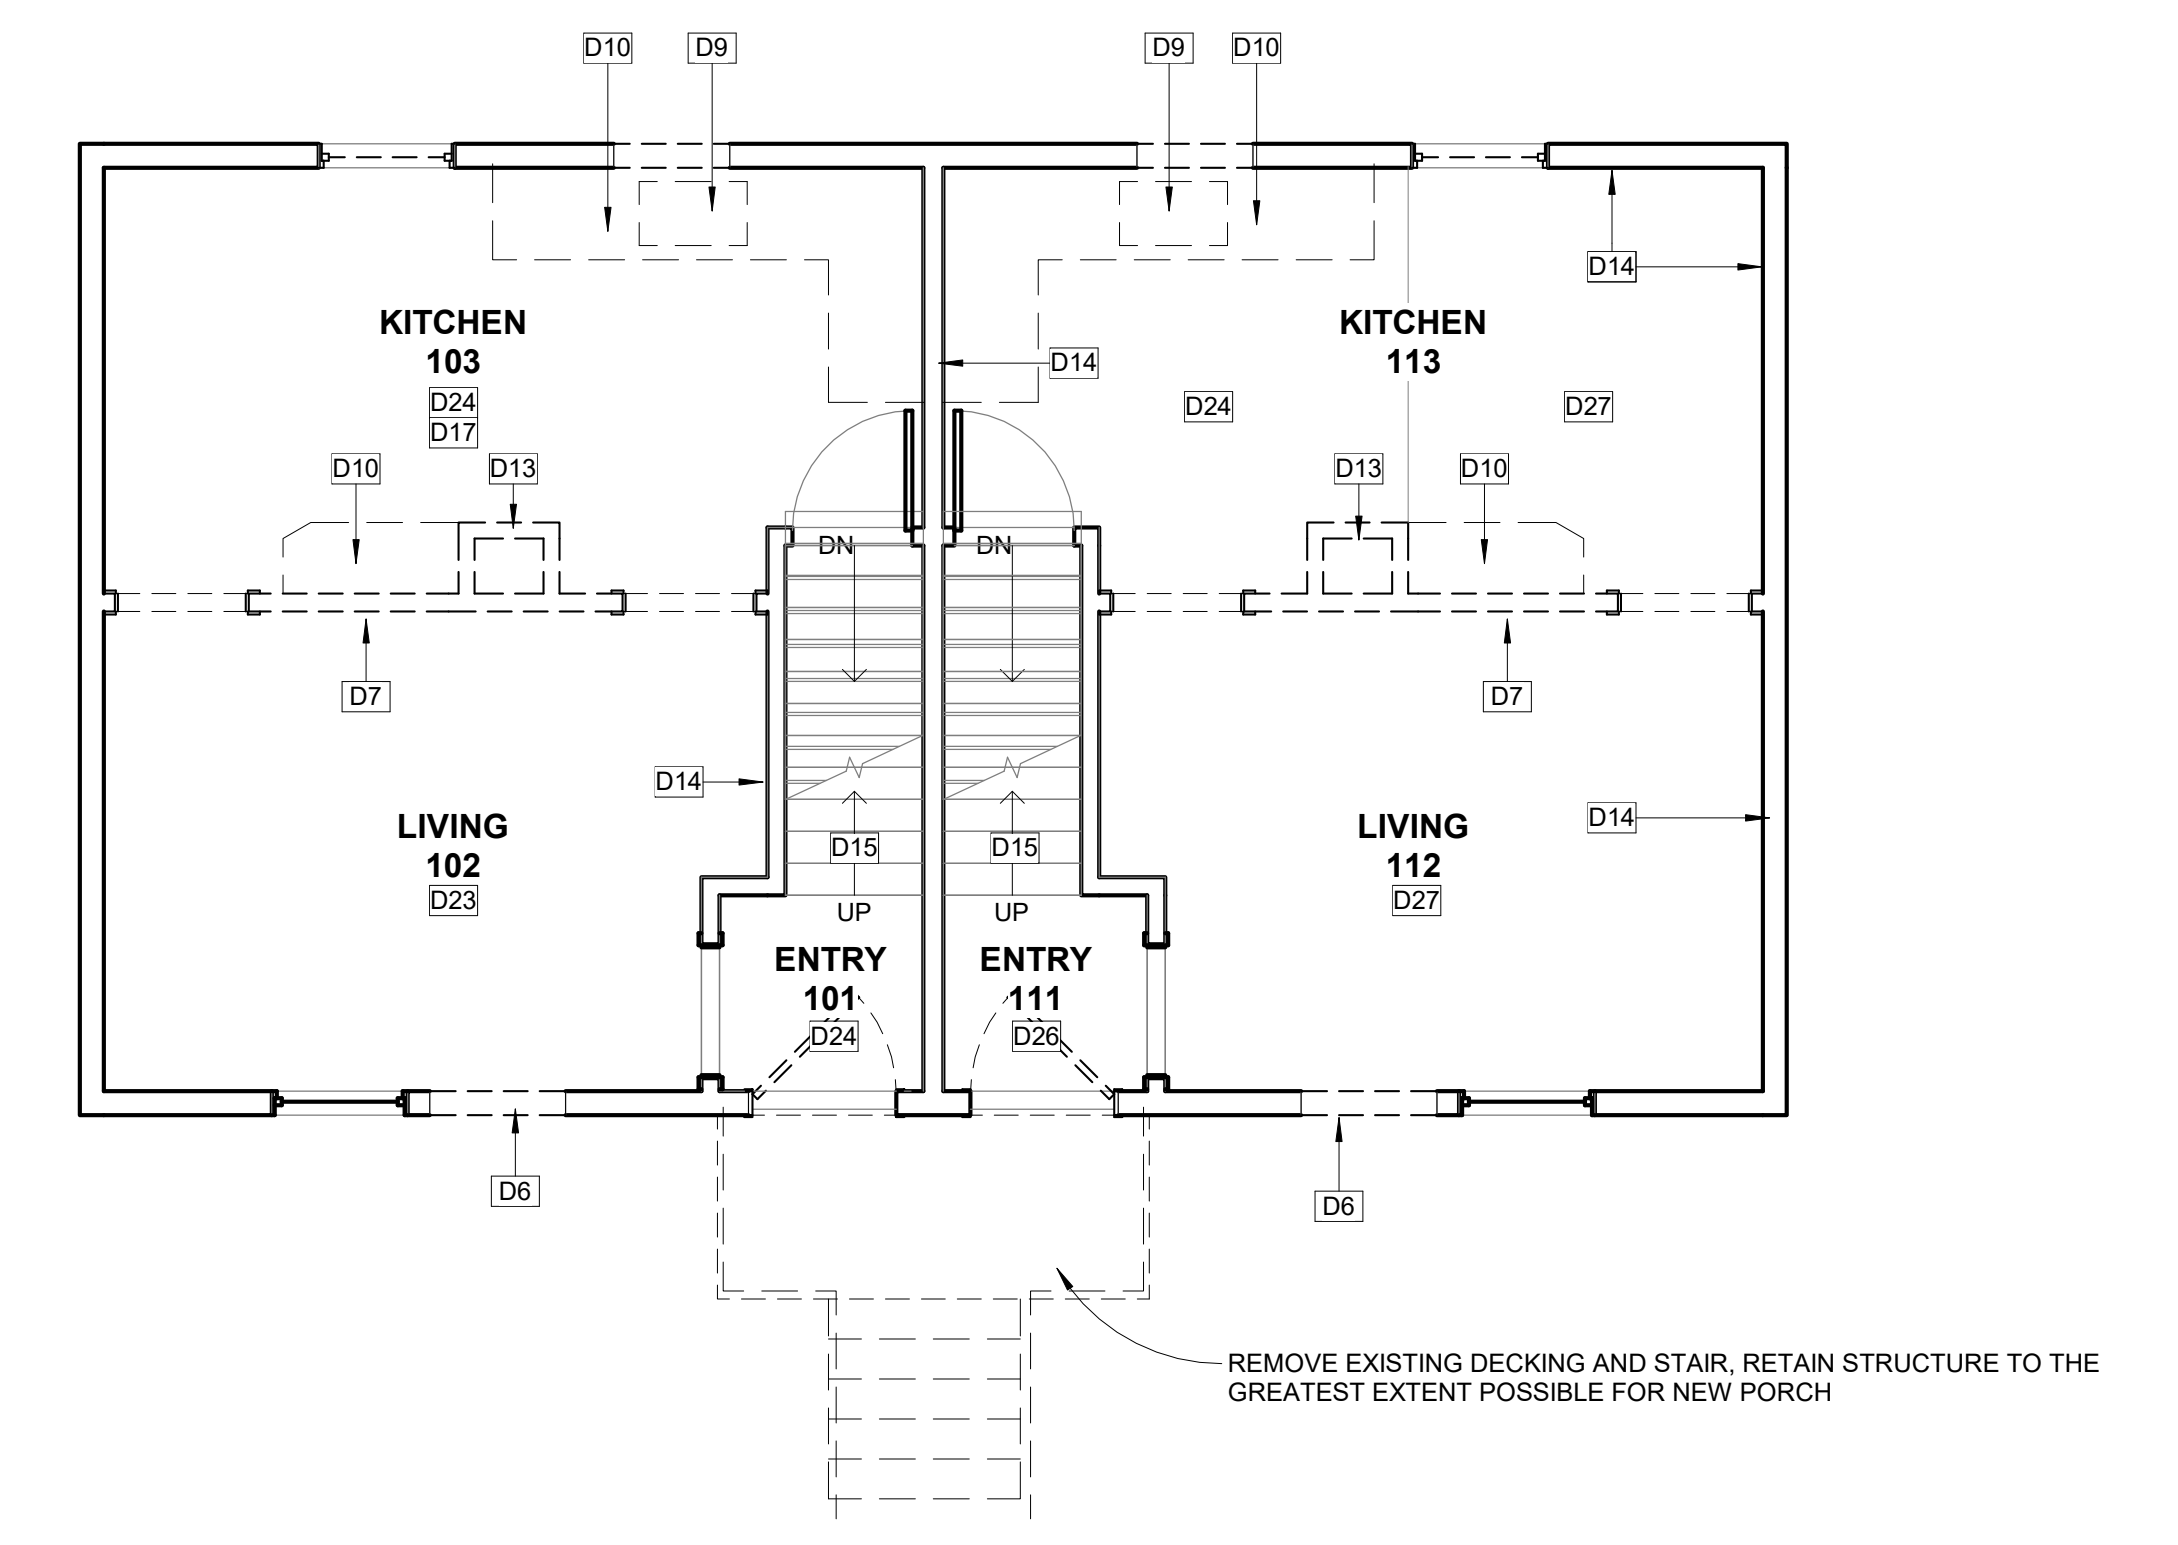

③ Level 01 Demo Floor Plan  
 1/4" = 1'-0"

