




ELECTRICAL - DATA - AUDIO LEGEND	
SYMBOL	DESCRIPTION
	Ceiling Fan
	Ventilation Fans: Ceiling Mounted, Wall Mounted
	Ceiling Mounted Light Fixtures: Surface/Pendant, Recessed, Heat Lamp, Low Voltage
	Wall Mounted Light Fixtures: Flush Mounted, Wall Sconce
	Chandelier Light Fixture
	Fluorescent Light Fixture
	240V Receptacle
	110V Receptacles: Duplex, Weather Proof, GFCI
	Switches: Single Pole, Weather Proof, 3-Way, 4-Way
	Switches: Dimmer, Timer
	Audio Video: Control Panel, Switch
	Speakers: Ceiling Mounted, Wall Mounted
	Wall Jacks: CAT5, CAT5 + TV, TV/Cable
	Telephone Jack
	Intercom
	Thermostat
	Door Chime, Door Bell Button
	Smoke Detectors: Ceiling Mounted, Wall Mounted
	Electrical Breaker Panel

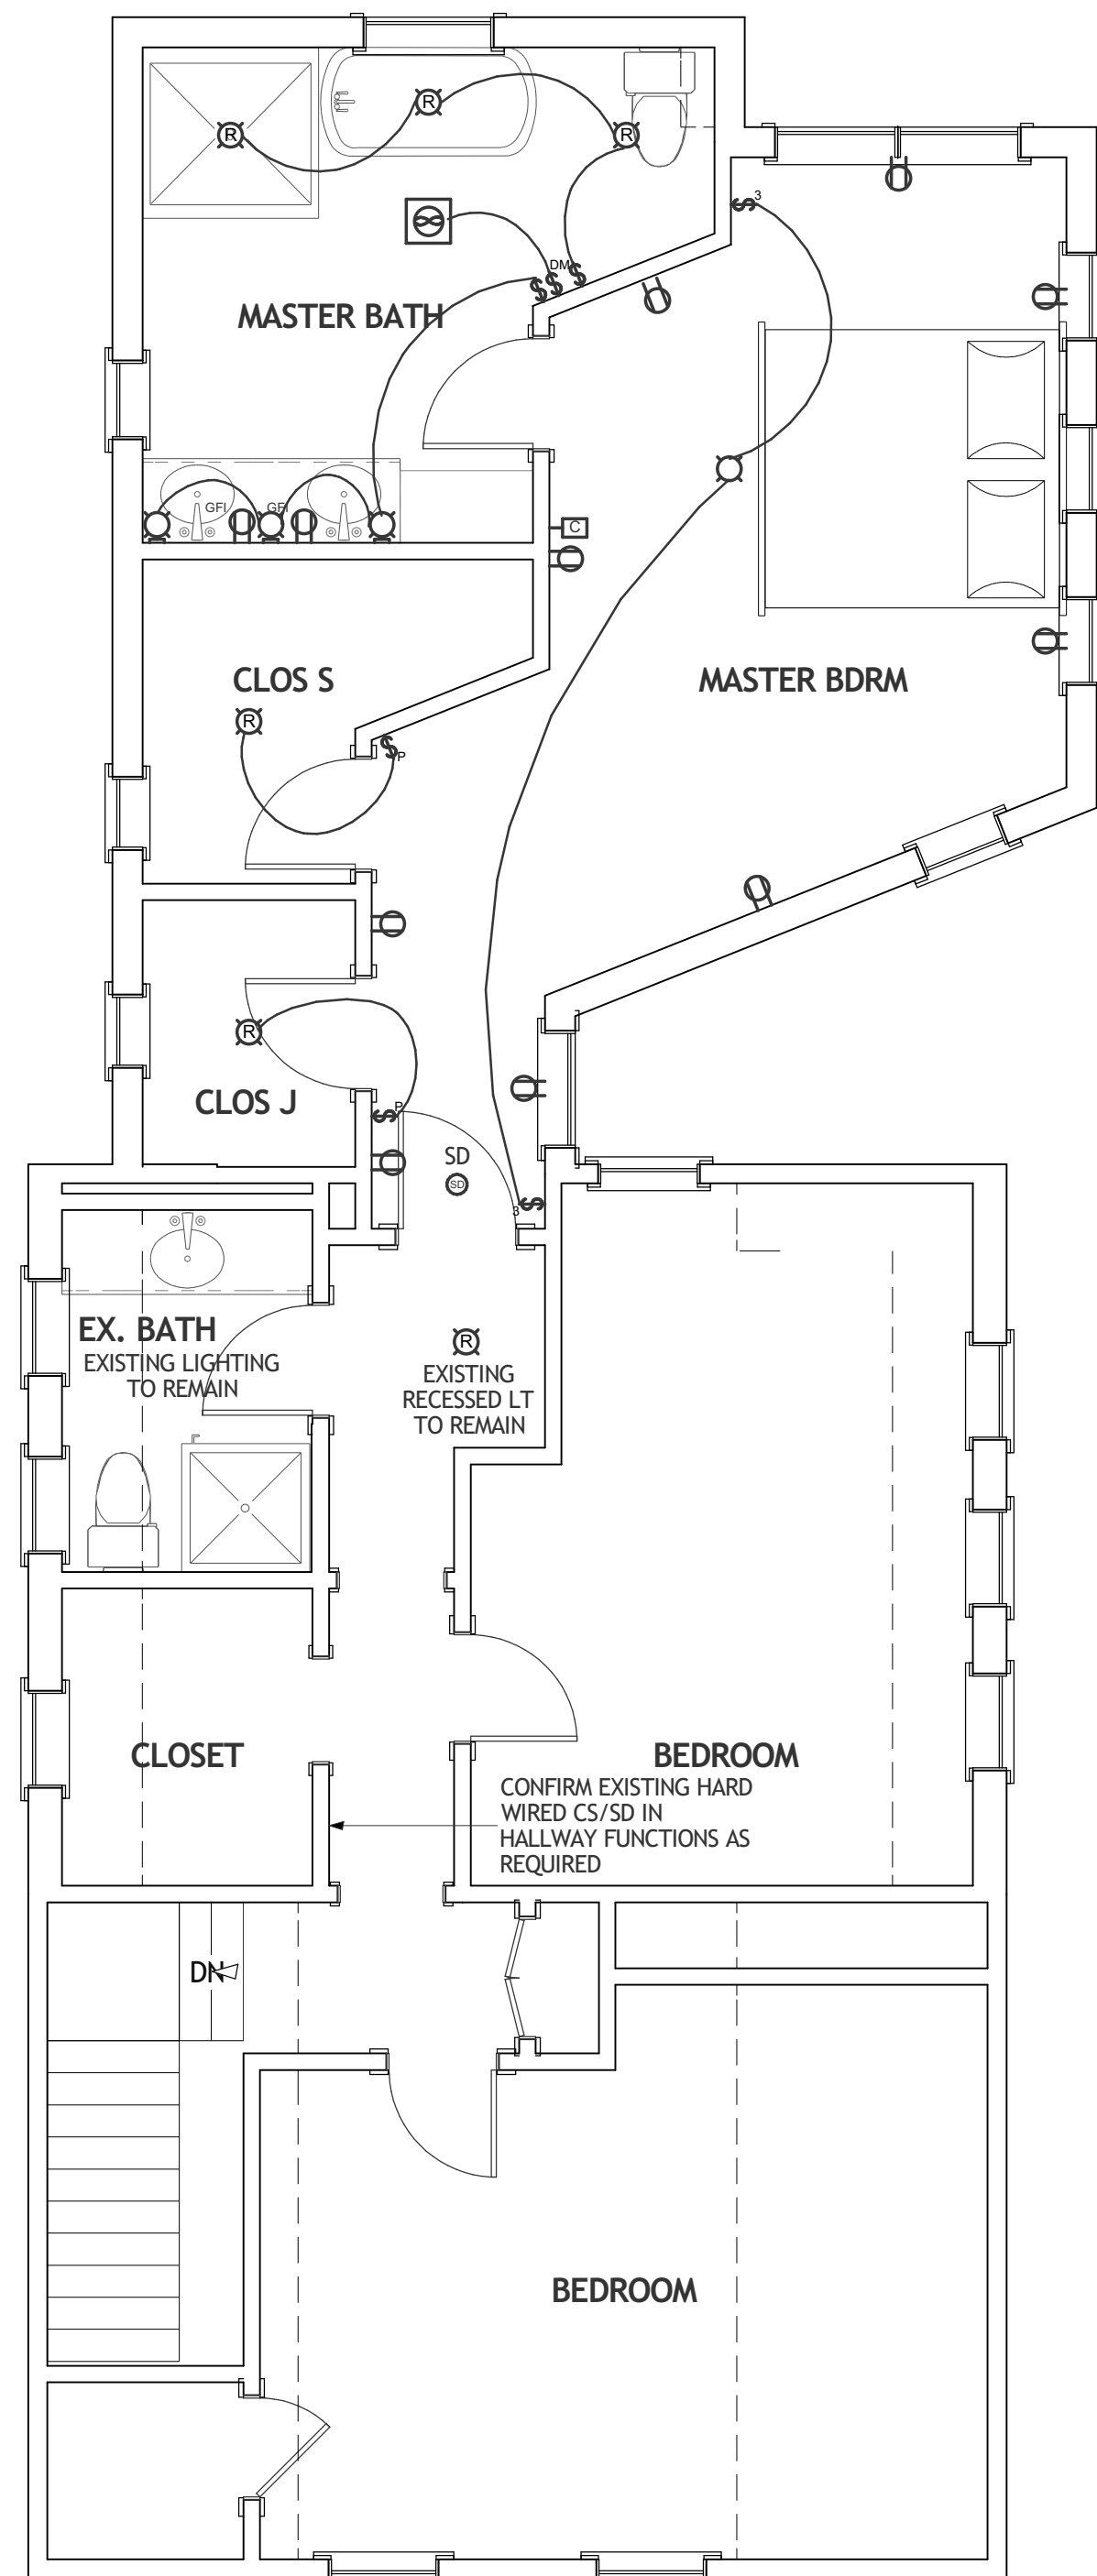

3 Second Floor Electrical Plan  
SCALE: 1/4" = 1' - 0"

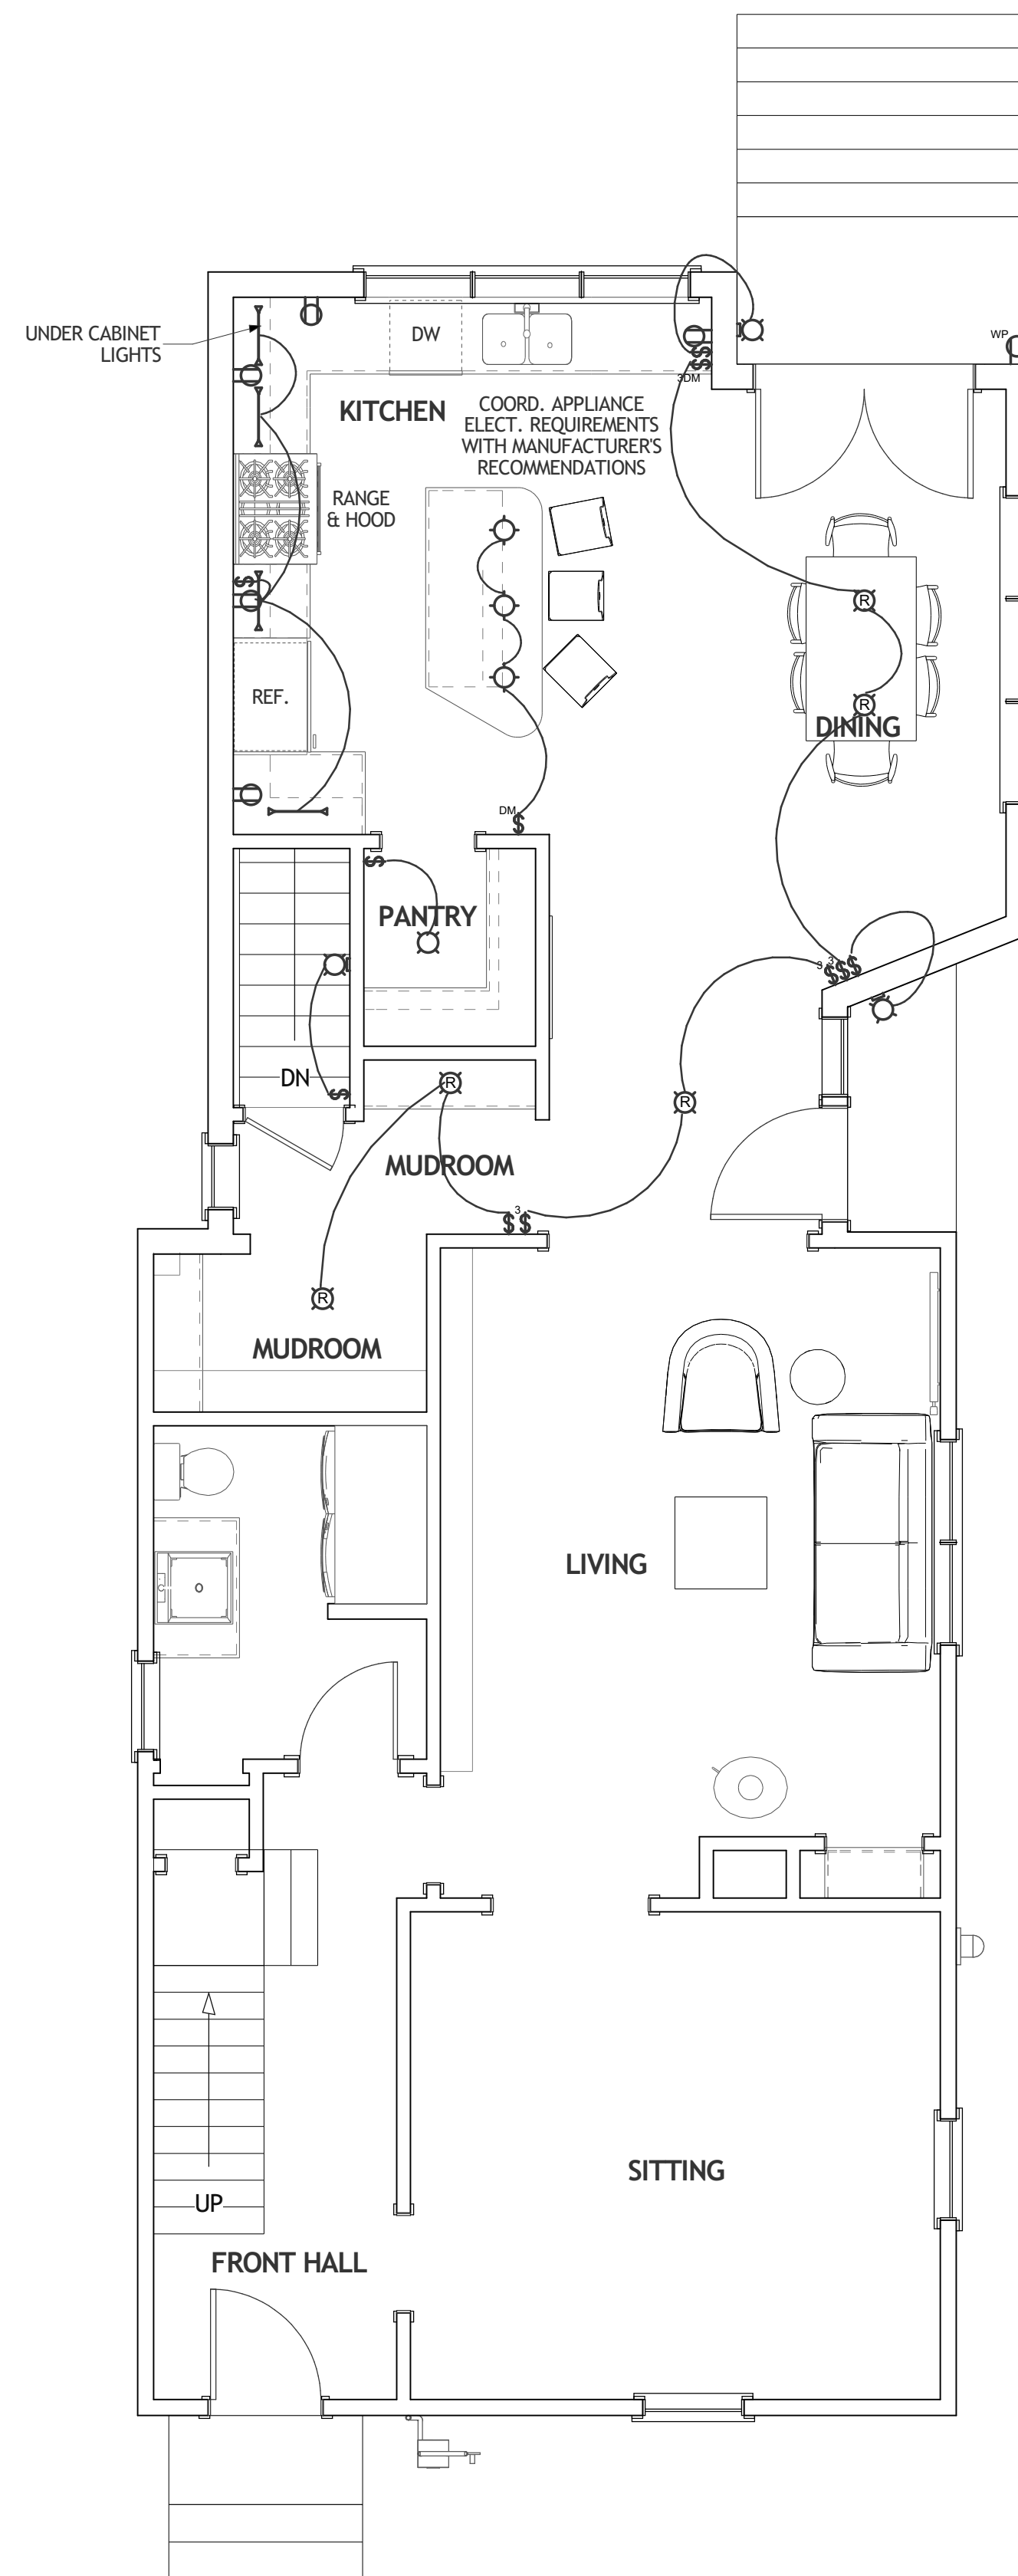

2 First Floor Electrical Plan  
SCALE: 1/4" = 1' - 0"

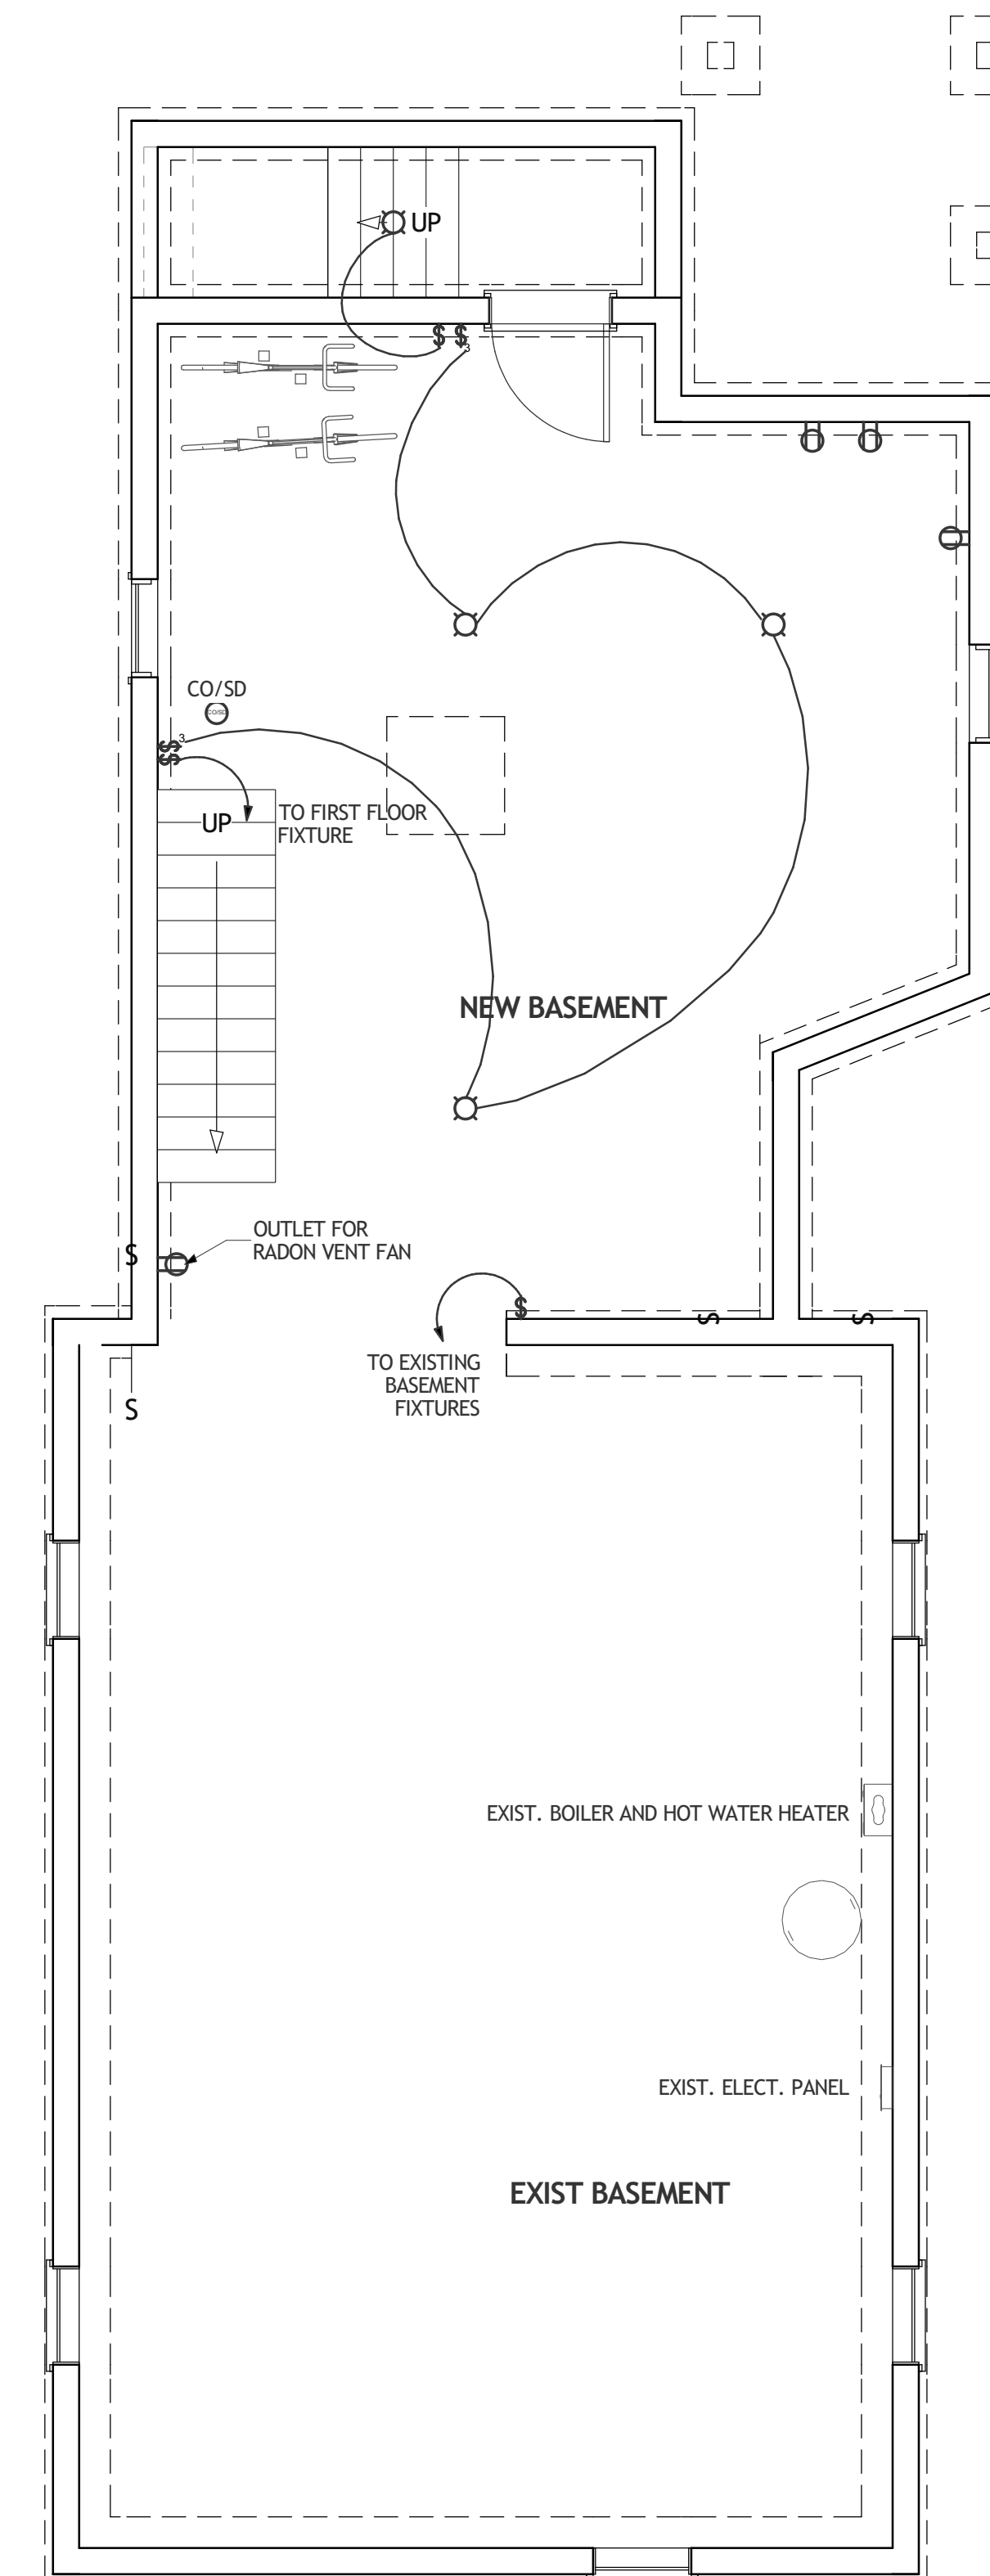

1 Basement Electrical Plan  
SCALE: 1/4" = 1' - 0"

DRAFT ELECTRICAL LAYOUT.  
TO BE CONFIRMED BY  
WALKTHROUGH WITH  
OWNER AND ELECTRICIAN.

Kevin Moquin Architect  
km  
Info@km-a.me  
(207)-615-6421  
Revisions:  
\_\_\_\_\_  
\_\_\_\_\_  
\_\_\_\_\_

Ritzo-Buck  
Addition  
15 Howard Street  
Portland, Maine

0 1 2 4 7  
Graphic Scale 1/4" = 1'-0"

PERMIT SET

Electrical Plans

8/28/2015  
E1.1  
7 of 7