



*GROUND BARS AT THE BOTTOM OF TOWERS/MONOPOLES SHALL ONLY USE EXOTHERMIC WELDS.

1 GROUND WIRE TO CIGBE DETAIL
G-1 SCALE: N.T.S.

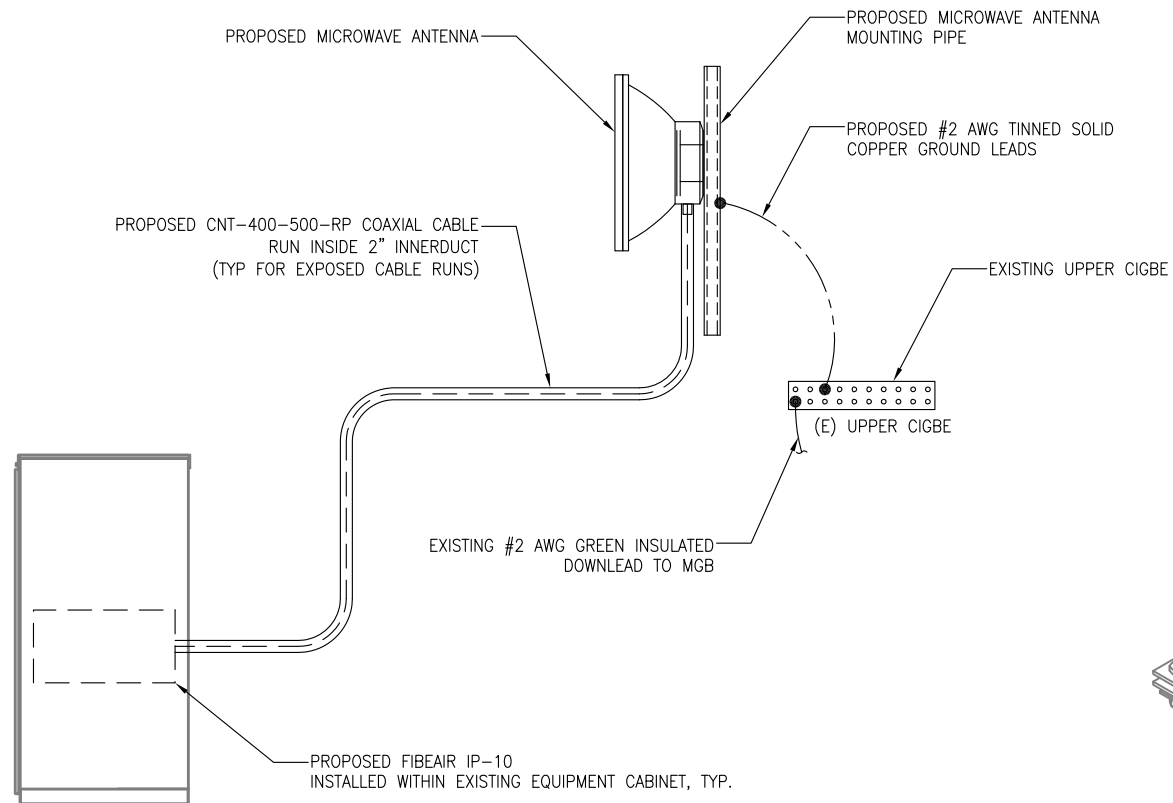

2 DISH ANTENNA WIRING SCHEMATIC
G-1 SCALE: N.T.S.

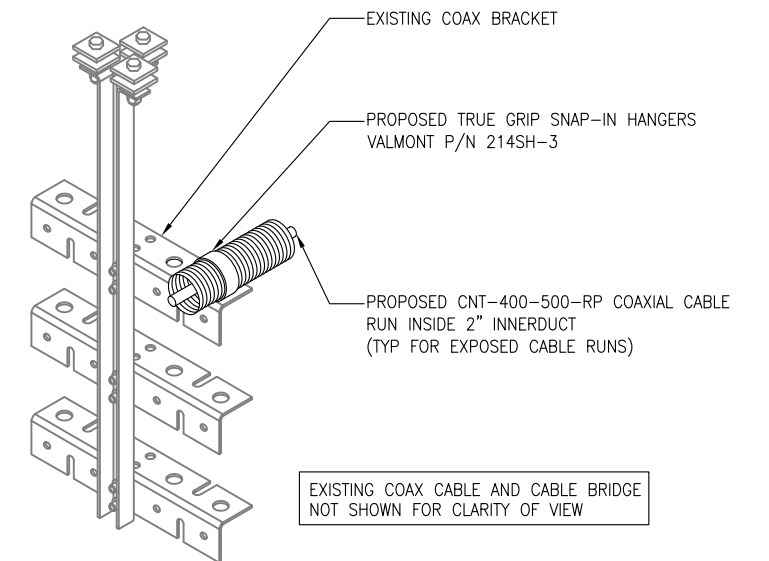

3 HOR. INNERDUCT/COAX DETAIL
G-1 SCALE: N.T.S.



Marc R. Chretien

NO.	DATE	REVISIONS	BY	CHK	APP'D
0	11/24/15	CONSTRUCTION	DD	SNA	SNA

SCALE: AS SHOWN DESIGNED BY: SNA DRAWN BY: DD

T-MOBILE		
GROUNDING, ONE-LINE DIAGRAM & NOTES		
JOB NUMBER	DRAWING NUMBER	REV
4DN2283A	G-1	0