


2 ELECTRICAL ROOF PLAN
SCALE: 1/4" = 1'-0"



1 ELECTRICAL 3RD FLOOR PLAN
SCALE: 1/4" = 1'-0"

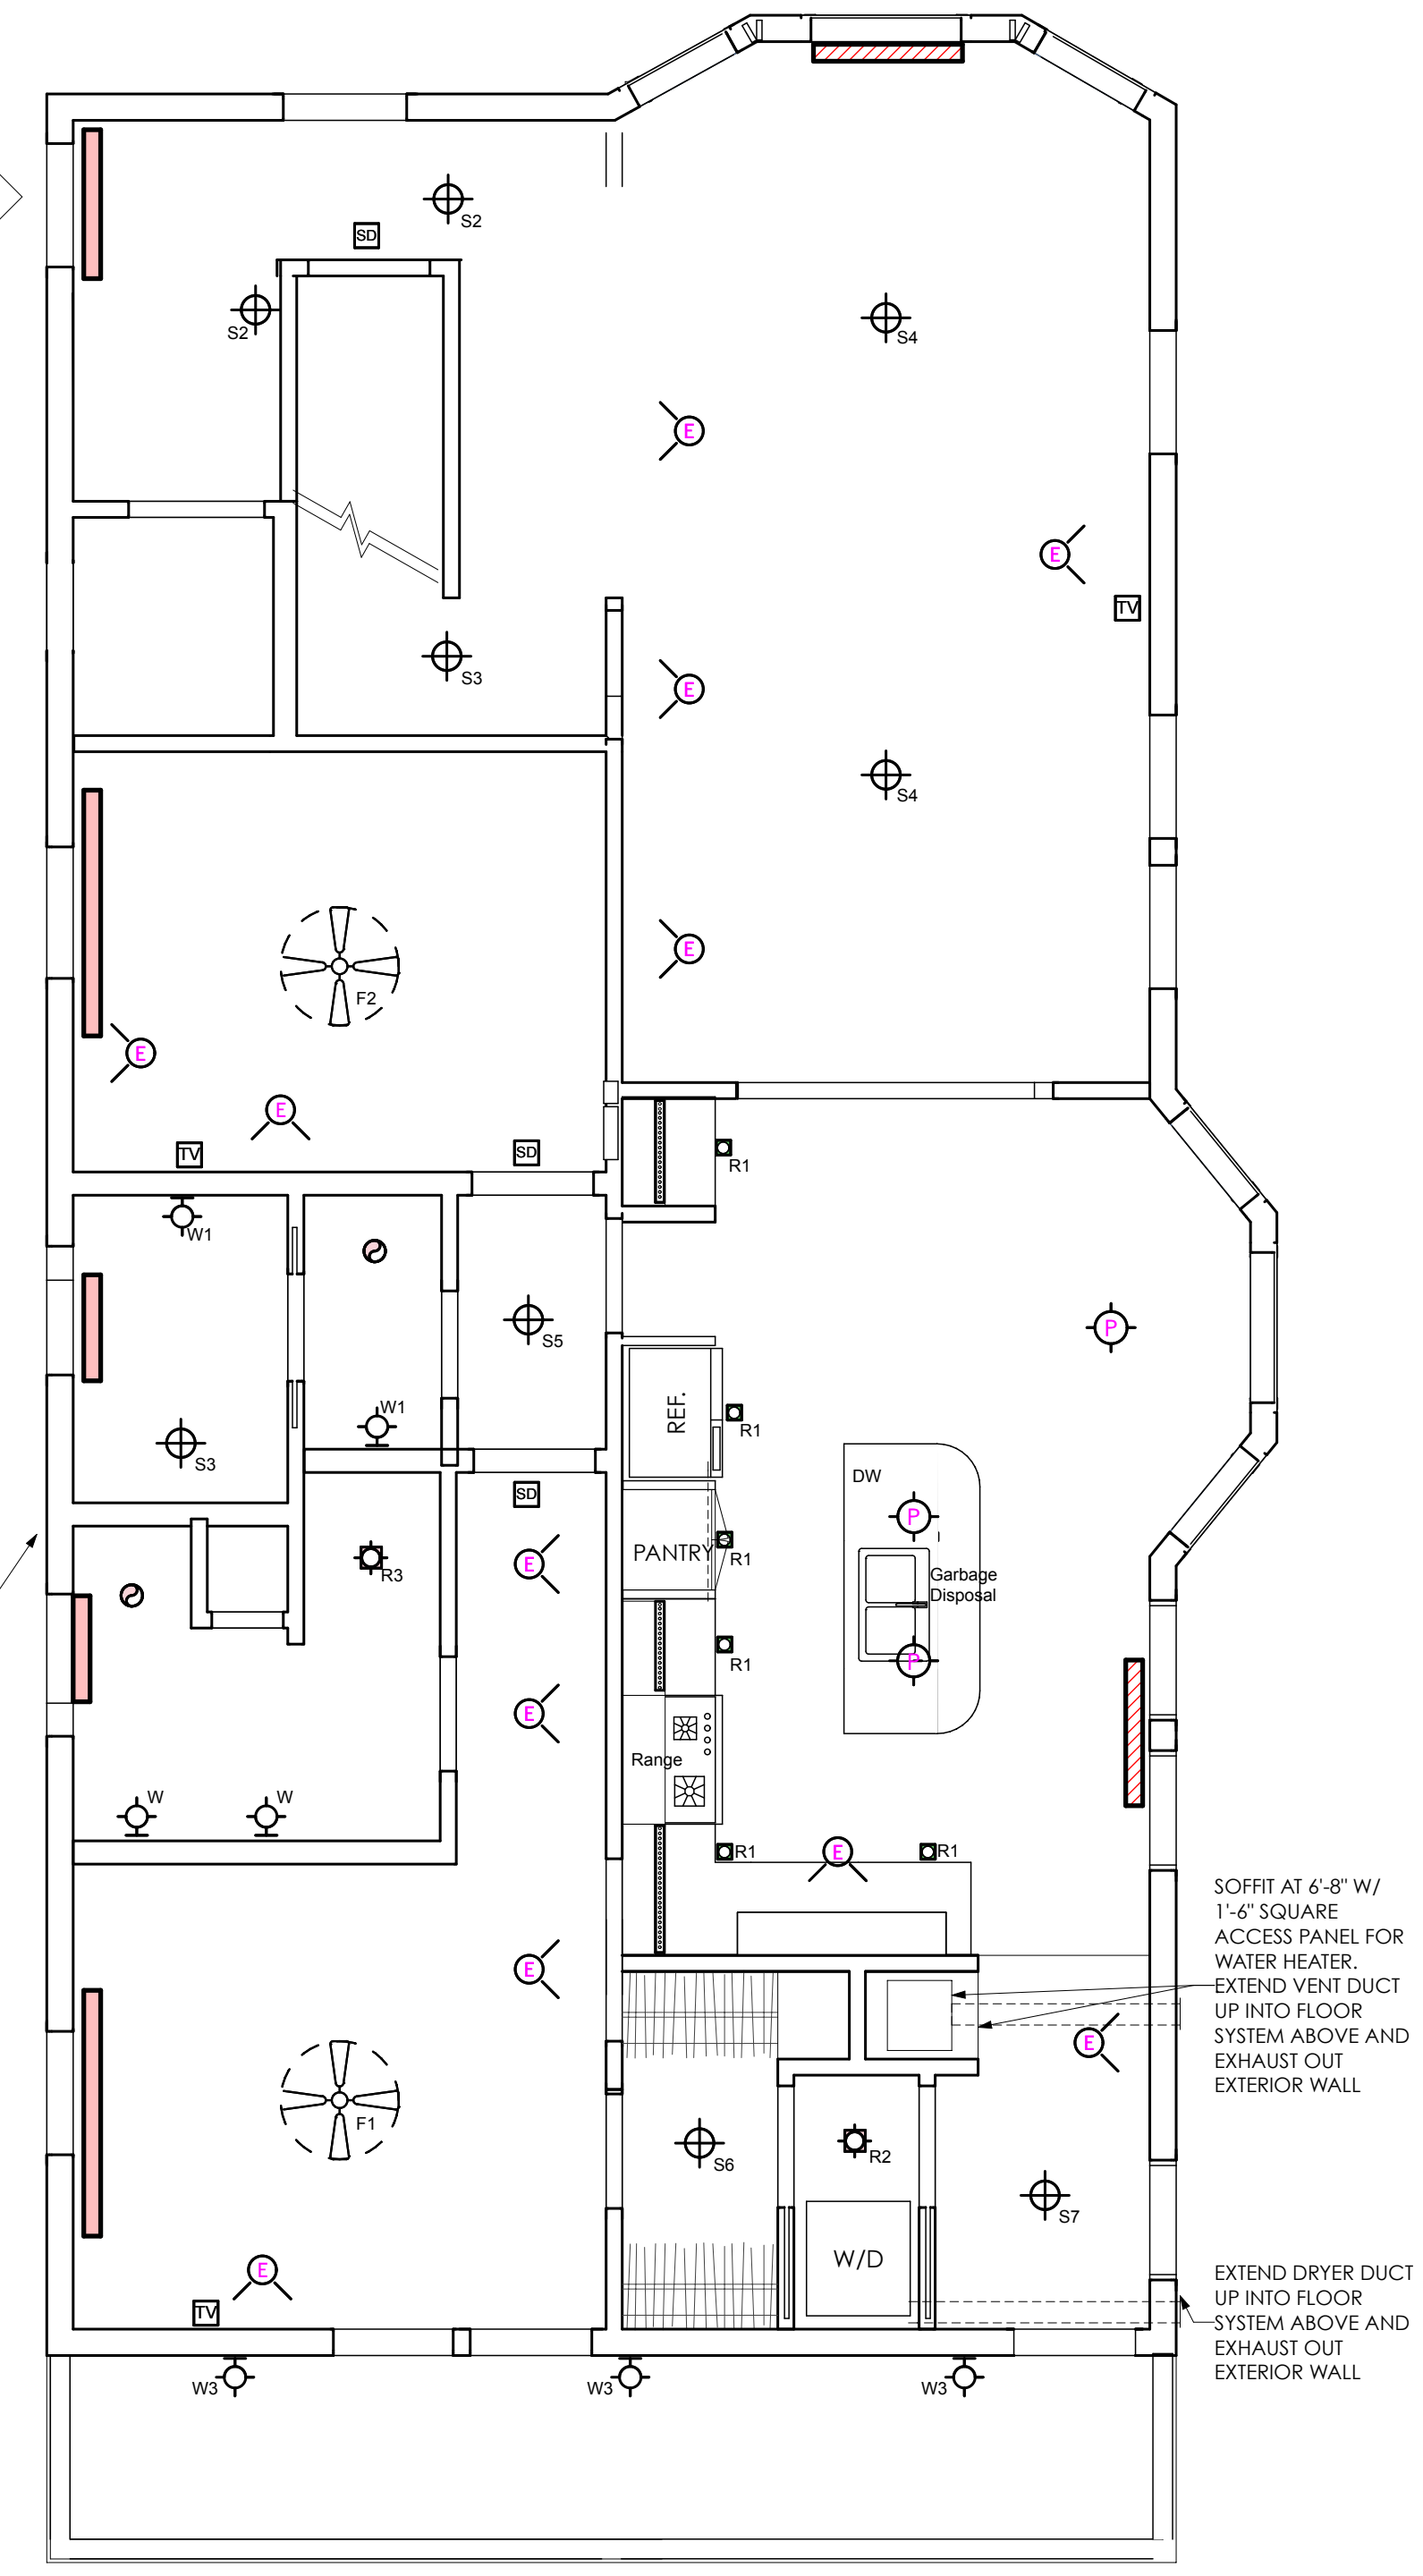

PERMIT SET

CALEB JOHNSON ARCHITECTS + BUILDERS
265 MAIN STREET SUITE 201 BIDDEFORD, ME 04005
T: 207.283.8777 F: 207.283.8778 CJAB.ME

GRISANTI - MUNJOY ST
SUSAN GRISANTI
60 MUNJOY ST PORTLAND, ME 04101

ELECTRICAL REFLECTED CEILING PLAN A-1.8

ISSUE NUMBER	DATE	DESCRIPTION
1	7/23/17	PRELIMINARY DESIGN

CONSULTANTS:
#STRUCTURAL ENGINEER: [REDACTED]
#CONSULTING ENGINEER: [REDACTED]
#77 OAK STREET PORTLAND, ME 04101
#AARON JONES

SUBMISSIONS:
ISSUE DATE
ISSUE DESCRIPTION

CHANGES THIS ISSUE:

ID	DESCRIPTION

STUDIO MANAGER:
PROJECT ARCHITECT: