


2 ELECTRICAL ROOF PLAN
SCALE: 1/4" = 1'-0"

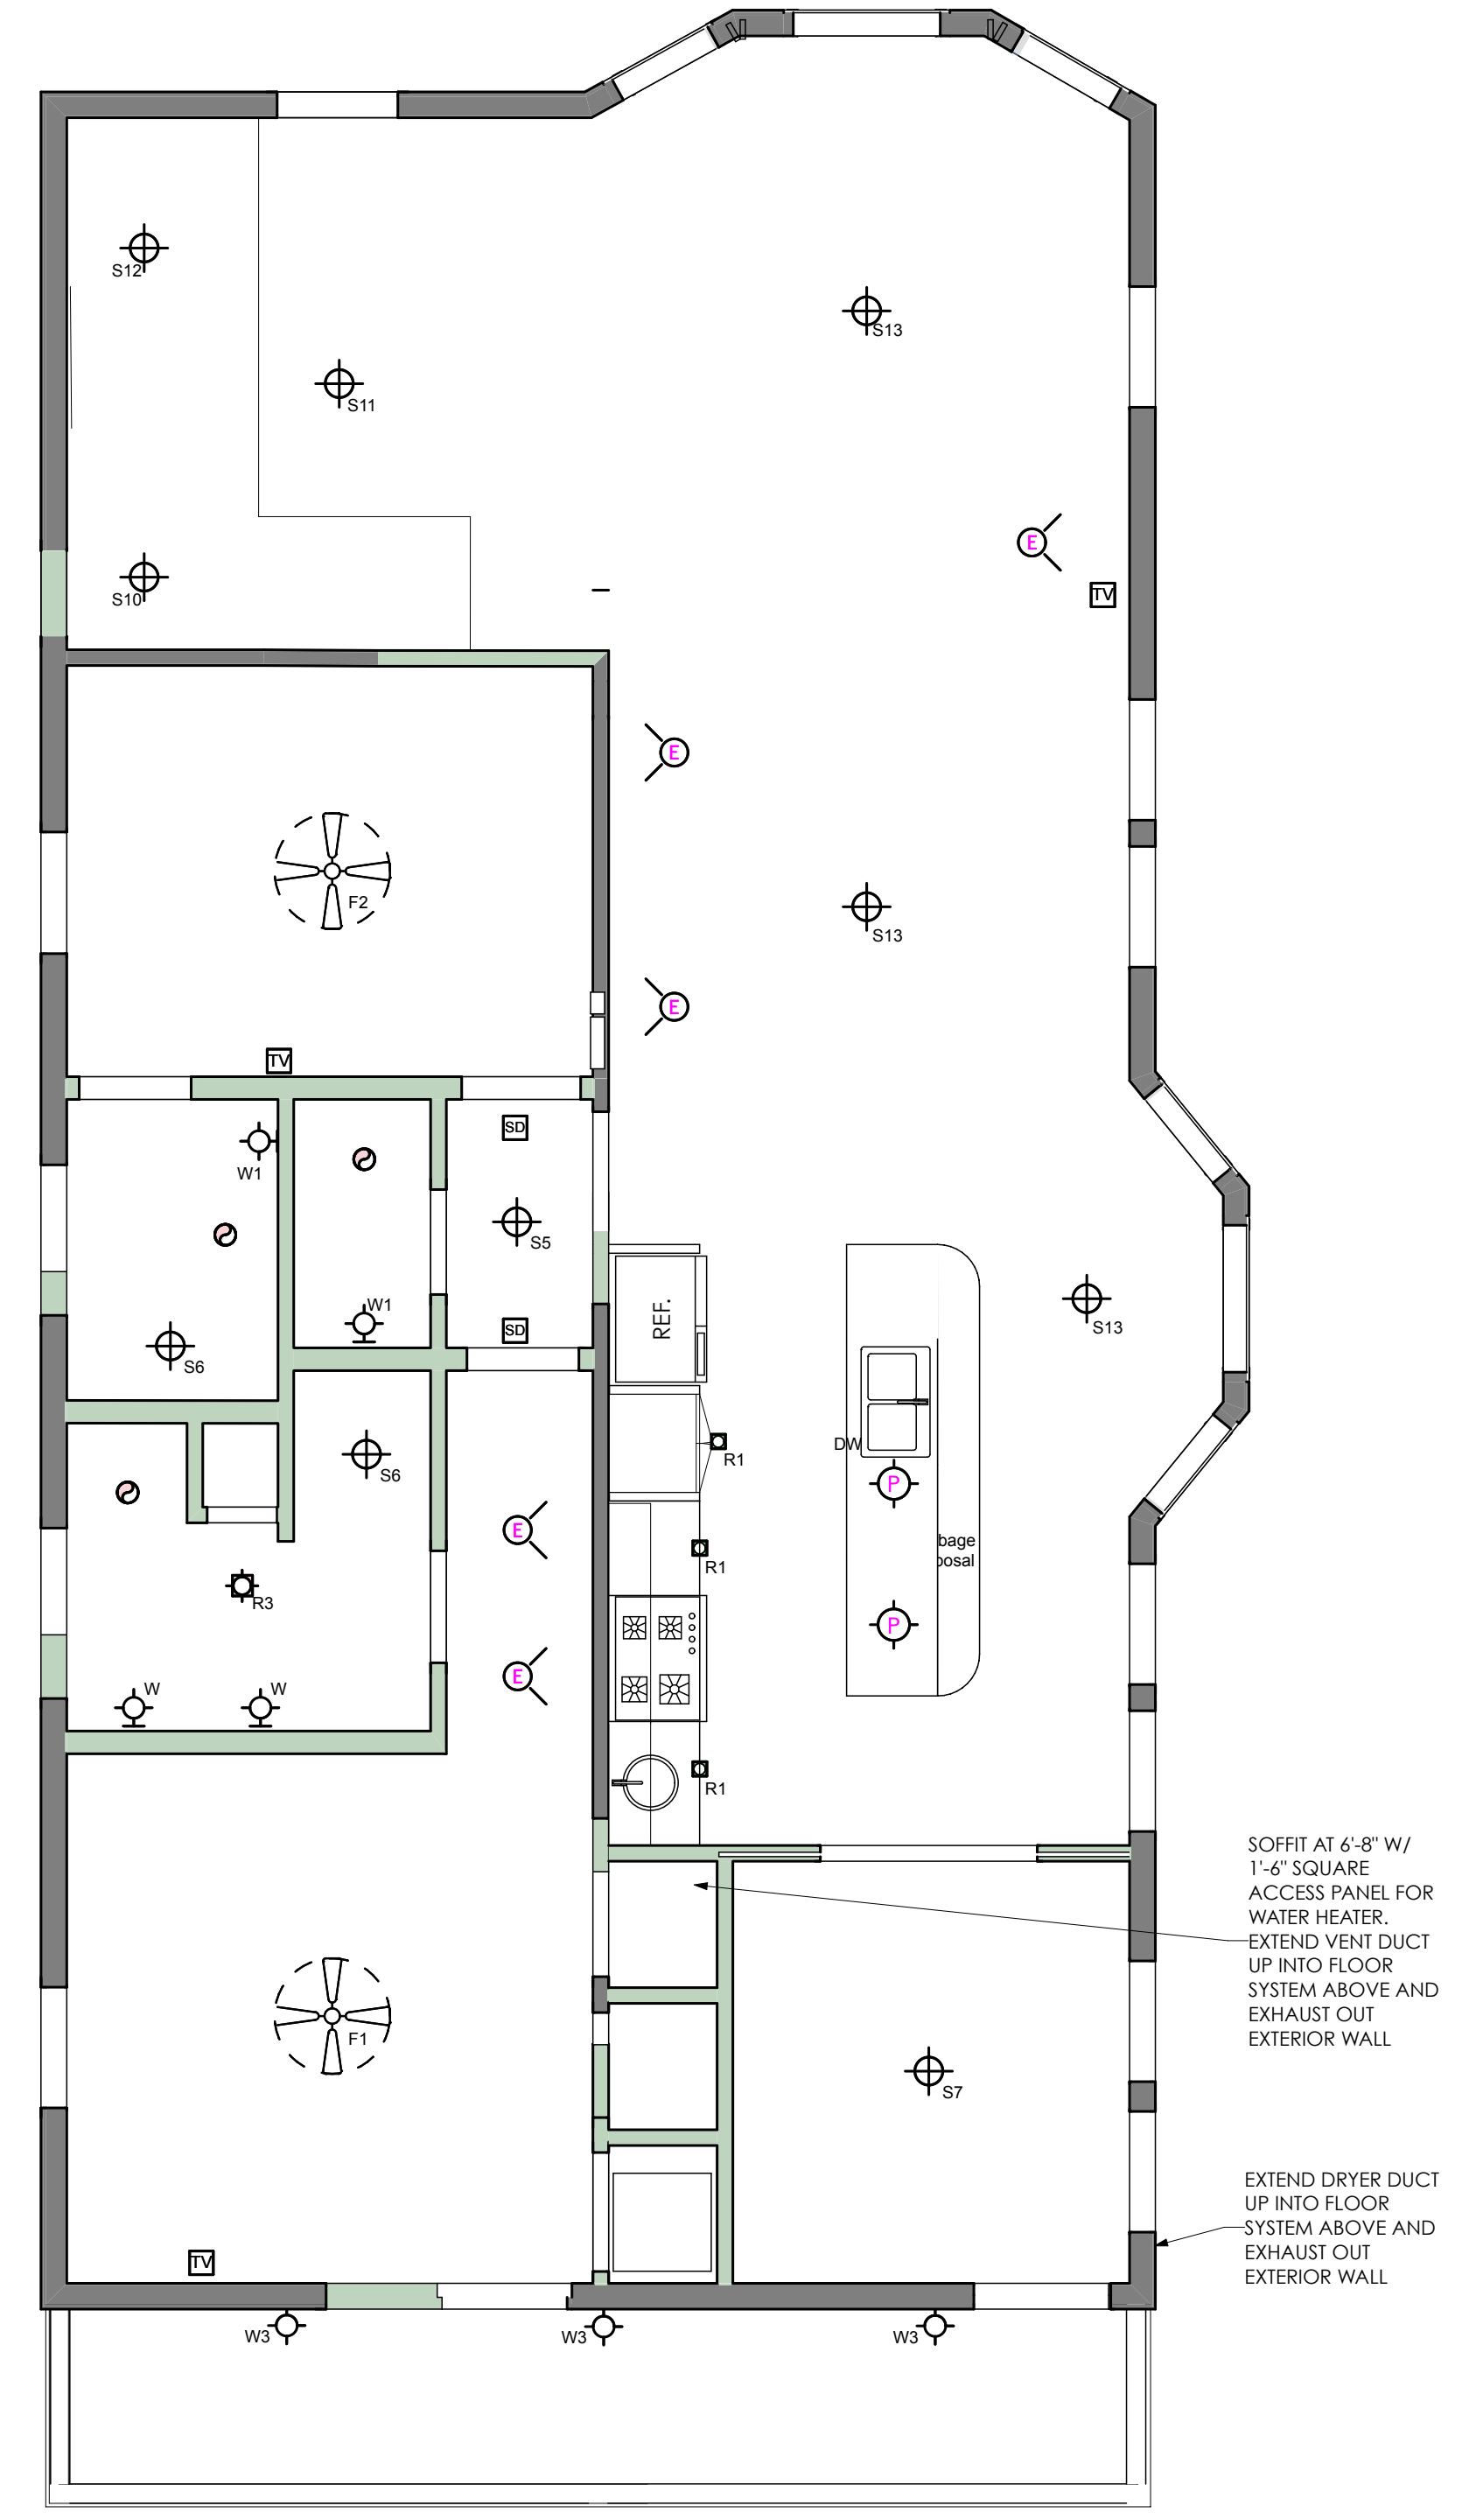

1 ELECTRICAL 3RD FLOOR PLAN
SCALE: 1/4" = 1'-0"

REVISED PERMIT SET 9/8/17

GRISANTI - MUNJOY ST
SUSAN GRISANTI
60 MUNJOY ST PORTLAND, ME 04101

DRAFTER:
Michael Christoff
DATE: 9/8/17
PROJECT STATUS:
PRELIMINARY DESIGN

CONSULTANTS:
#Structural Engineering
#Mechanical Engineering
#Portland, Maine
#Aron Jones

SUBMISSIONS:

ISSUE	DATE	DESCRIPTION
01	9/8/17	Revised Permit Set

CHANGES THIS ISSUE:

ID	DESCRIPTION

STUDIO MANAGER:
PROJECT ARCHITECT:

