


RESERVED FOR CITY STAMP

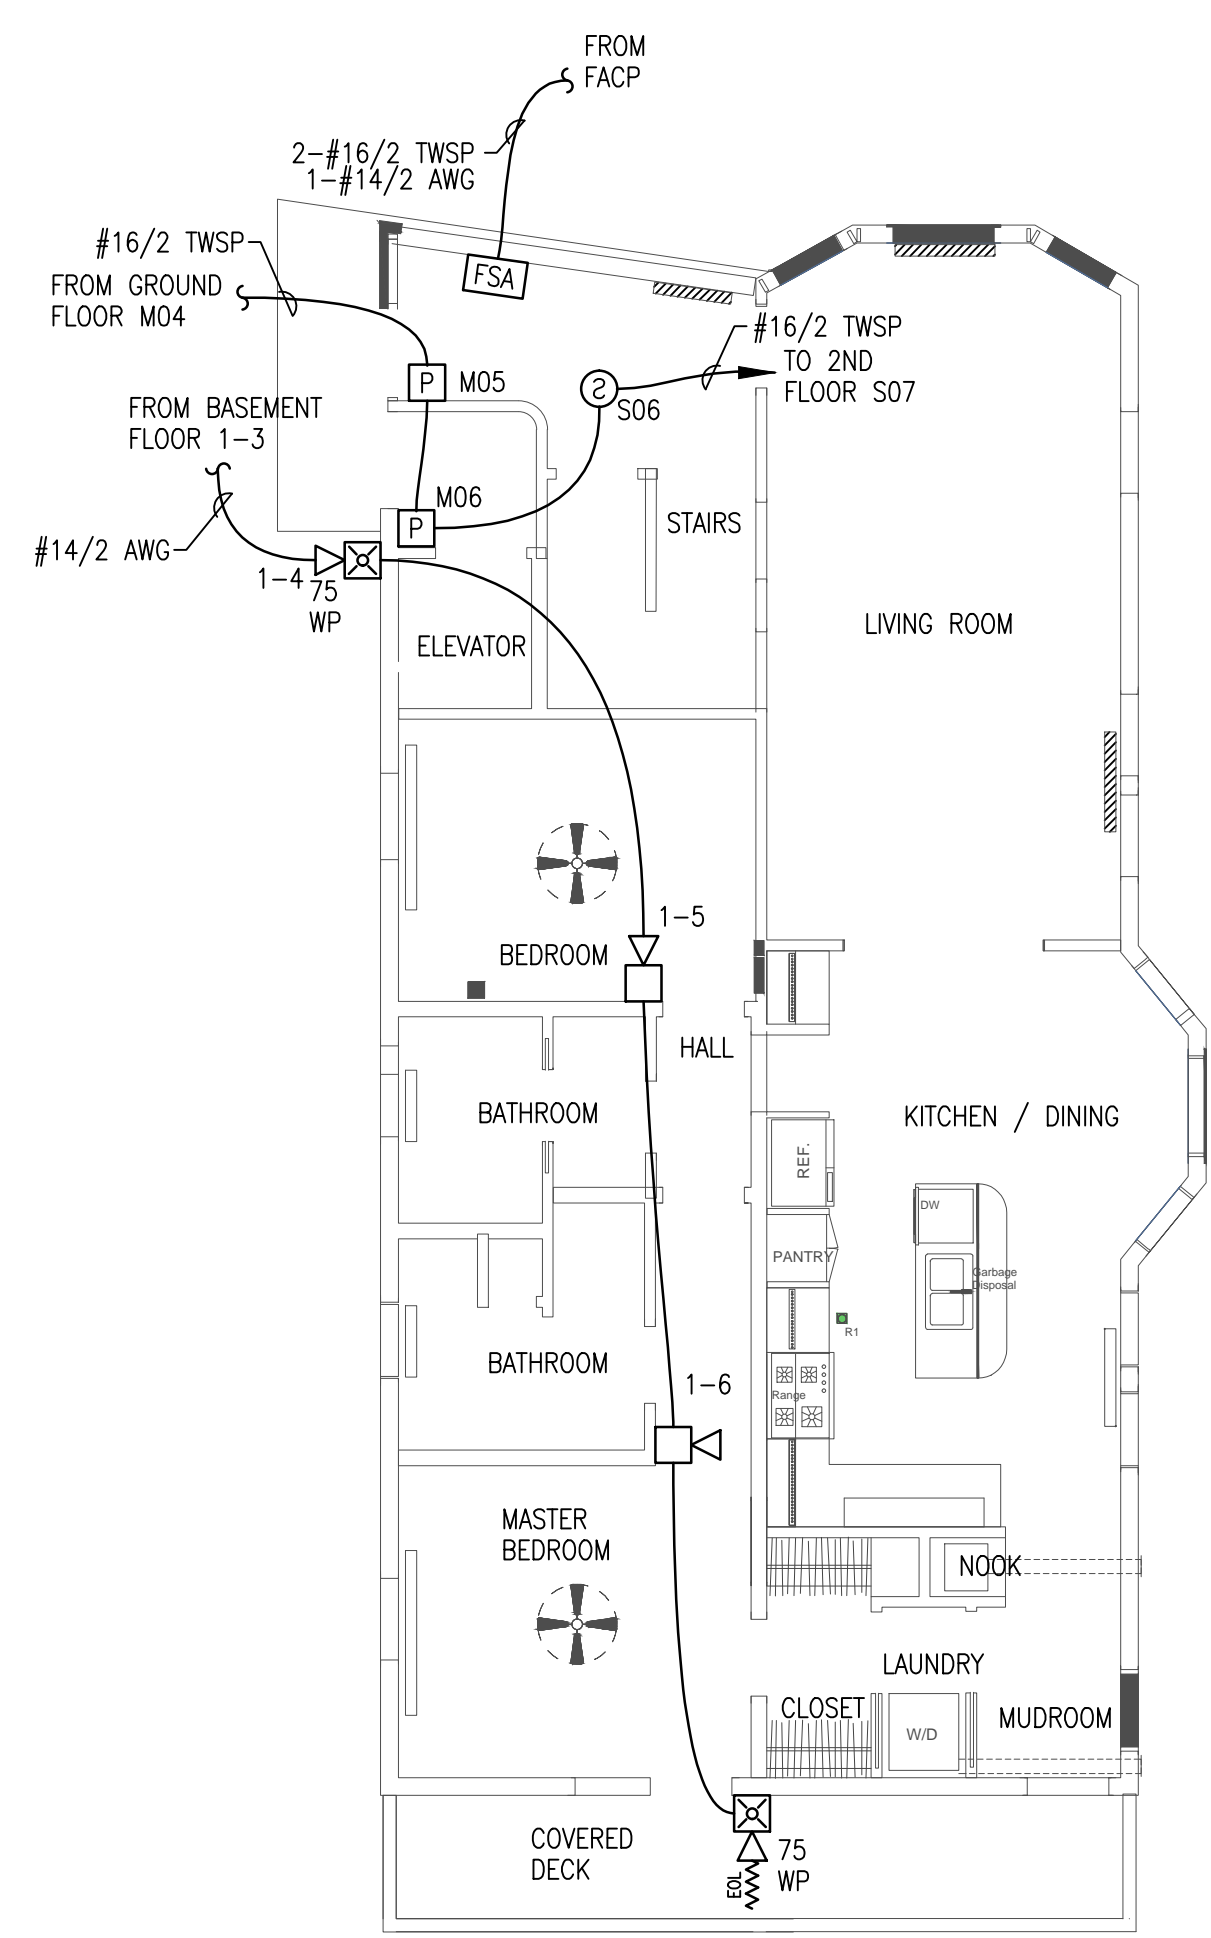

GROUND FLOOR
FIRE ALARM PLAN
SCALE: 1/8"=1'-0"

REVISION	DESCRIPTION	DATE
0	ISSUED FOR REVIEW & APPROVAL	7/25/2017

CUNNINGHAM
Security Systems
 10 Princes Point Road, Yarmouth, Maine 04096
 Office: 207.846.3350 • Fax: 207.846.6080

60 MUNJOY HILL
PORTLAND, ME 04101
GROUND FLOOR FIRE ALARM PLAN

DRAWN	CWS UNICAD JOB #17471
CHECKED	BRADY B. HAWS NICET III 138751
DATE	7/25/2017
REVISION	0
SCALE	1/8"=1'-0"

Shop drawings created by
 5794 W. 4900 St.
 Hager, UT 84313
 Office: 801.985.0410
UNICAD Inc.
 Fire Alarm Design & Drafting Services

FA-2