


RESERVED FOR CITY STAMP

REVISION	DESCRIPTION	DATE
0	ISSUED FOR REVIEW & APPROVAL	7/25/2017

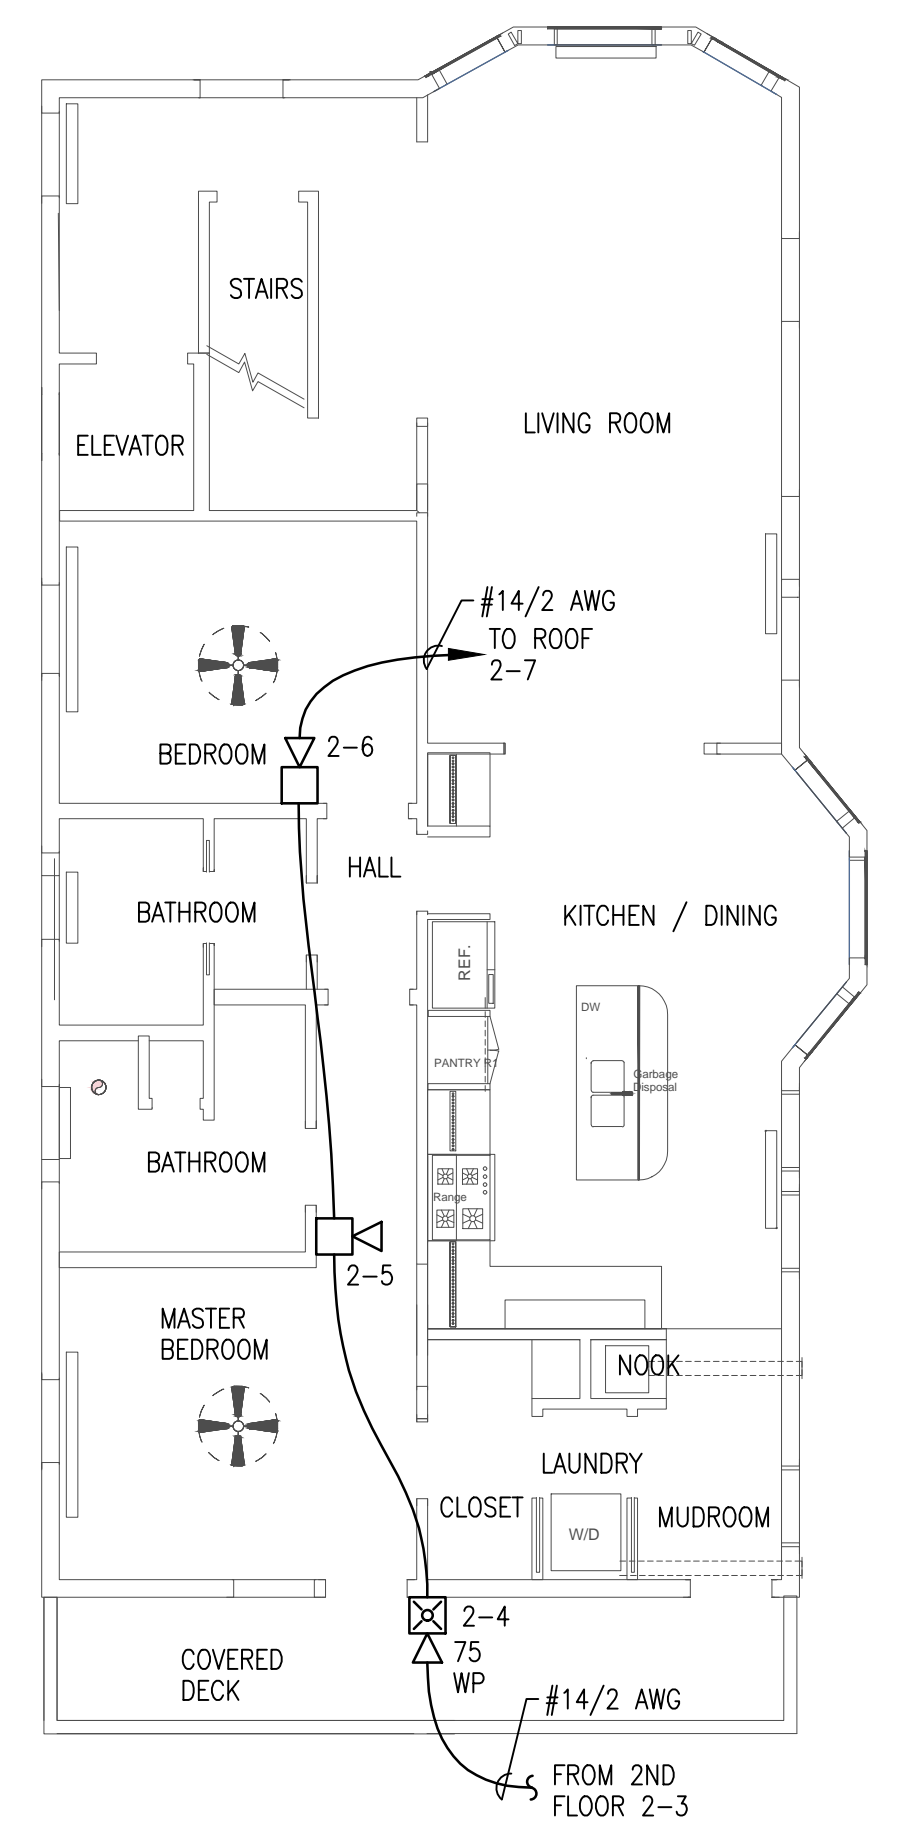

**3RD FLOOR
FIRE ALARM PLAN**
SCALE: 1/8"=1'-0"
0 4' 8' 16'

CUNNINGHAM
Security Systems
10 Princes Point Road, Yarmouth, Maine 04096
Office: 207.846.3350 • Fax: 207.846.6080

60 MUNJOY HILL
PORTLAND, ME 04101
3RD FLOOR FIRE ALARM PLAN

DRAWN	CWS UNICAD JOB #17471
CHECKED	BRADY B. HAWS NICET III 138751
DATE	7/25/2017
REVISION	0
SCALE	1/8"=1'-0"

shop drawings
created by
5794 W. 4900 So.
Hwy 97, UT 84315
Office: 801.955.0410
UNICAD Inc.
Fire Alarm Design & Drafting Services
www.unicad.net

FA-4