


RESERVED FOR CITY STAMP

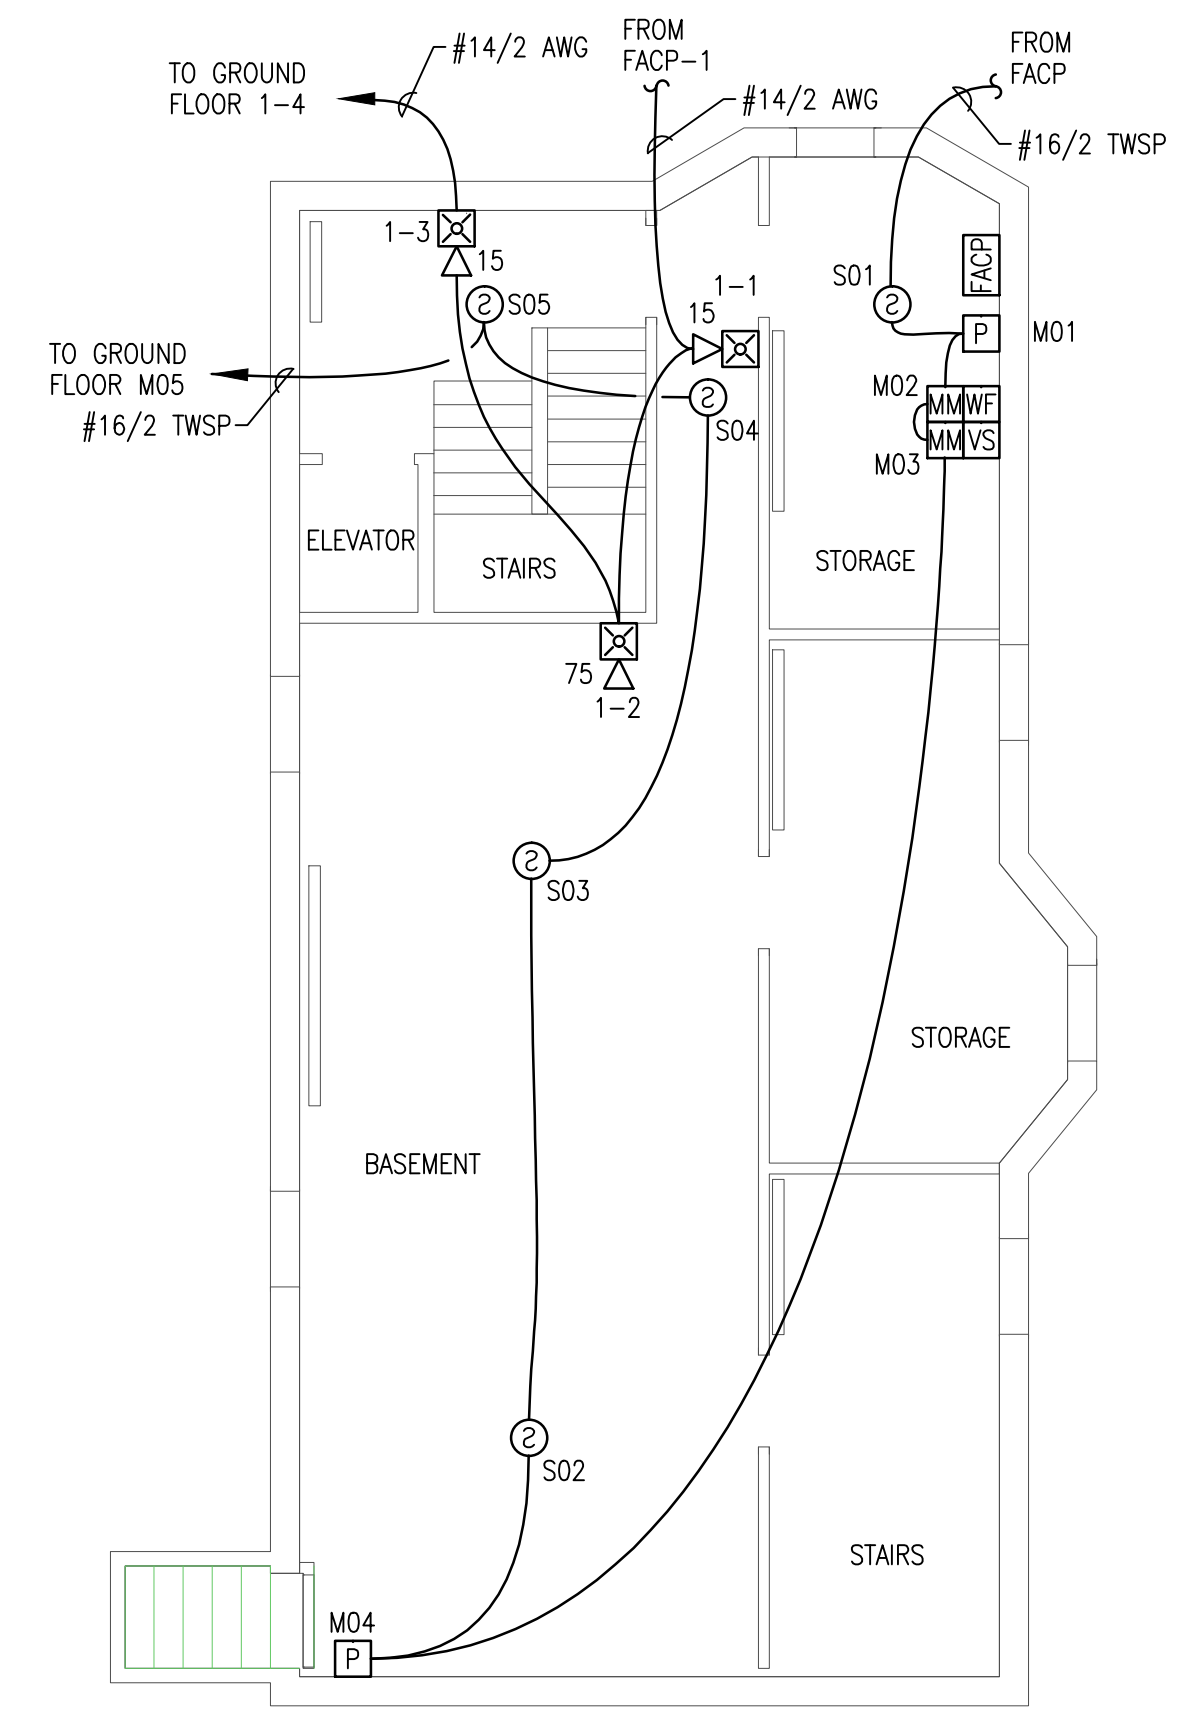

**BASEMENT FLOOR
FIRE ALARM PLAN**
SCALE: 1/8"=1'-0"

| REVISION | DESCRIPTION | DATE |
|----------|------------------------------|-----------|
| 0 | ISSUED FOR REVIEW & APPROVAL | 7/25/2017 |
| | | |
| | | |
| | | |

CUNNINGHAM
Security Systems
10 Princes Point Road, Yarmouth, Maine 04096
Office: 207.846.3350 • Fax: 207.846.6080

60 MUNJOY HILL
PORTLAND, ME 04101
BASEMENT FLOOR FIRE ALARM PLAN

| | |
|----------|-----------------------------------|
| DRAWN | CWS UNICAD JOB #17471 |
| CHECKED | BRADY B. HAWS NICET III 138751 |
| DATE | 7/25/2017 |
| REVISION | 0 |
| SCALE | 1/8"=1'-0" |

shop drawings
created by
5794 W. 4900 So.
Hesper, UT 84313
Office: 801.955.0410
www.unicad.net

UNICAD Inc.
Fire Alarm Design & Drafting Services

FA-1