



BASEMENT FIRE PROTECTION

SCALE 1/4"=1'-0"
 QUANTITY ○ = 14
 QUANTITY △ = 1

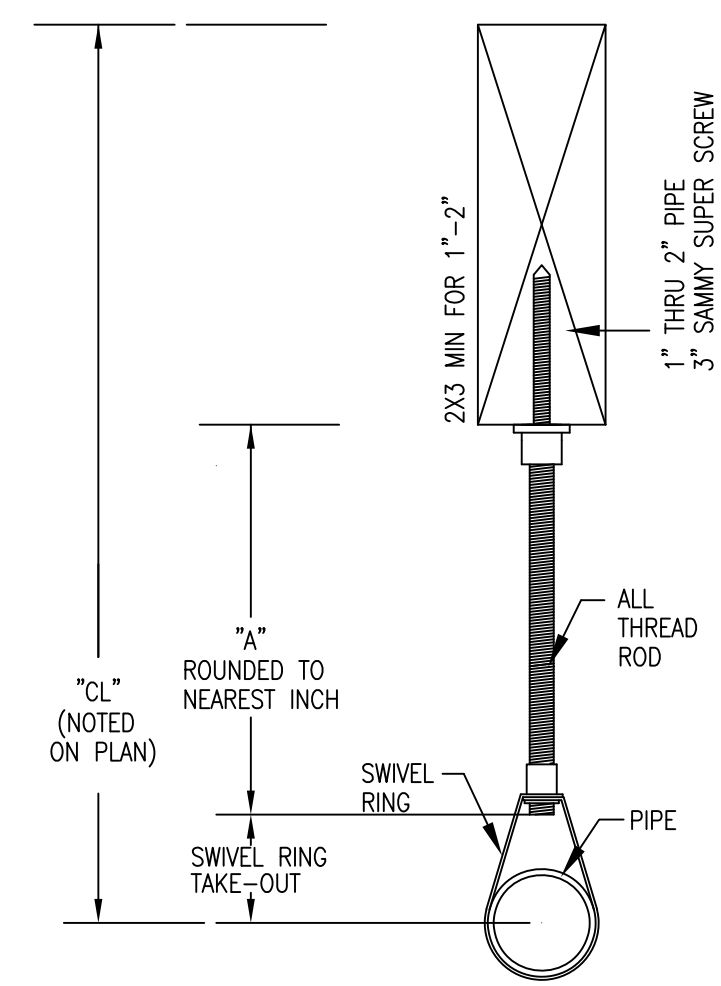

TYPE 'P' HANGER
 NO SCALE

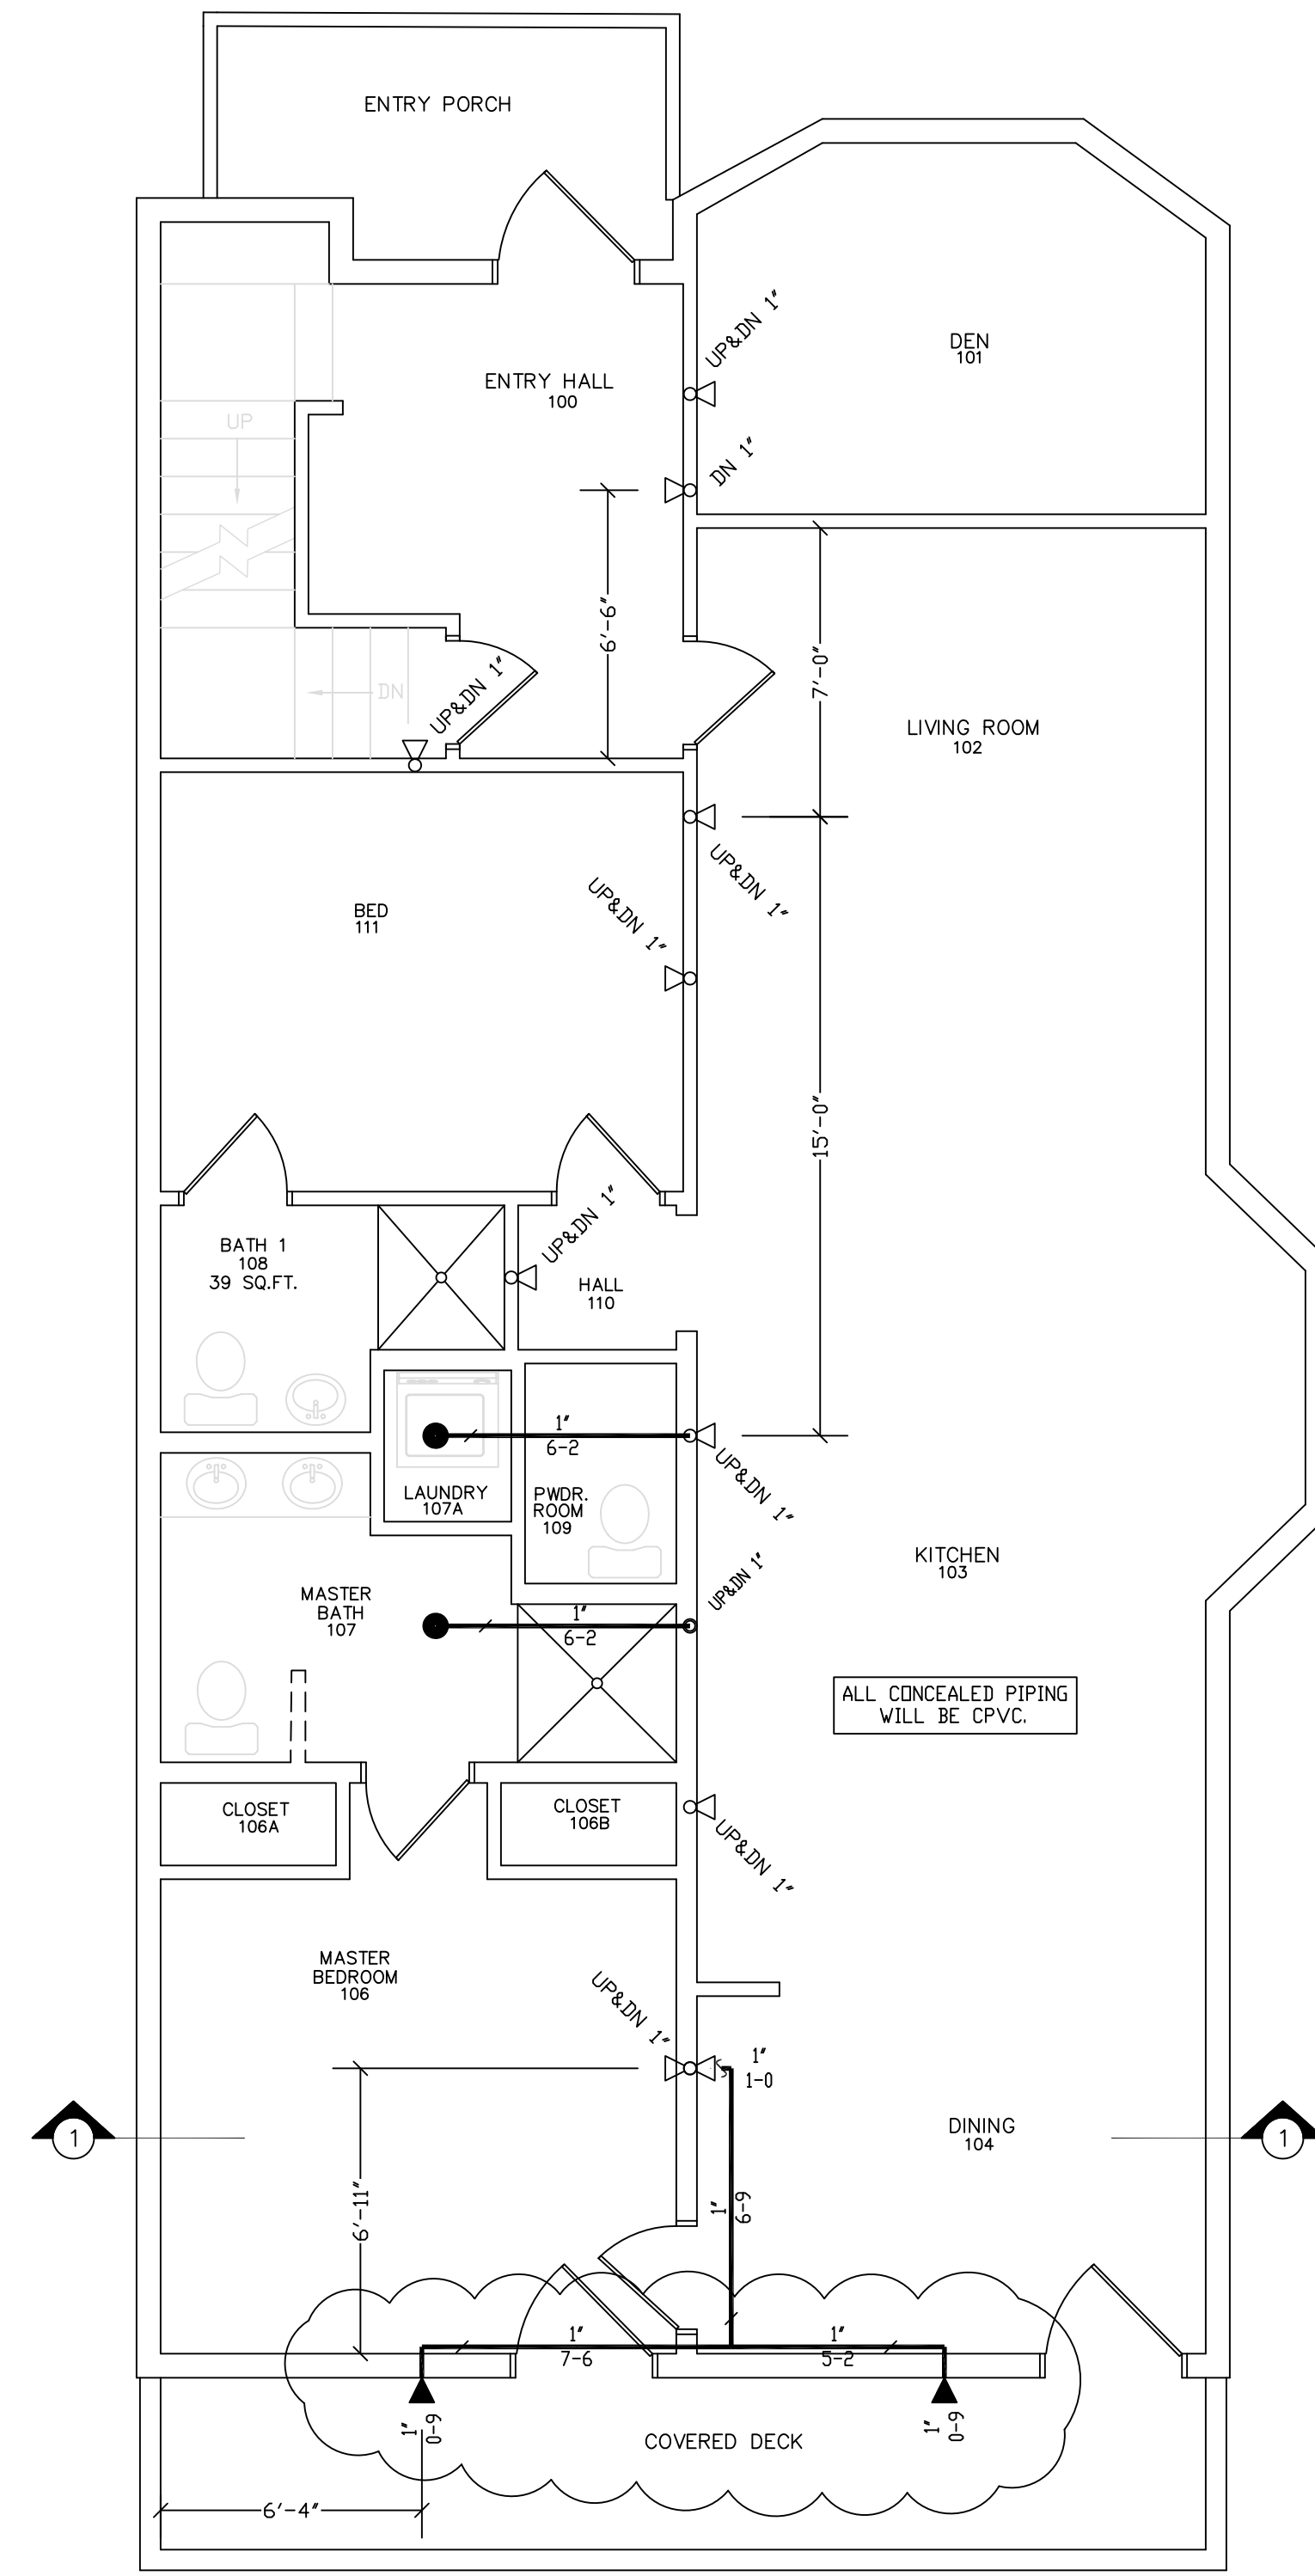

GROUND FLOOR FIRE PROTECTION

SCALE 1/4"=1'-0"
 QUANTITY ● = 2
 QUANTITY ○ = 10
 QUANTITY ▲ = 2

REVISIONS	NOTES	SPRINKLER TYPE	IDENTIFICATION NO.	MFG.	ESC.	MODEL	FINISH	ORIFICE	TEMP.	SYMBOL	QUANT.
11/14/17 ADDED SPRINKLER COVERAGE TO COVERED DECK	K=4.9 PENDANT SPRINKLER COVERAGE: 16'X16' K=4.4 SIDEWALL SPRINKLER COVERAGE: 16'X16'	QUICK RESP. PENDANT K= 4.9	TY2524	TYCO	CONCEALED	LFII	WHITE	1/2"	155°	●	2
		QUICK RESP. PENDANT K= 4.9	TY2234	TYCO	N/A	LFII	BRASS	1/2"	155°	○	14
		QUICK RESP. SIDEWALL K= 4.4	TY2334	TYCO	2 PIECE	LFII	WHITE	1/2"	155°	○	11
		DR. DRY SIDEWALL K= 4.4	TY2335	TYCO	2 PIECE	LFII	DRY	1/2"	155°	▲	2
TOTAL SPRINKLERS THIS DRAWING											29

STANDARD SYMBOLS	STANDARD SYMBOLS
<ul style="list-style-type: none"> POST INDICATOR VALVE KEY VALVE FIRE HYDRANT FIRE DEPT. CONNECTION O.S. & Y GATE VALVE SWING CHECK VALVE NEW UNDERGROUND EXIST UNDERGROUND 	<ul style="list-style-type: none"> ALARM CHECK VALVE RISER W/ALARM VALVE RISER W/DRY VALVE RISER W/ELEC. FLOW SWITCH RISER W/DELUGE VALVE WATER MOTOR BELL ELECTRIC BELL FLUSH FIRE DEPT. CONNECTION

INSPECTIONS
1.
2.
3.
4.
5.
RESPONSIBLE MANAGING SUPERVISOR #348
CONTRACTOR LICENSE #295

GRISANTI CONDOMINIUMS
 60 MUNJOY STREET
 PORTLAND, MAINE 04101

FIRE PROTECTION PLAN

FREEDOM FIRE PROTECTION, INC.
 209 QUAKER RIDGE ROAD
 CASCO, MAINE 04015

JOB No. M0333
 DATE 10/17/17
 DRAWN BY MJN
 SCALE AS NOTED
 SHEET No. FP-2of3