



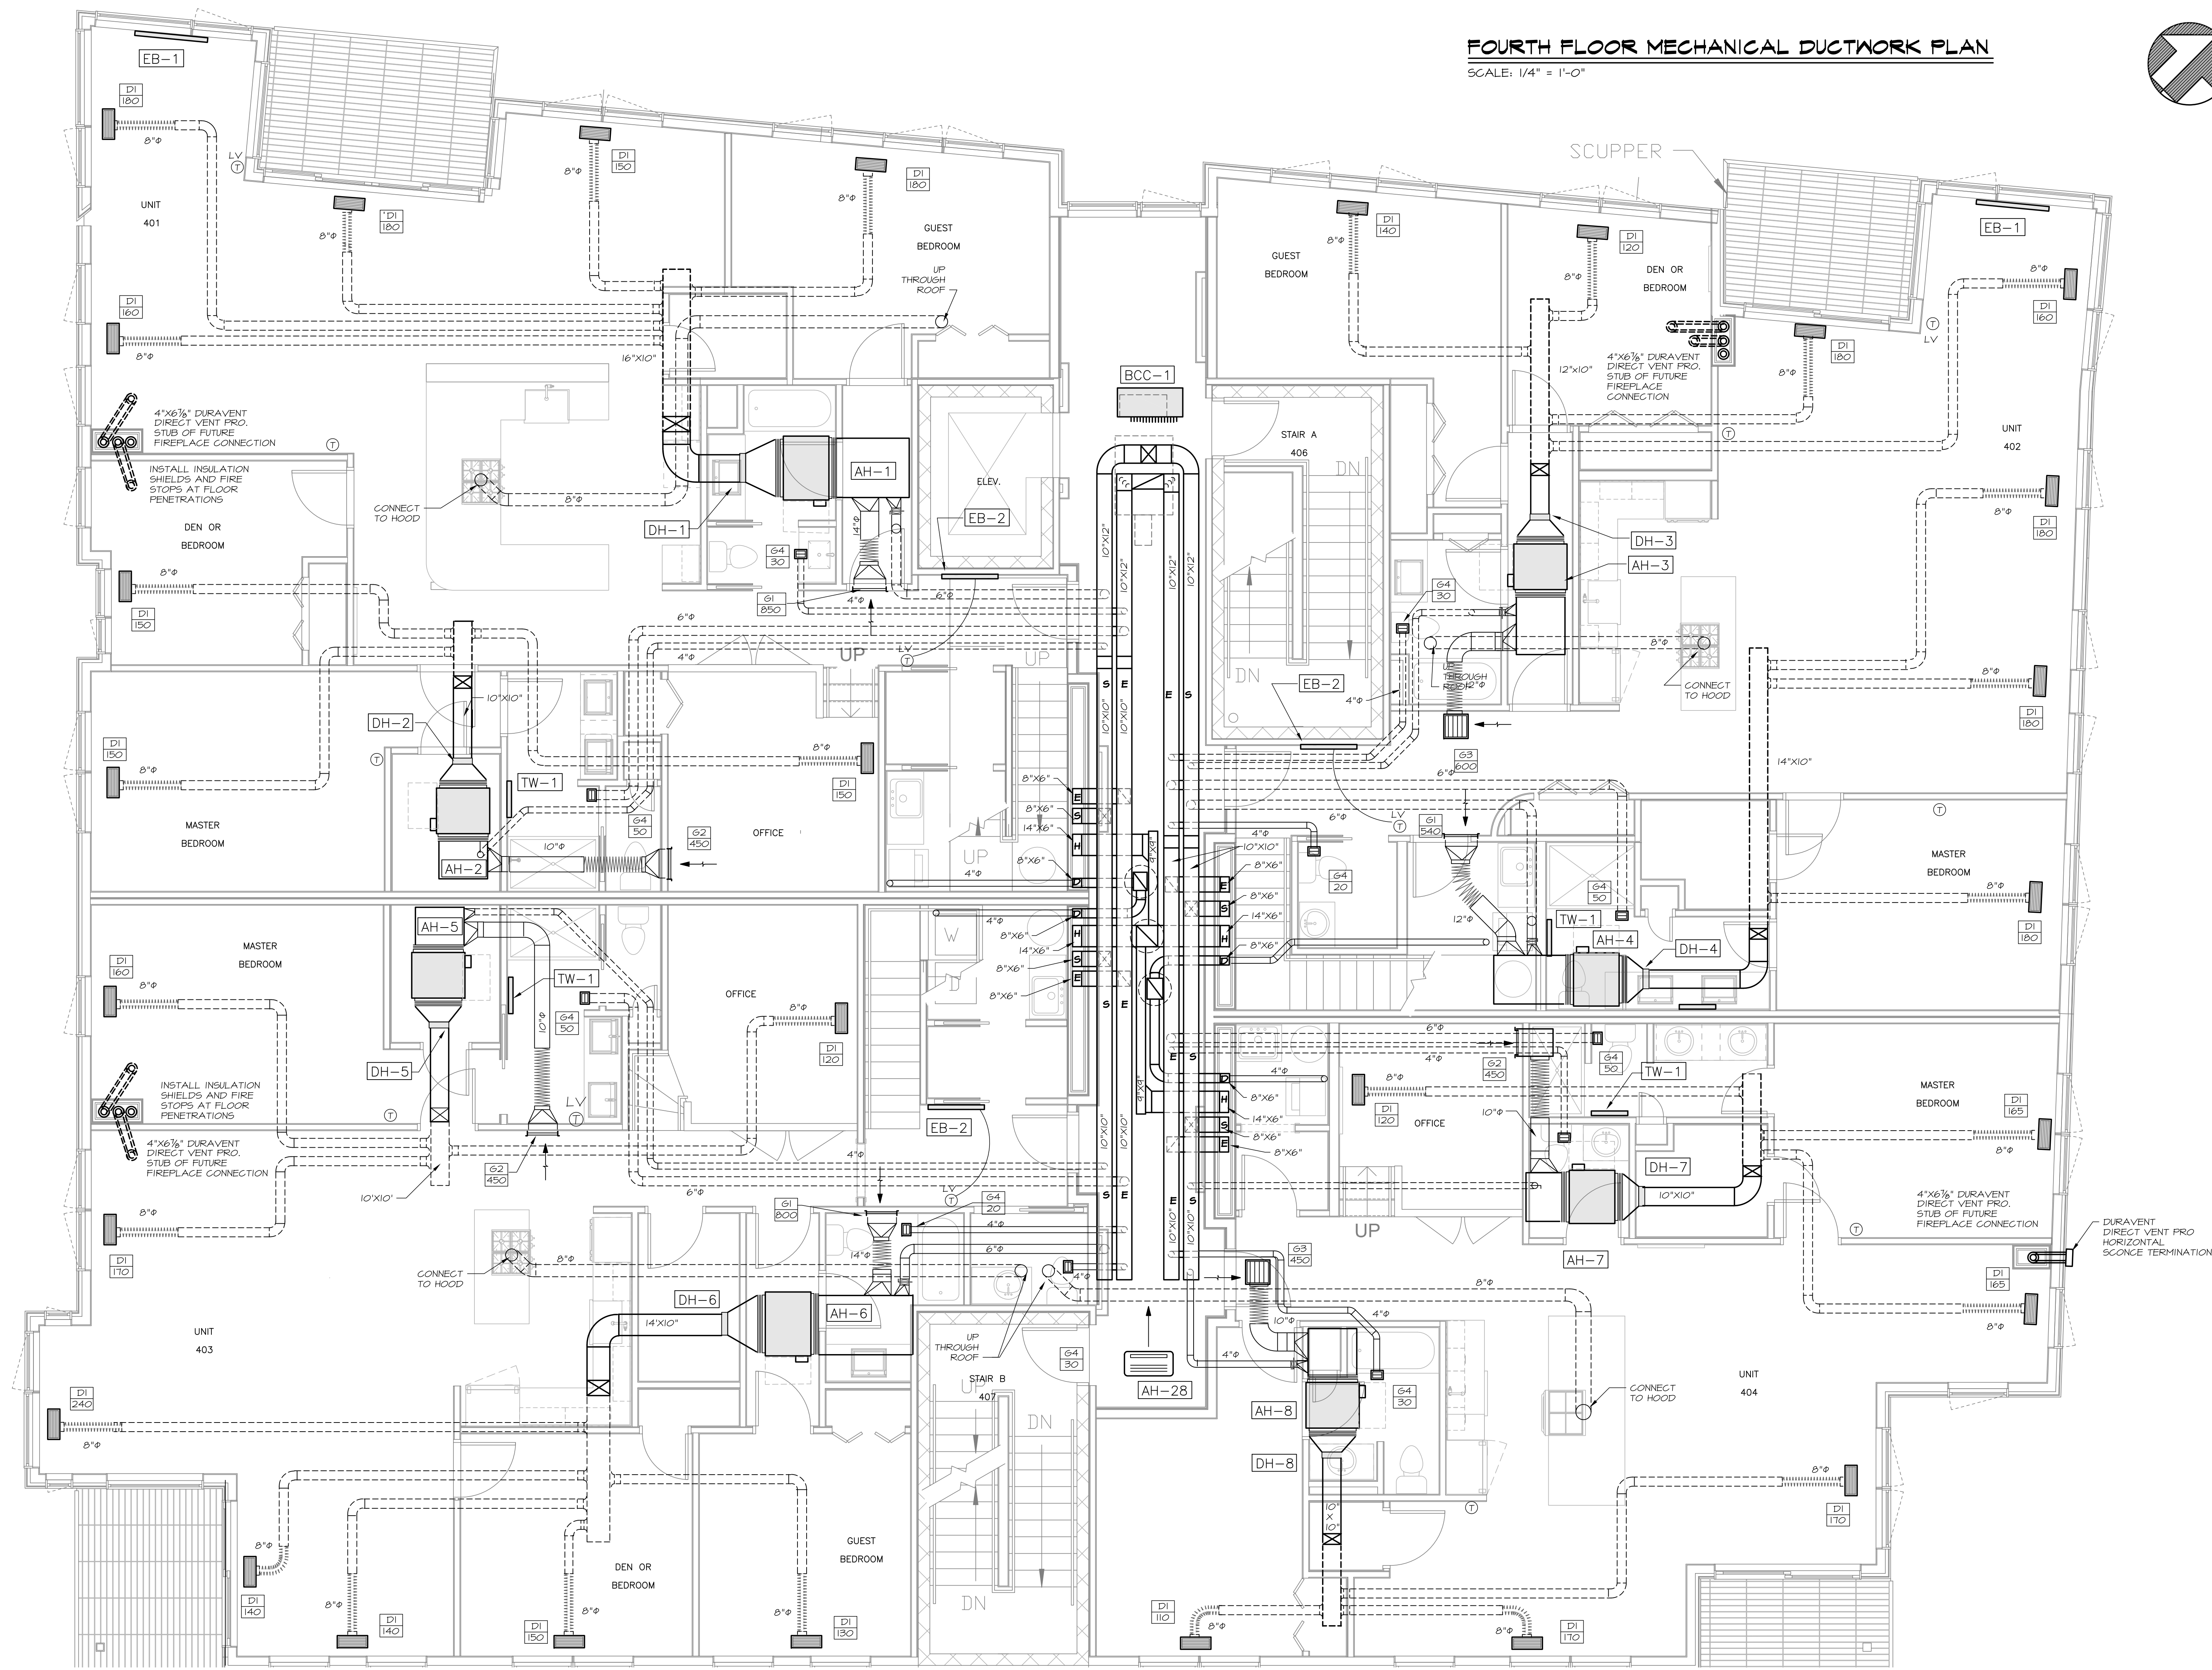

FOURTH FLOOR MECHANICAL DUCTWORK PLAN
SCALE: 1/4" = 1'-0"

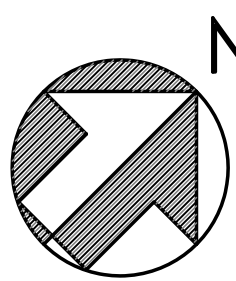

 STATE OF MAINE Kurt F. Magnusson 10257 LICENSED PROFESSIONAL ENGINEER	
Prepared For:	118 on Munjoy Hill, LLC 118 CONGRESS STREET PORTLAND, ME 04101
Consulting Engineer:	 MECHANICAL SYSTEMS ENGINEERS 10 FOREST FALLS DRIVE ROYAL NOVER CENTERS PORTLAND, ME 04101 (207) 772-4000 © COPYRIGHT 2014
Architect:	 ARCHETYPE architects 48 Union Wharf Portland, Maine 04101 (207) 772-6022 Fax (207) 772-4056
Project:	118 ON MUNJOY HILL 118 CONGRESS STREET PORTLAND, MAINE
Revisions:	100% CONSTRUCTION DOCUMENTS
Date:	24 FEB 2014
Scale:	1/4" = 1'-0"
FOURTH FLOOR DUCTWORK PLAN	
 M4 MSE PROJECT 1332	