



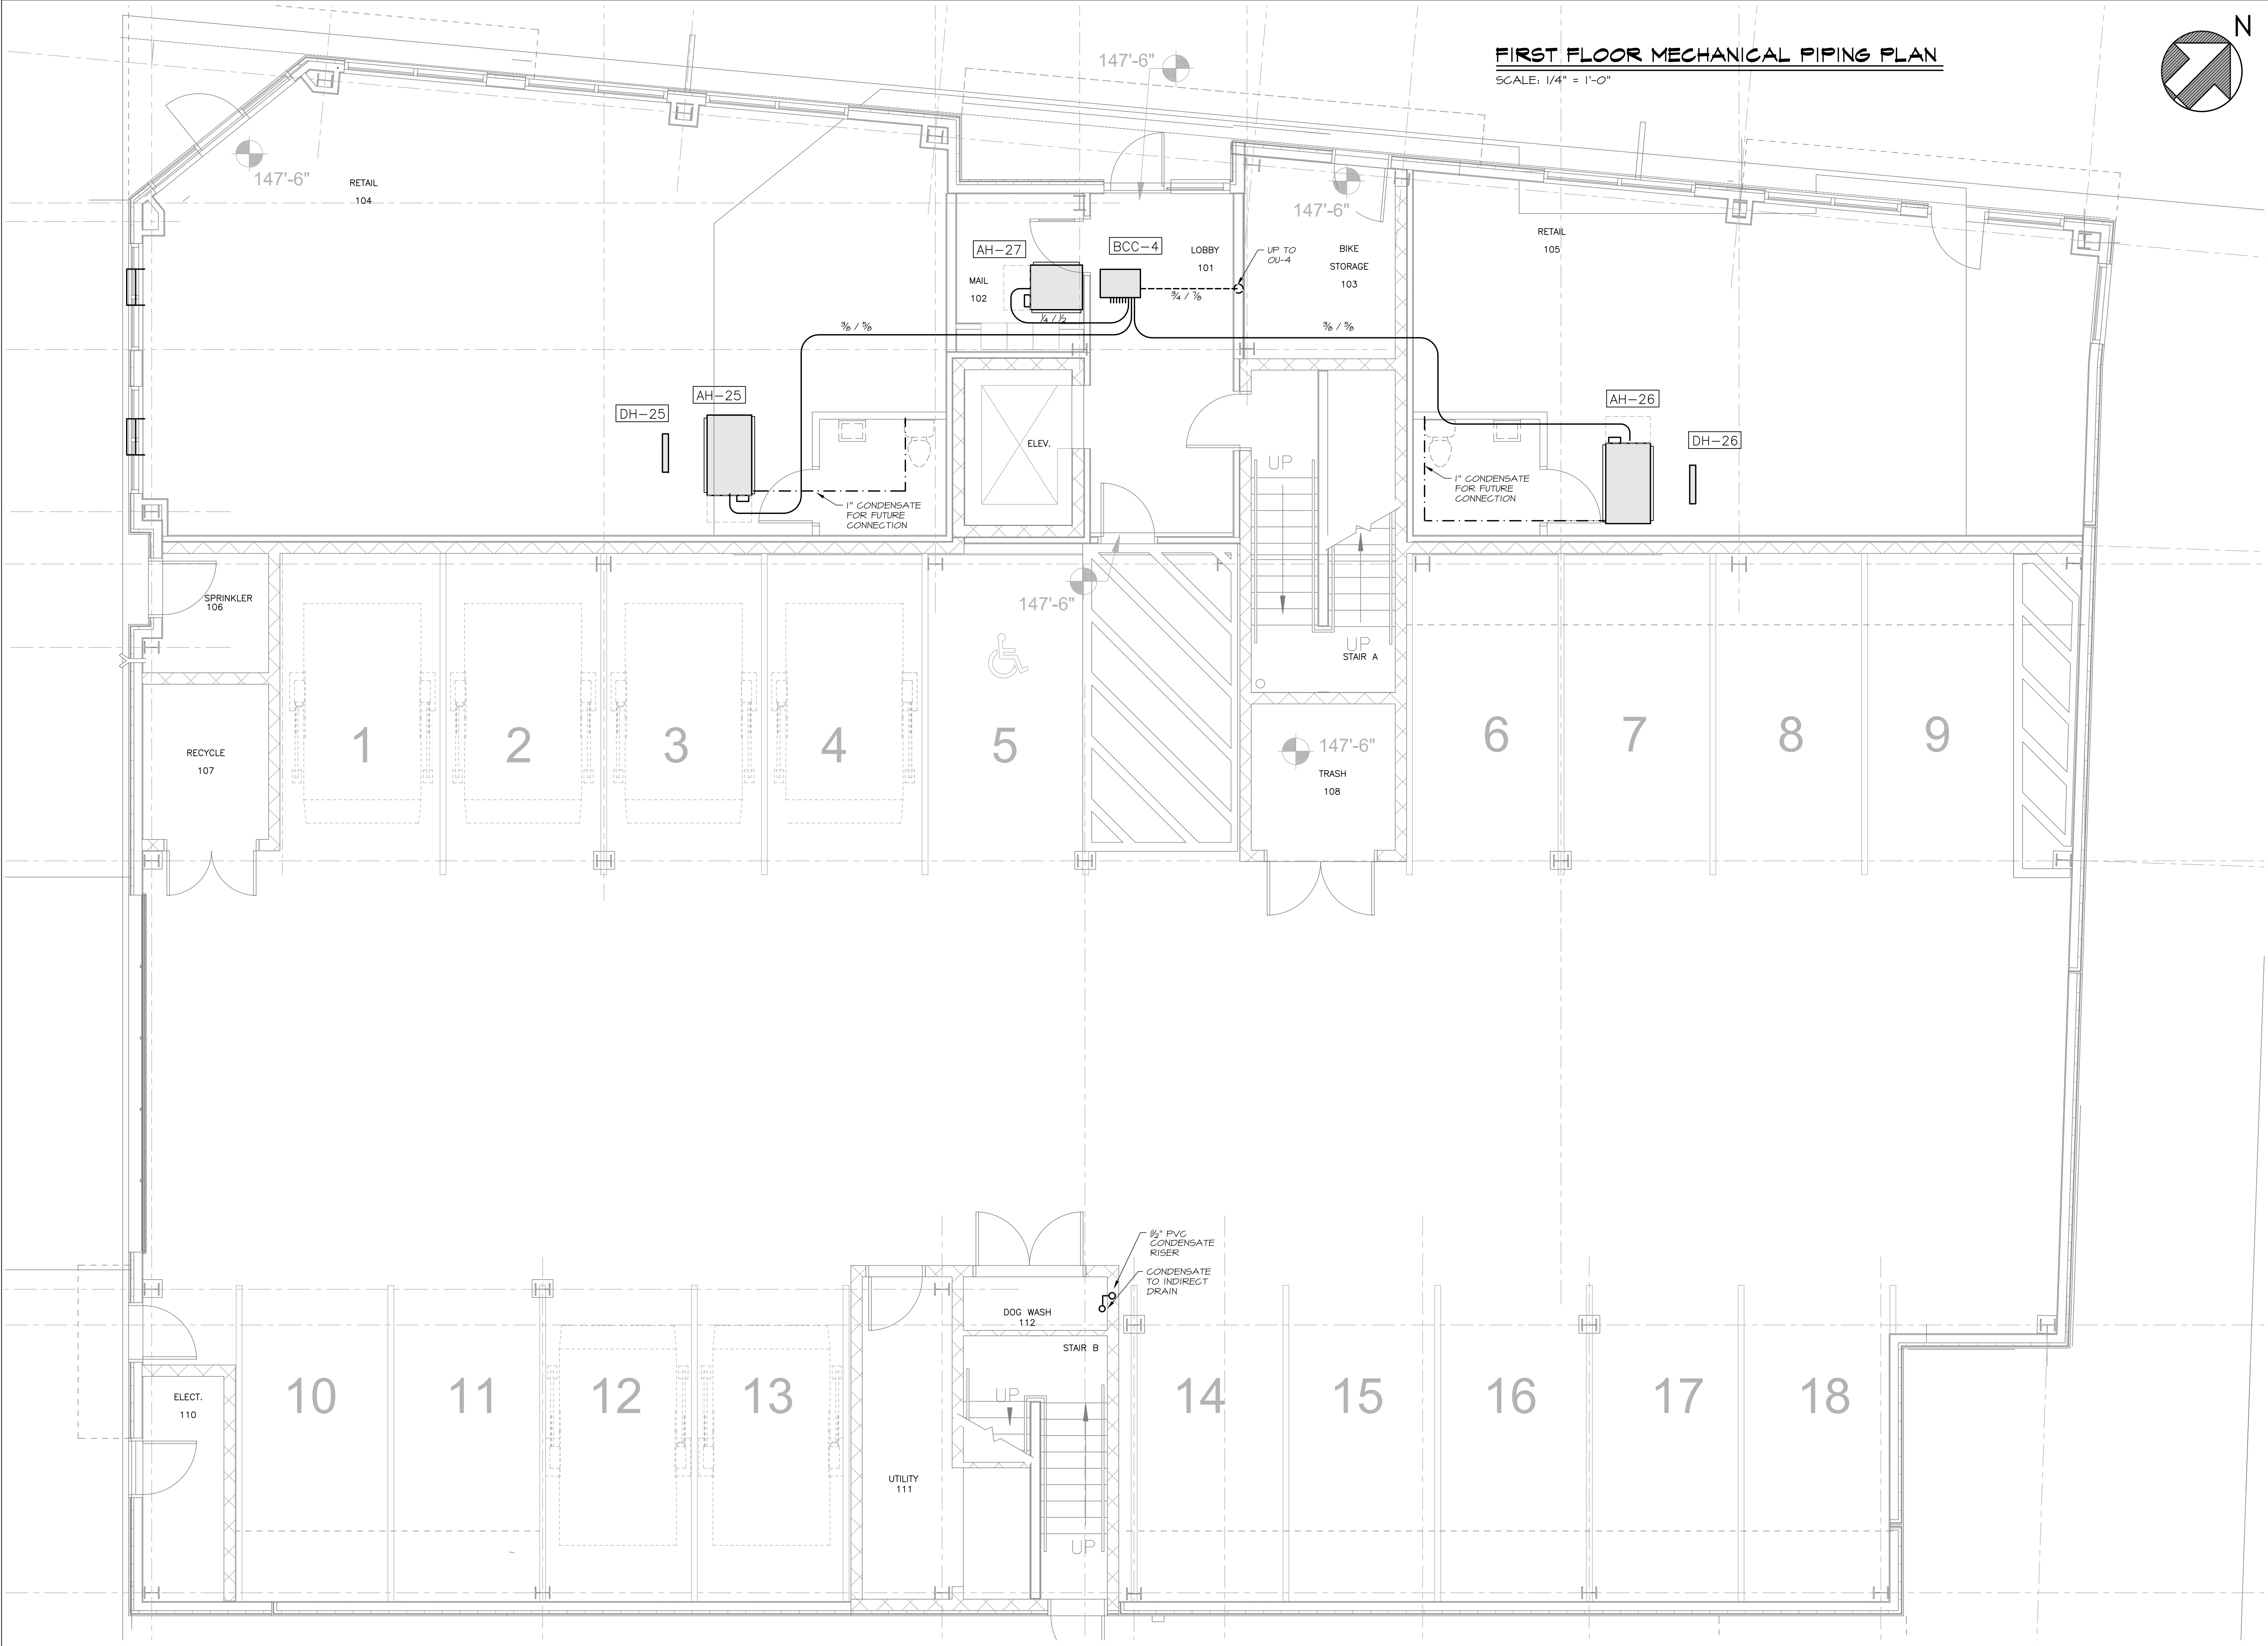

FIRST FLOOR MECHANICAL PIPING PLAN
SCALE: 1/4" = 1'-0"

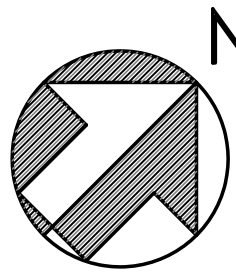

Prepared For:	118 on Munjoy Hill, LLC 118 CONGRESS STREET PORTLAND, ME 04101
Consulting Engineer:	 MECHANICAL SYSTEMS ENGINEERS, INC. 10 FOREST FALLS DRIVE ROYAL NOVER CENTER PORTLAND, ME 04101 TEL: (207) 772-4056 FAX: (207) 772-6022 © COPYRIGHT 2014
Architect:	 ARCHETYPE architects 48 Union Wharf Portland, Maine 04101 (207) 772-6022 Fax (207) 772-4056
Project:	118 ON MUNJOY HILL 118 CONGRESS STREET PORTLAND, MAINE
Revisions:	100% CONSTRUCTION DOCUMENTS
Date:	24 FEB 2014
Scale:	1/4" = 1'-0"
FIRST FLOOR PIPING PLAN	
M6 MSE PROJECT 1332	