



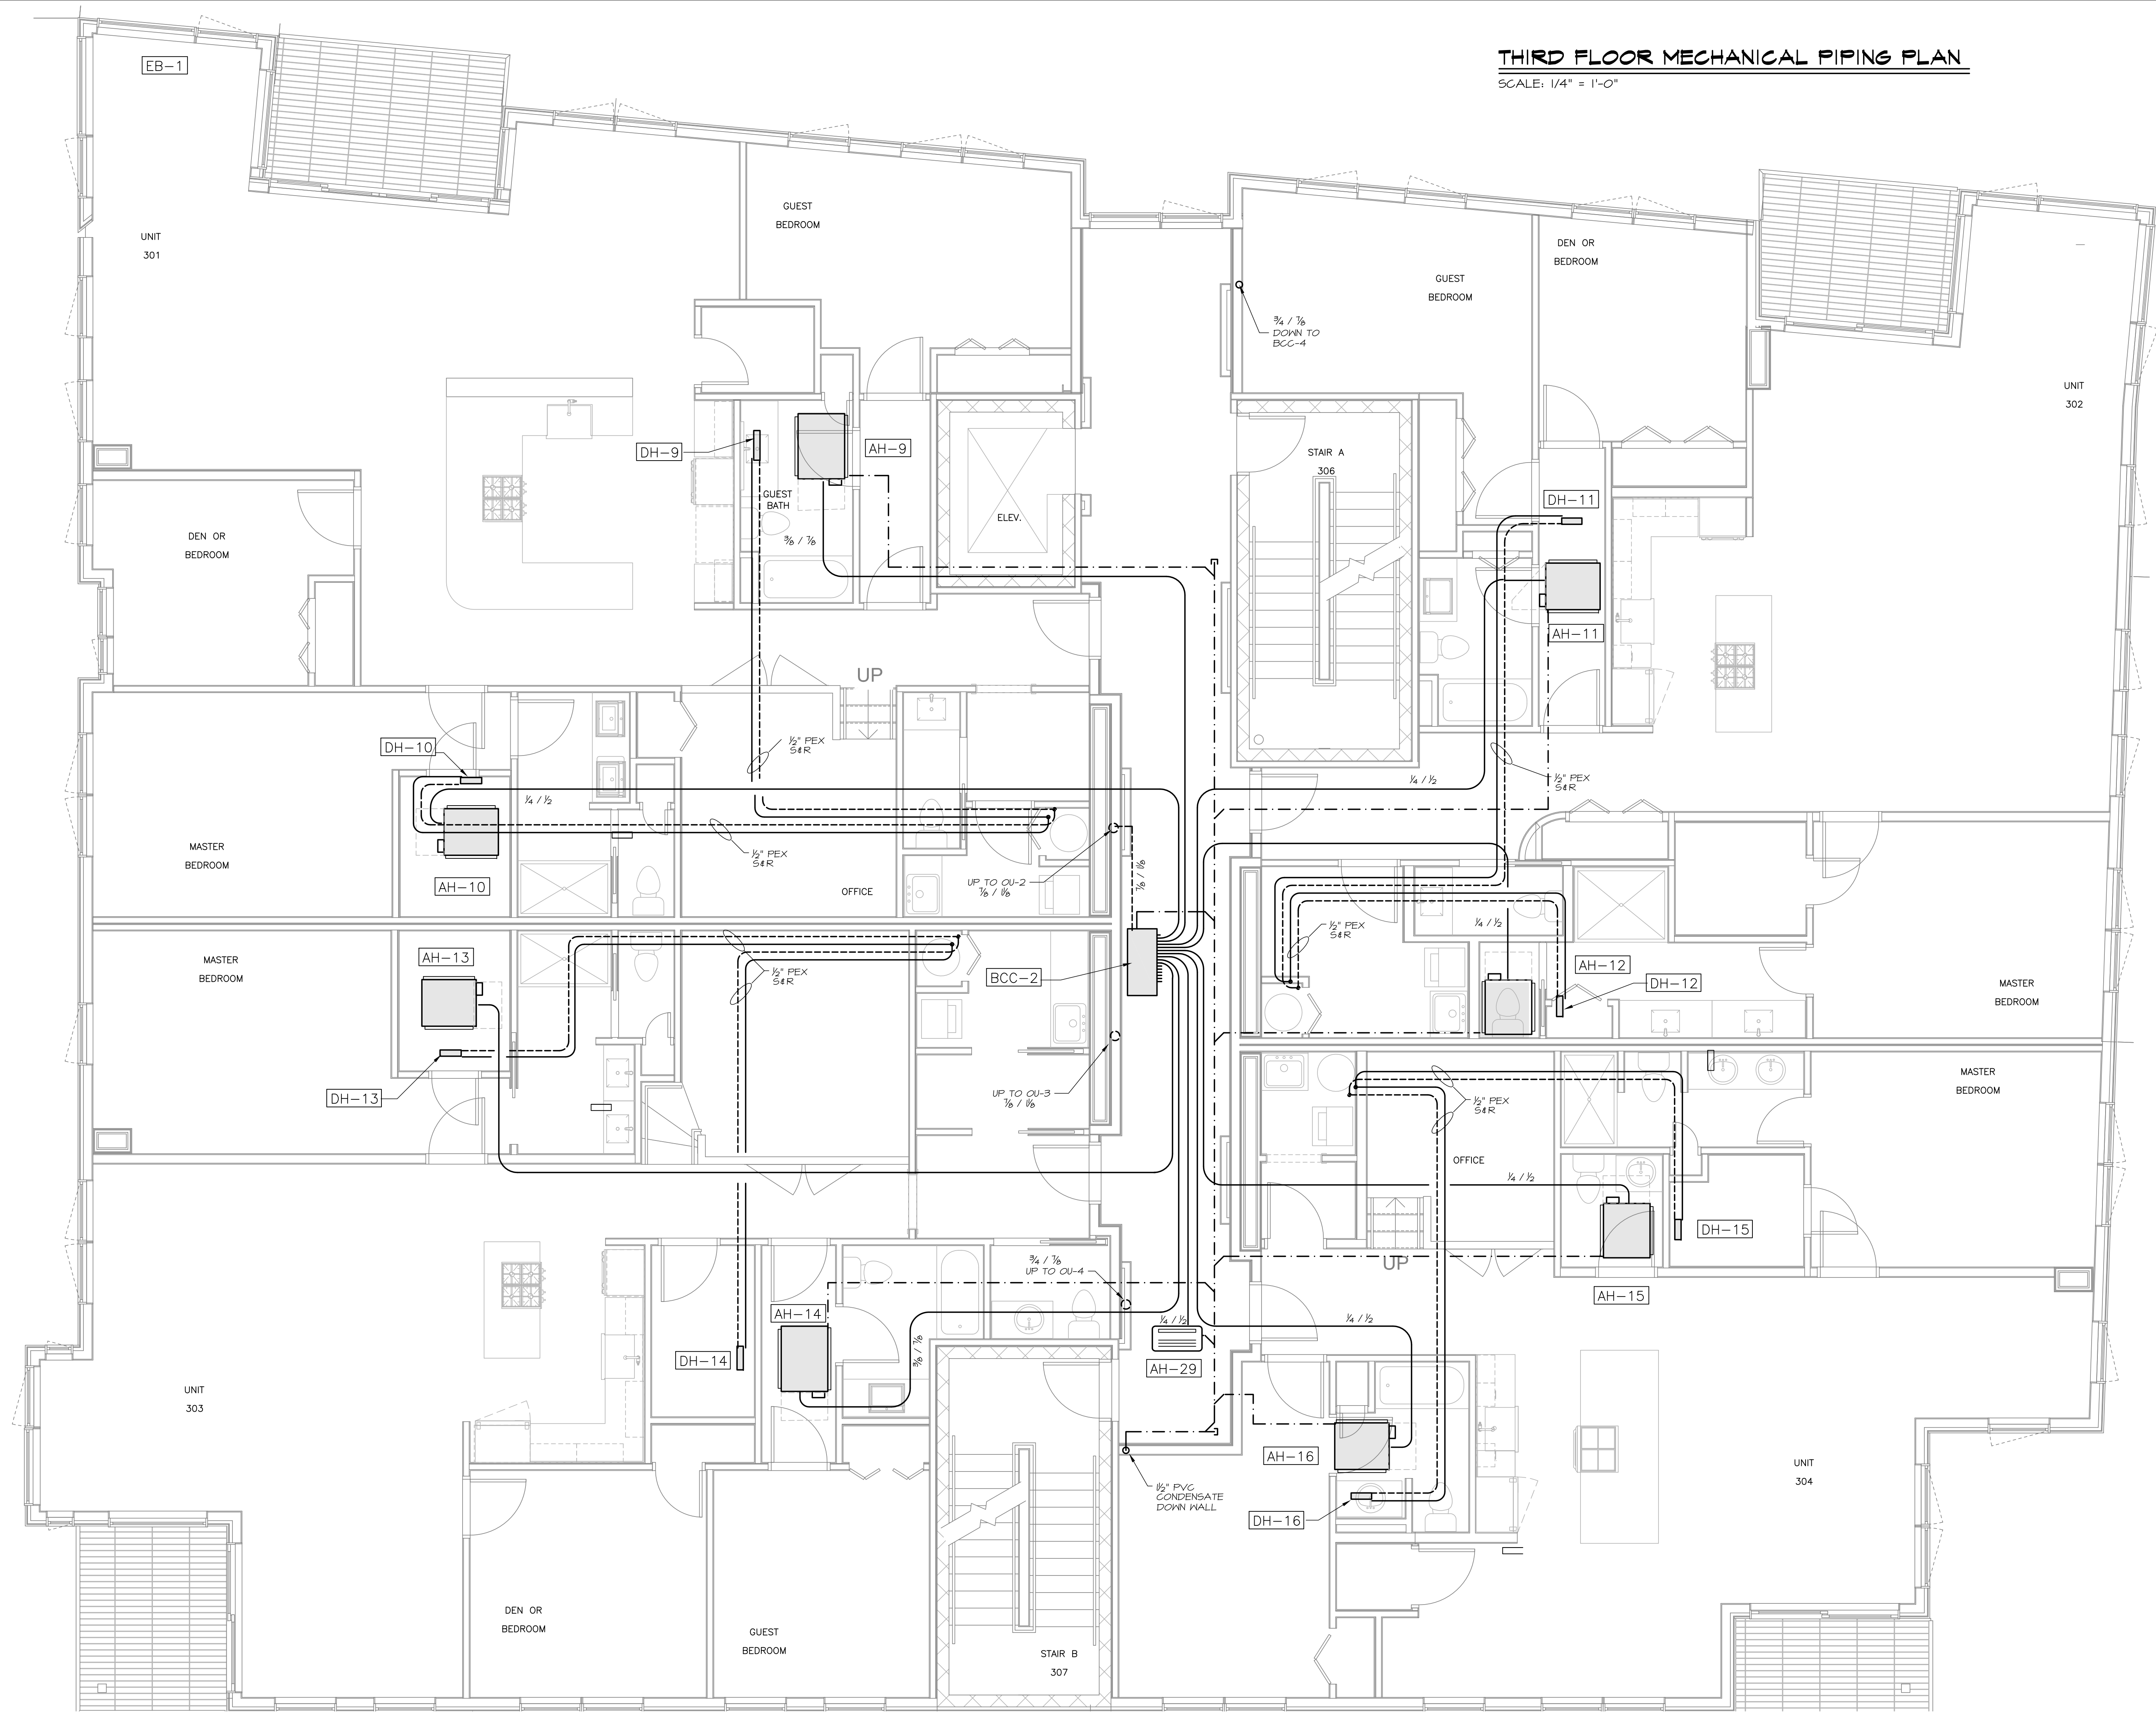

THIRD FLOOR MECHANICAL PIPING PLAN
SCALE: 1/4" = 1'-0"

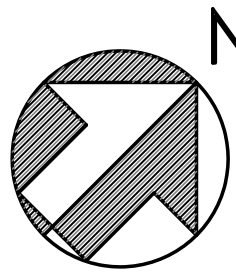

Date: 24 FEB 2014		Scale: 1/4" = 1'-0"	Revisions: 100% CONSTRUCTION DOCUMENTS	Project: 118 ON MUNJOY HILL 118 CONGRESS STREET PORTLAND, MAINE	Architect: ARCHETYPE architects 48 Union Wharf Portland, Maine 04101 (207) 772-6022 Fax (207) 772-4056	Consulting Engineer: MECHANICAL SYSTEMS ENGINEERS 10 FOREST FALLS DRIVE ROYAL FALLEN, MAINE 04158 LICENSED PROFESSIONAL ENGINEERS (207) 466-1441 © COPYRIGHT 2014	Prepared For: 118 on Munjoy Hill, LLC 118 CONGRESS STREET PORTLAND, ME 04101	
M8								