
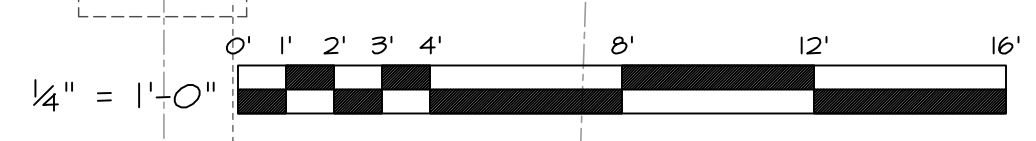


March 03, 2014 - 9:55 am
M:\Projects\1332 118 Congress Street\Drawings\1332 P1-P10.dwg

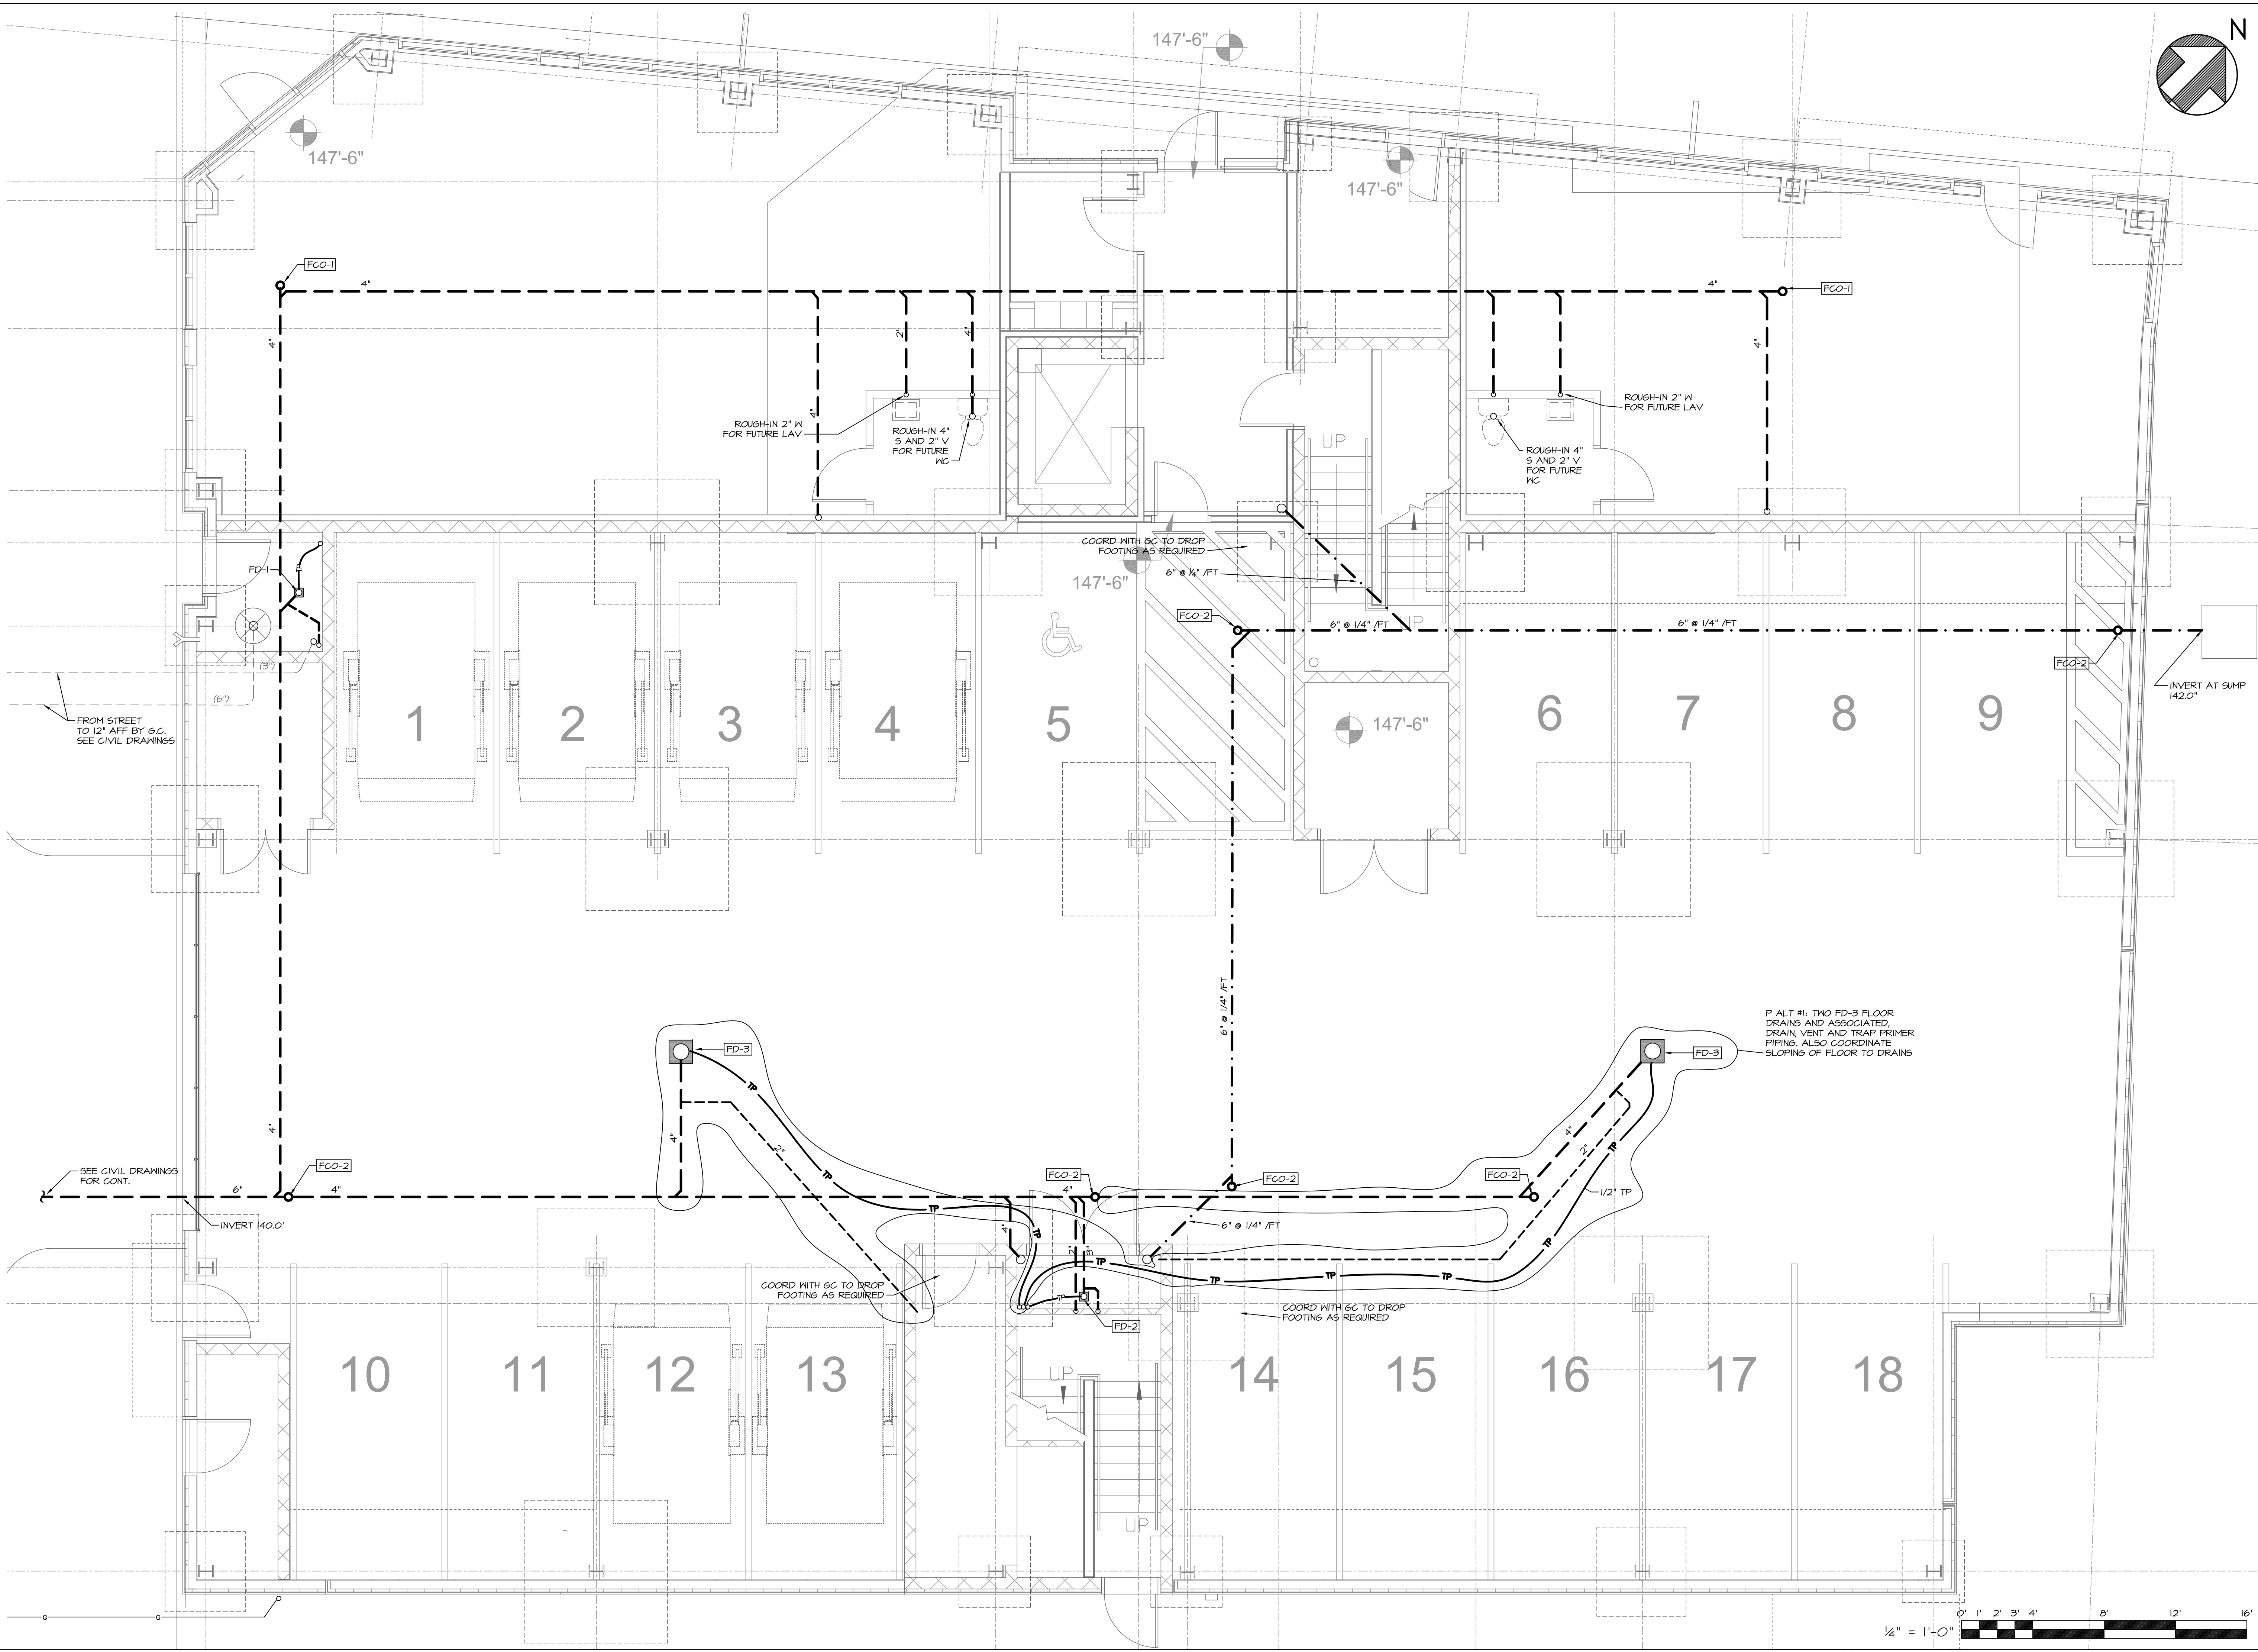

Prepared For:	118 on Munjoy Hill, LLC 118 CONGRESS STREET PORTLAND, ME 04101
Consulting Engineer:	MECHANICAL SYSTEMS ENGINEERS 10 FOREST HILLS DRIVE #10 YARMOUTH, MAINE 04096 TEL: (603) 846-1411 © copyright 2014
Architect:	ARCHETYPE architects 48 Union Wharf Portland, Maine 04101 (207) 772-6022 Fax (207) 772-4056
Project:	118 ON MUNJOY HILL 118 CONGRESS STREET PORTLAND, MAINE
Revisions:	100% CONSTRUCTION DOCUMENTS
Date:	24 FEB 2014
Scale:	1/4" = 1'-0"
UNDERSLAB PLUMBING PLAN	
<h1>P1</h1>	
<small>MSE PROJECT 1332</small>	