
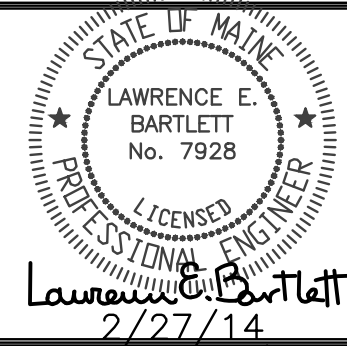


CONGRESS STREET

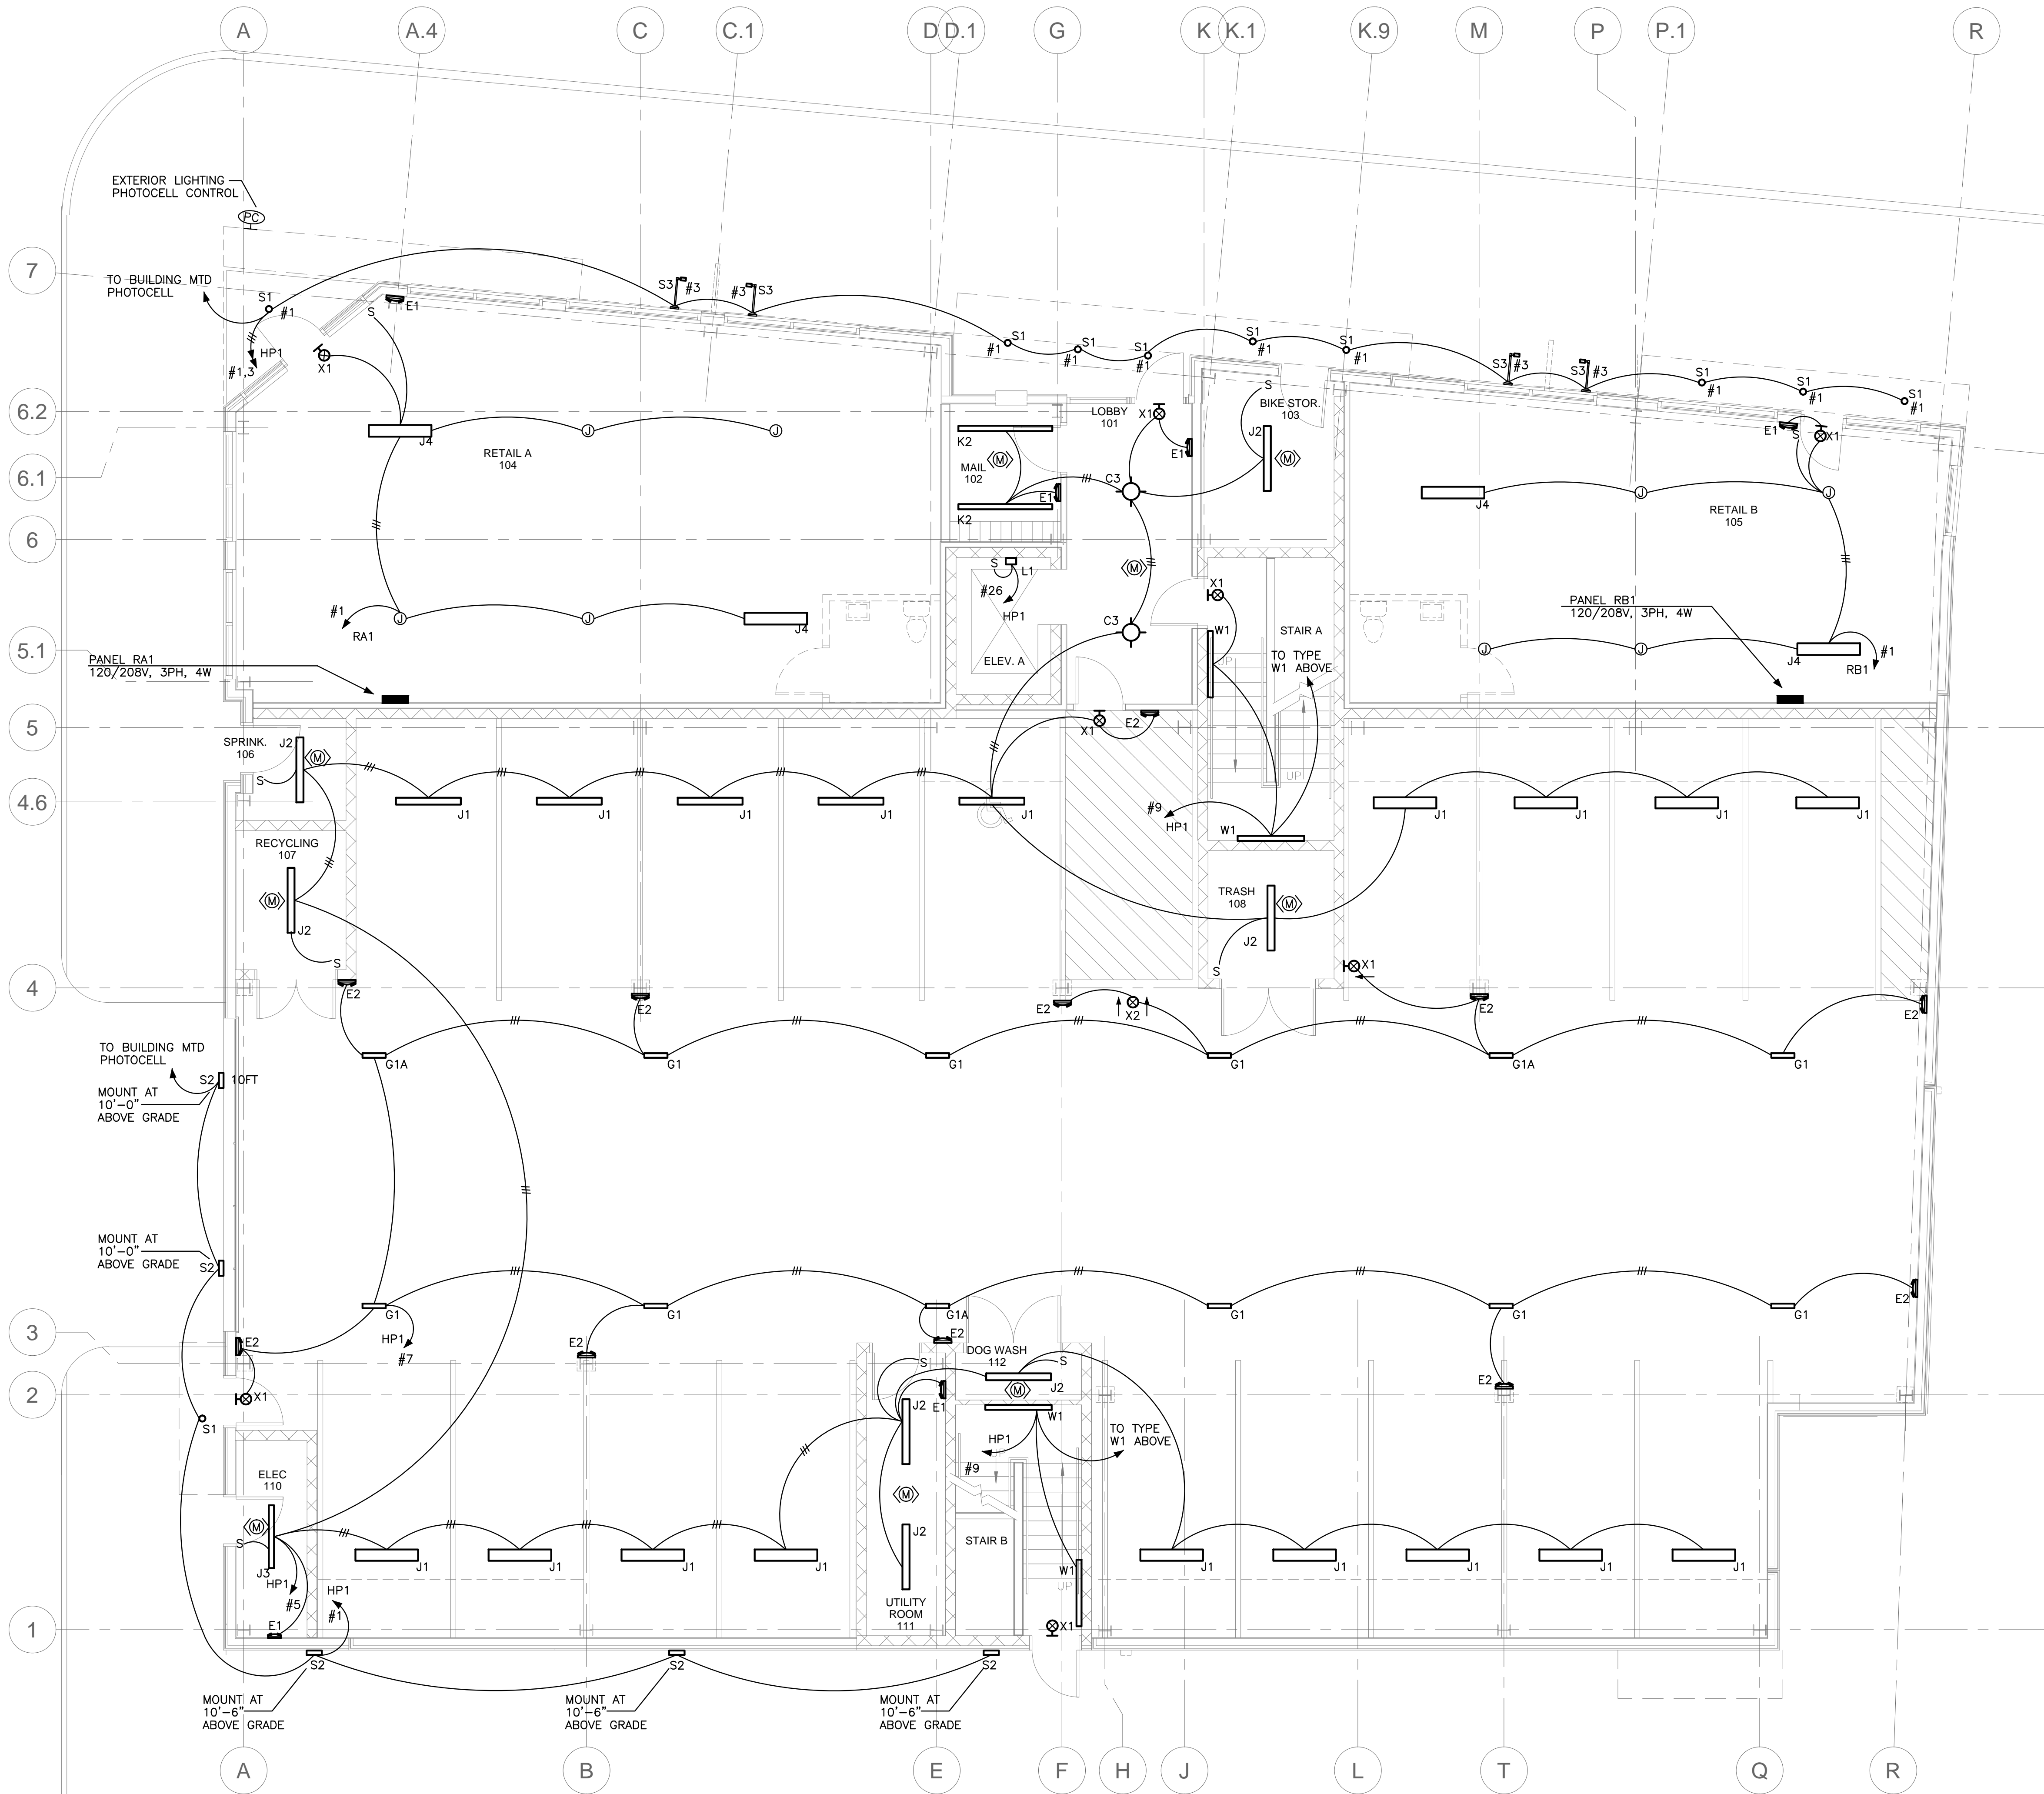

Prepared For:
118 on Munjoy Hill, LLC
 118 Congress Street
 Portland, Maine

Consultant:
Bartlett Design
 LIGHTING & ELECTRICAL ENGINEERING
 48 Union Wharf Portland, ME 04101
 TEL: (207) 443-3447 FAX: (207) 443-6900

Architect:
ARCHETYPE architects
 48 Union Wharf Portland, Maine 04101
 (207) 772-6022 ARCHETYPE@ARCHETYPEPA.COM

Project:
118 ON MUNJOY HILL
 118 CONGRESS STREET
 PORTLAND, MAINE

Revisions:
 01/27/14 50% Pricing Set
 02/24/14 100% Construction Documents

Date: 27 JAN 2014
 Scale: 3/16" = 1'-0"
GROUND FLOOR LIGHTING PLAN

E2.01

