






Reviewed for Code Compliance
Inspection/Change
Approved with Conditions

Date: 05/16/14

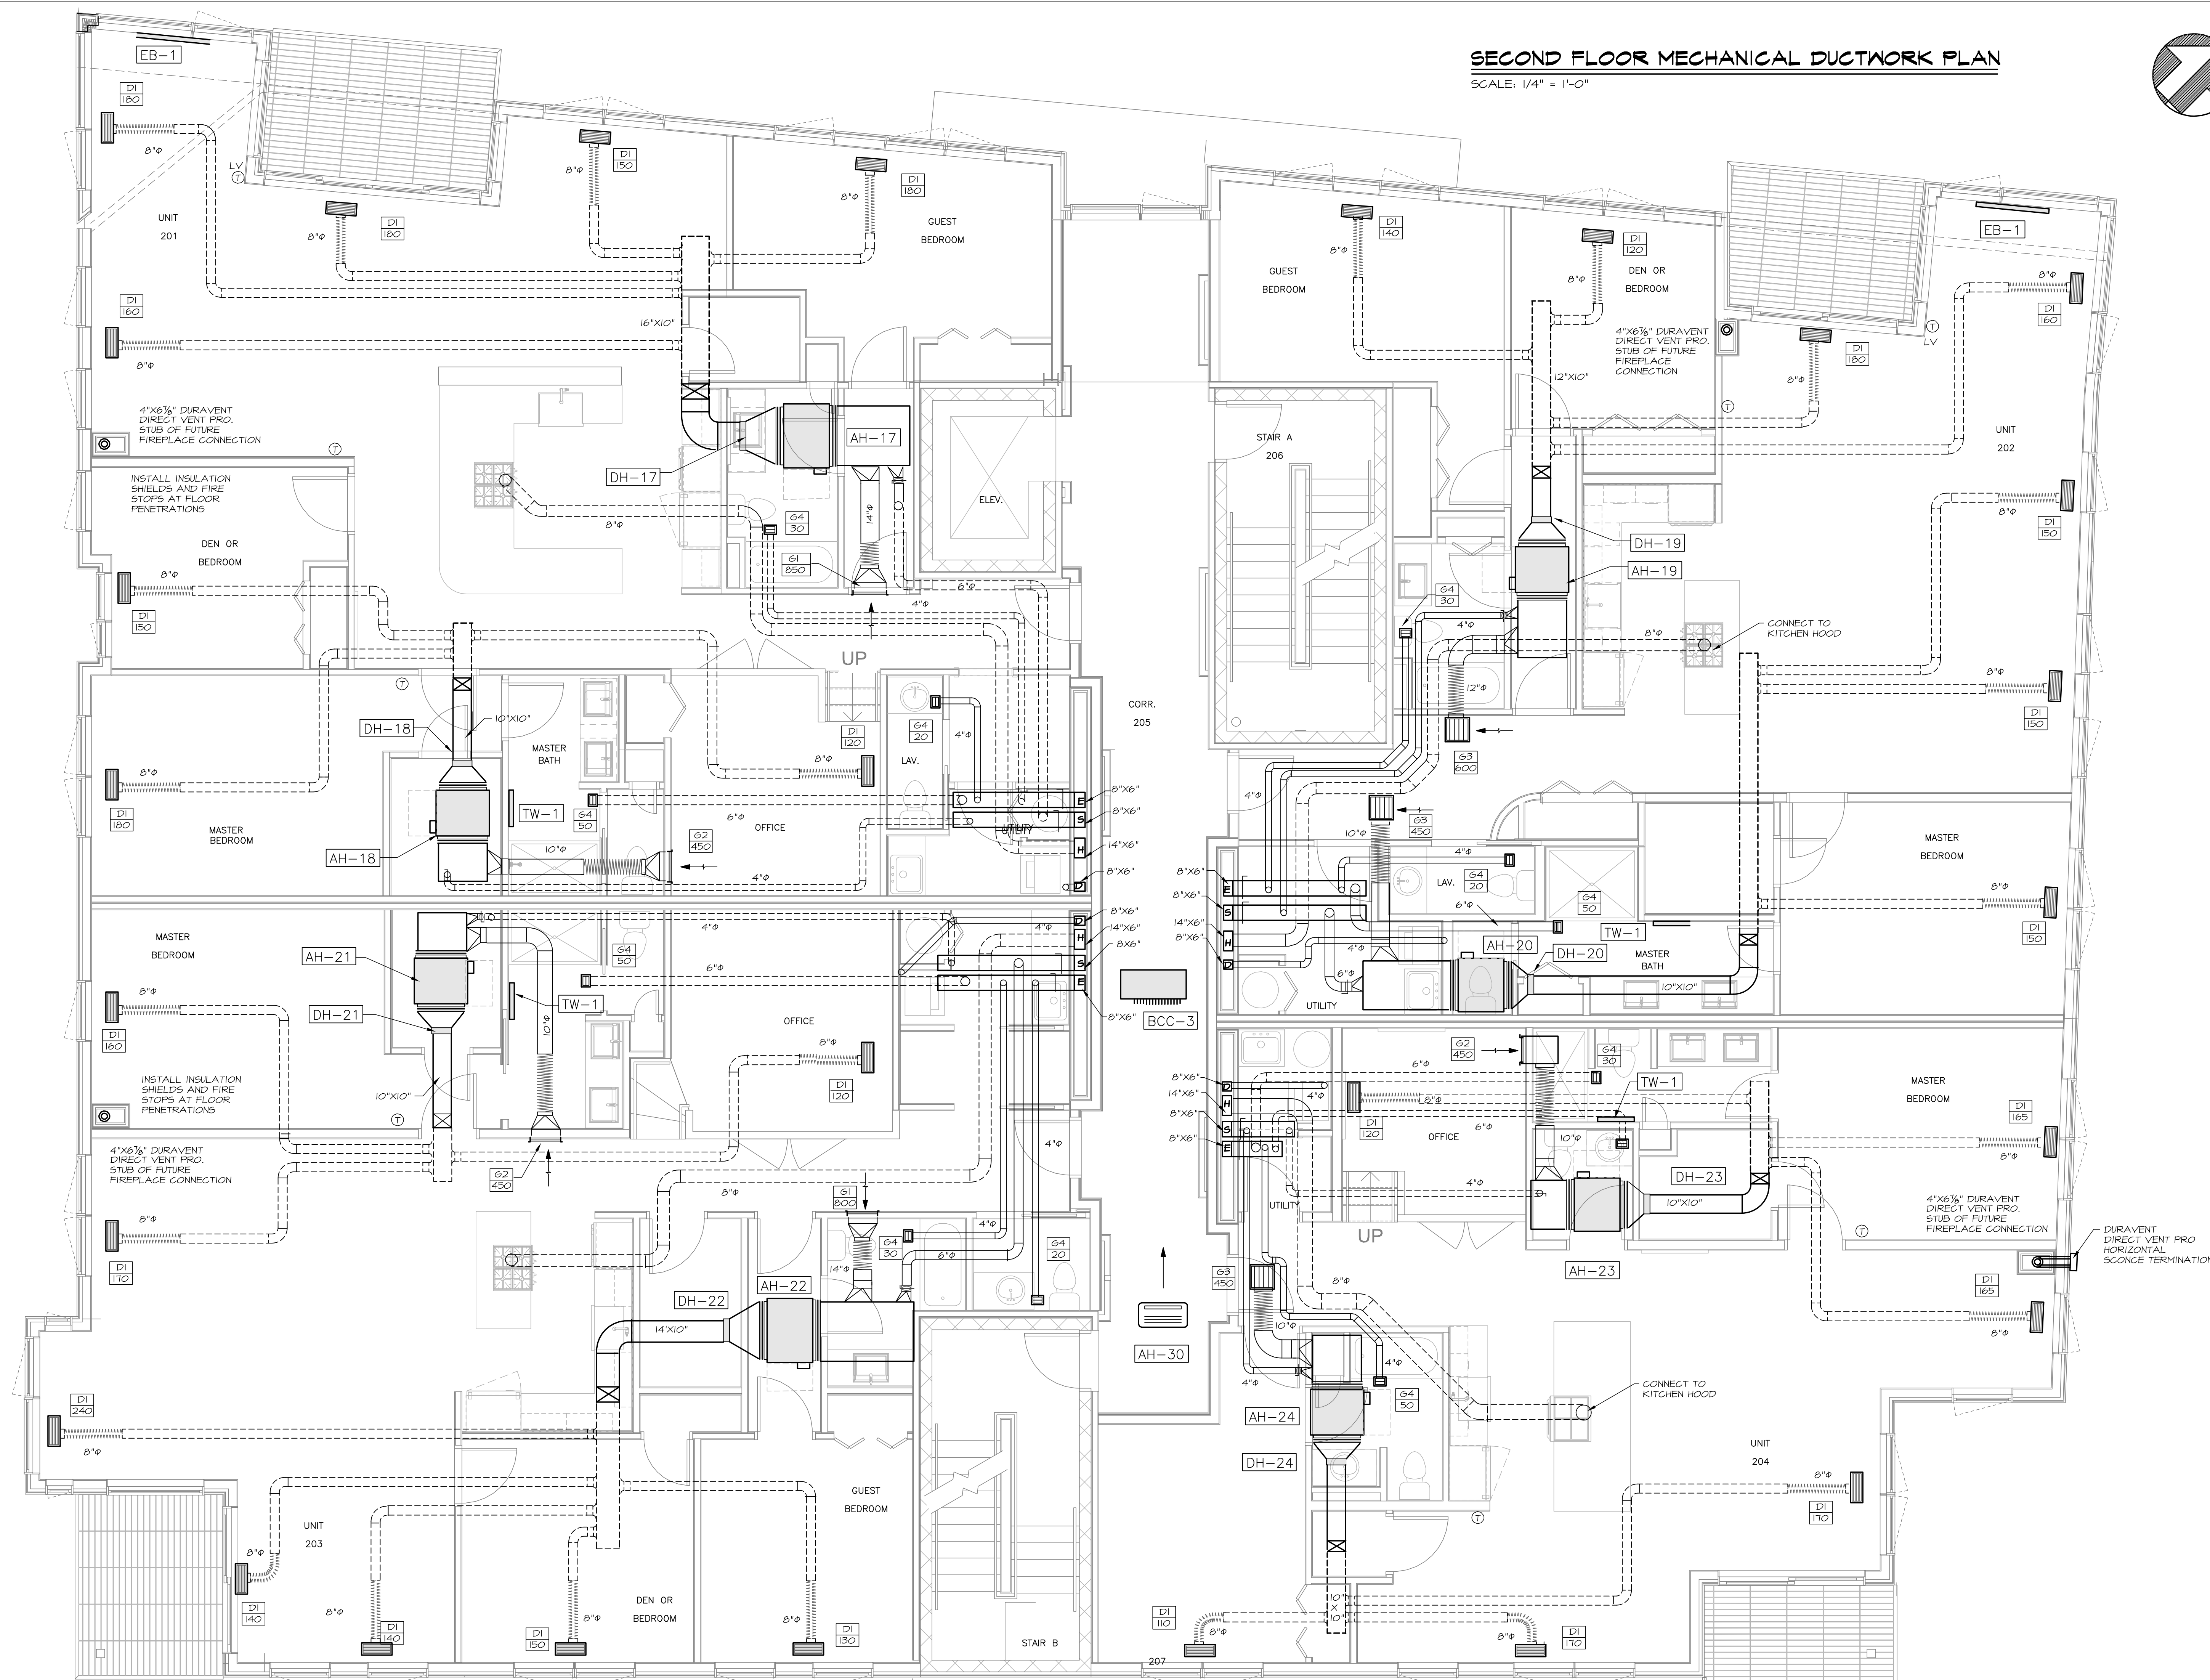

SECOND FLOOR MECHANICAL DUCTWORK PLAN

SCALE: 1/4" = 1'-0"

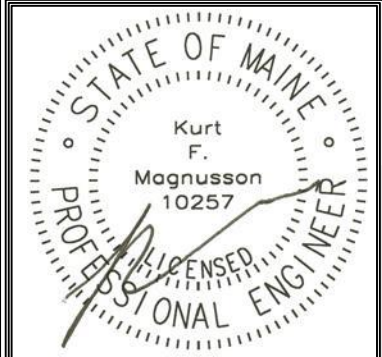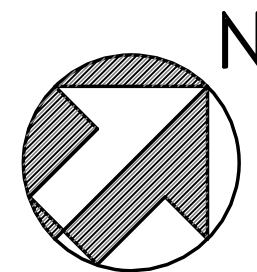

Prepared For:
118 on Munjoy Hill, LLC
118 CONGRESS STREET
PORTLAND, ME 04101

Consulting Engineer:
MECHANICAL SYSTEMS ENGINEERS
ROYAL RIVER CENTER, UNIT #10
156 GORHAM STREET, PORTLAND, ME 04101
TEL: (207) 772-4056
FAX: (207) 772-4056
© COPYRIGHT 2014

Architect:
ARCHETYPE architects
48 Union Wharf Portland, Maine 04101
(207) 772-6022 Fax (207) 772-4056

Project:
118 ON MUNJOY HILL
118 CONGRESS STREET
PORTLAND, MAINE

Revisions:
100% CONSTRUCTION DOCUMENTS

Date: 24 FEB 2014
Scale: 1/4" = 1'-0"
SECOND FLOOR DUCTWORK PLAN

M2
USE PROJECT 1332