





Reviewed for Code Compliance
Inspection/Division
Approved with Conditions
Date: 05/16/14

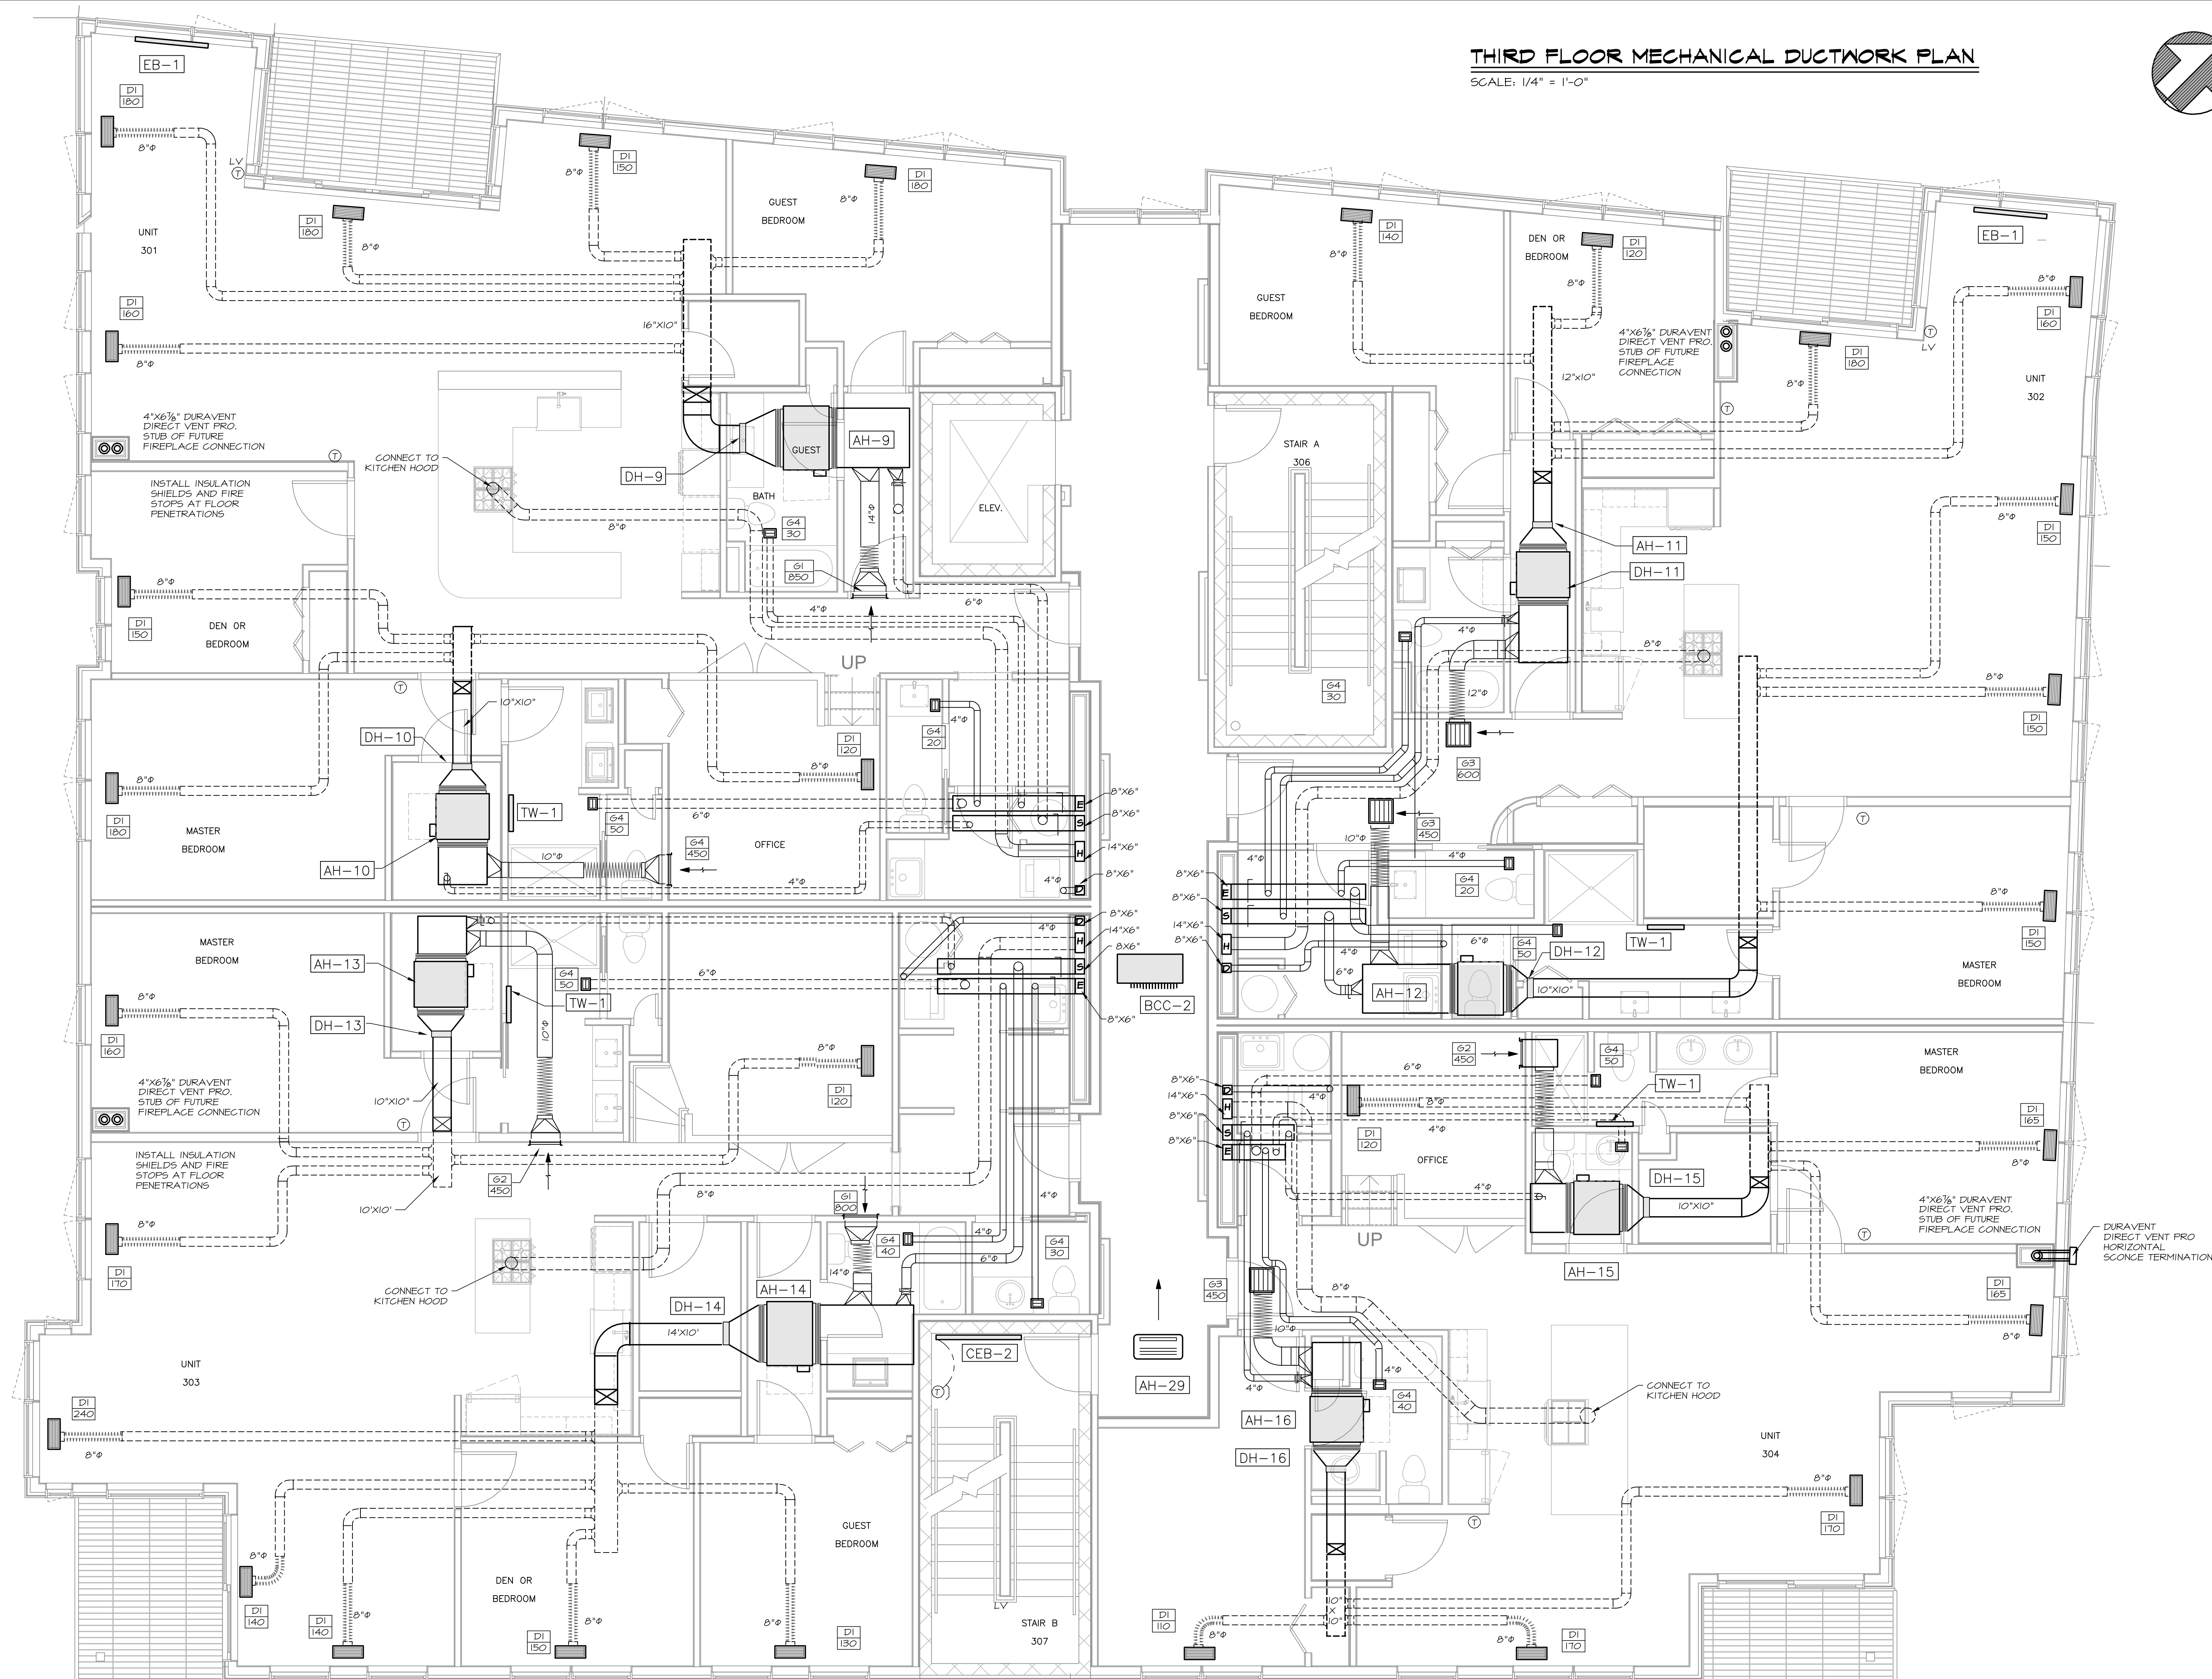

THIRD FLOOR MECHANICAL DUCTWORK PLAN
SCALE: 1/4" = 1'-0"

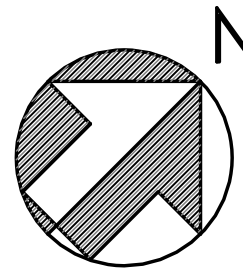

Date: 24 FEB 2014	Scale: 1/4" = 1'-0"	Revisions: 100% CONSTRUCTION DOCUMENTS	Project: 118 ON MUNJOY HILL 118 CONGRESS STREET PORTLAND, MAINE	Architect: ARCHETYPE architects 48 Union Wharf Portland, Maine 04101 (207) 772-6022 Fax (207) 772-4056	Consulting Engineer: MECHANICAL SYSTEMS ENGINEERS ROYAL RIVER CENTER, UNIT #10 156 GORHAM ST., PORTLAND, MAINE 04106 FACEBOOK: MECHANICAL SYSTEMS ENGINEERS © COPYRIGHT 2014	Prepared For: 118 on Munjoy Hill, LLC 118 CONGRESS STREET PORTLAND, ME 04101	

M3
USE PROJECT 1332