





Reviewed for Code Compliance
Inspection/Change
Approved with Conditions
Date: 05/16/14

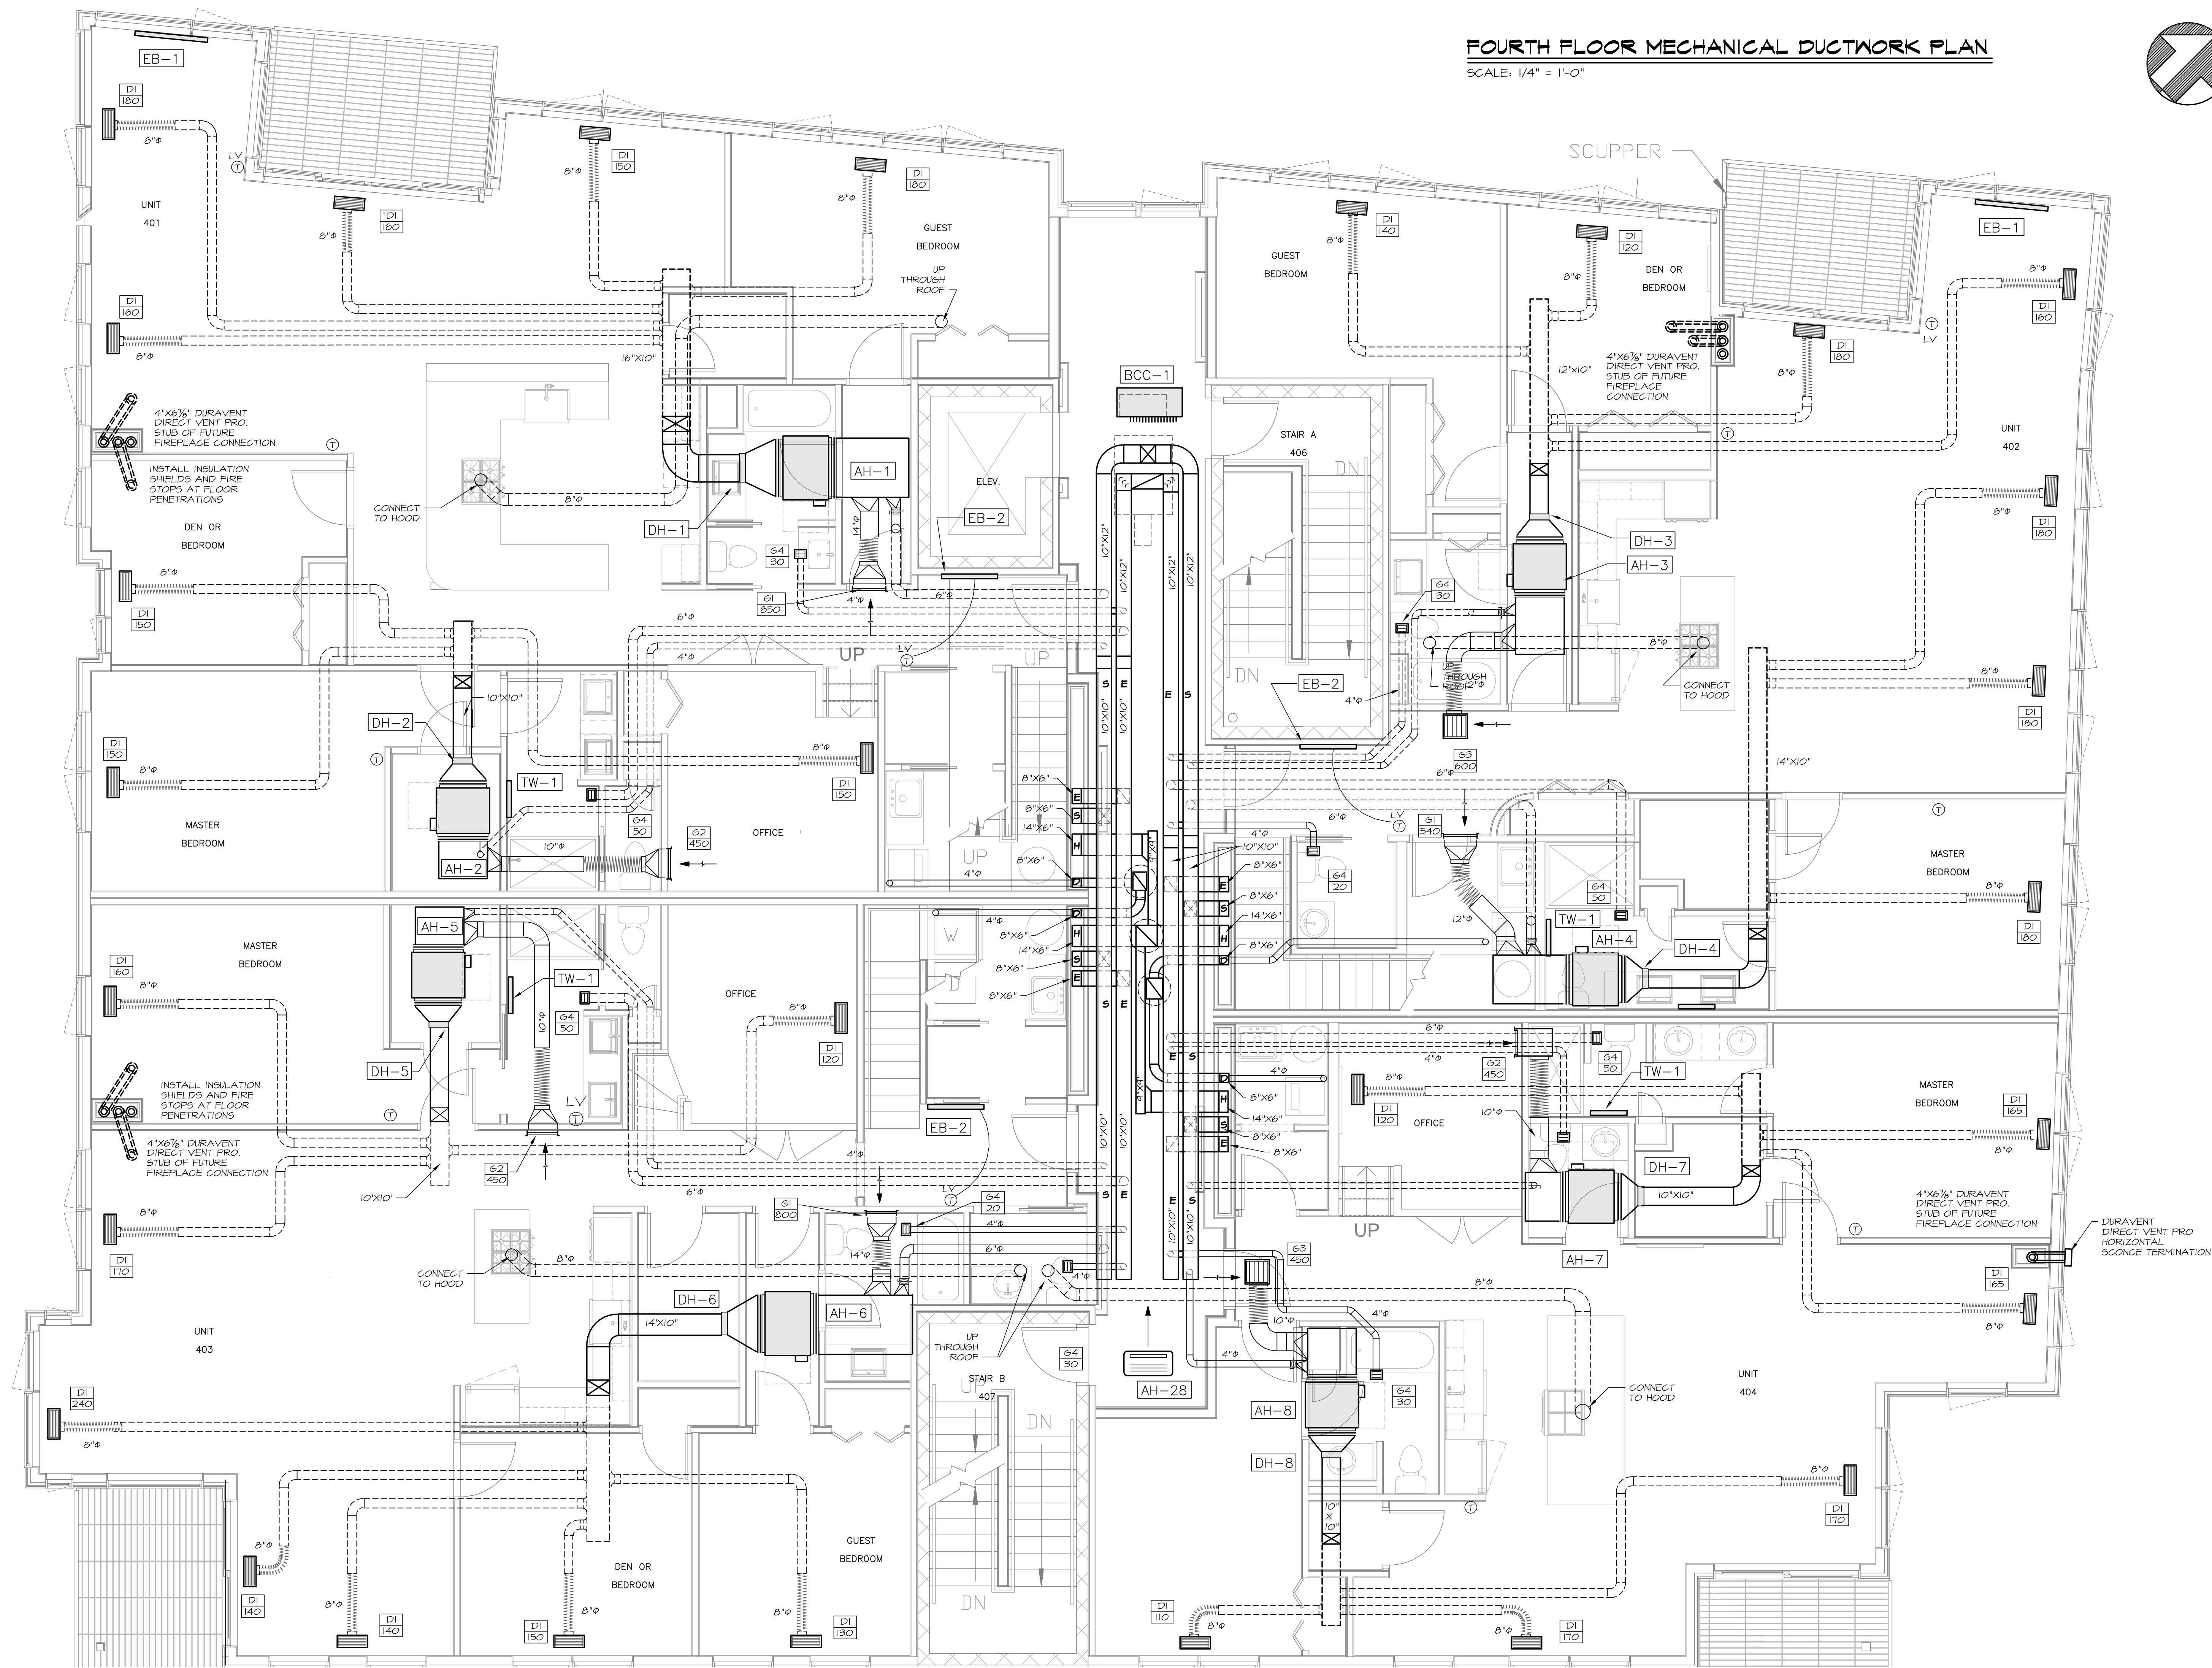

FOURTH FLOOR MECHANICAL DUCTWORK PLAN
SCALE: 1/4" = 1'-0"

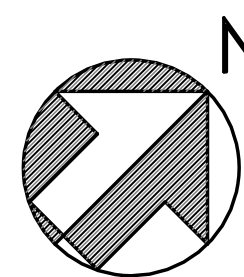

Prepared For:	118 on Munjoy Hill, LLC 118 CONGRESS STREET PORTLAND, ME 04101
Consulting Engineer:	 MECHANICAL SYSTEMS ENGINEERS, INC. ROYAL RIVER CENTER, UNIT #110 156 GORHAM STREET, PORTLAND, ME 04106 TEL: (207) 772-4056 FAX: (207) 772-4056 © COPYRIGHT 2014
Architect:	 ARCHETYPE architects 48 Union Wharf Portland, Maine 04101 (207) 772-6022 Fax (207) 772-4056
Project:	118 ON MUNJOY HILL 118 CONGRESS STREET PORTLAND, MAINE
Revisions:	100% CONSTRUCTION DOCUMENTS
Date:	24 FEB 2014
Scale:	1/4" = 1'-0"
FOURTH FLOOR DUCTWORK PLAN	
M4	
MSE PROJECT 1332	