





Reviewed for Code Compliance  
Inspection/Division  
Approved with Conditions

Date: 05/16/14

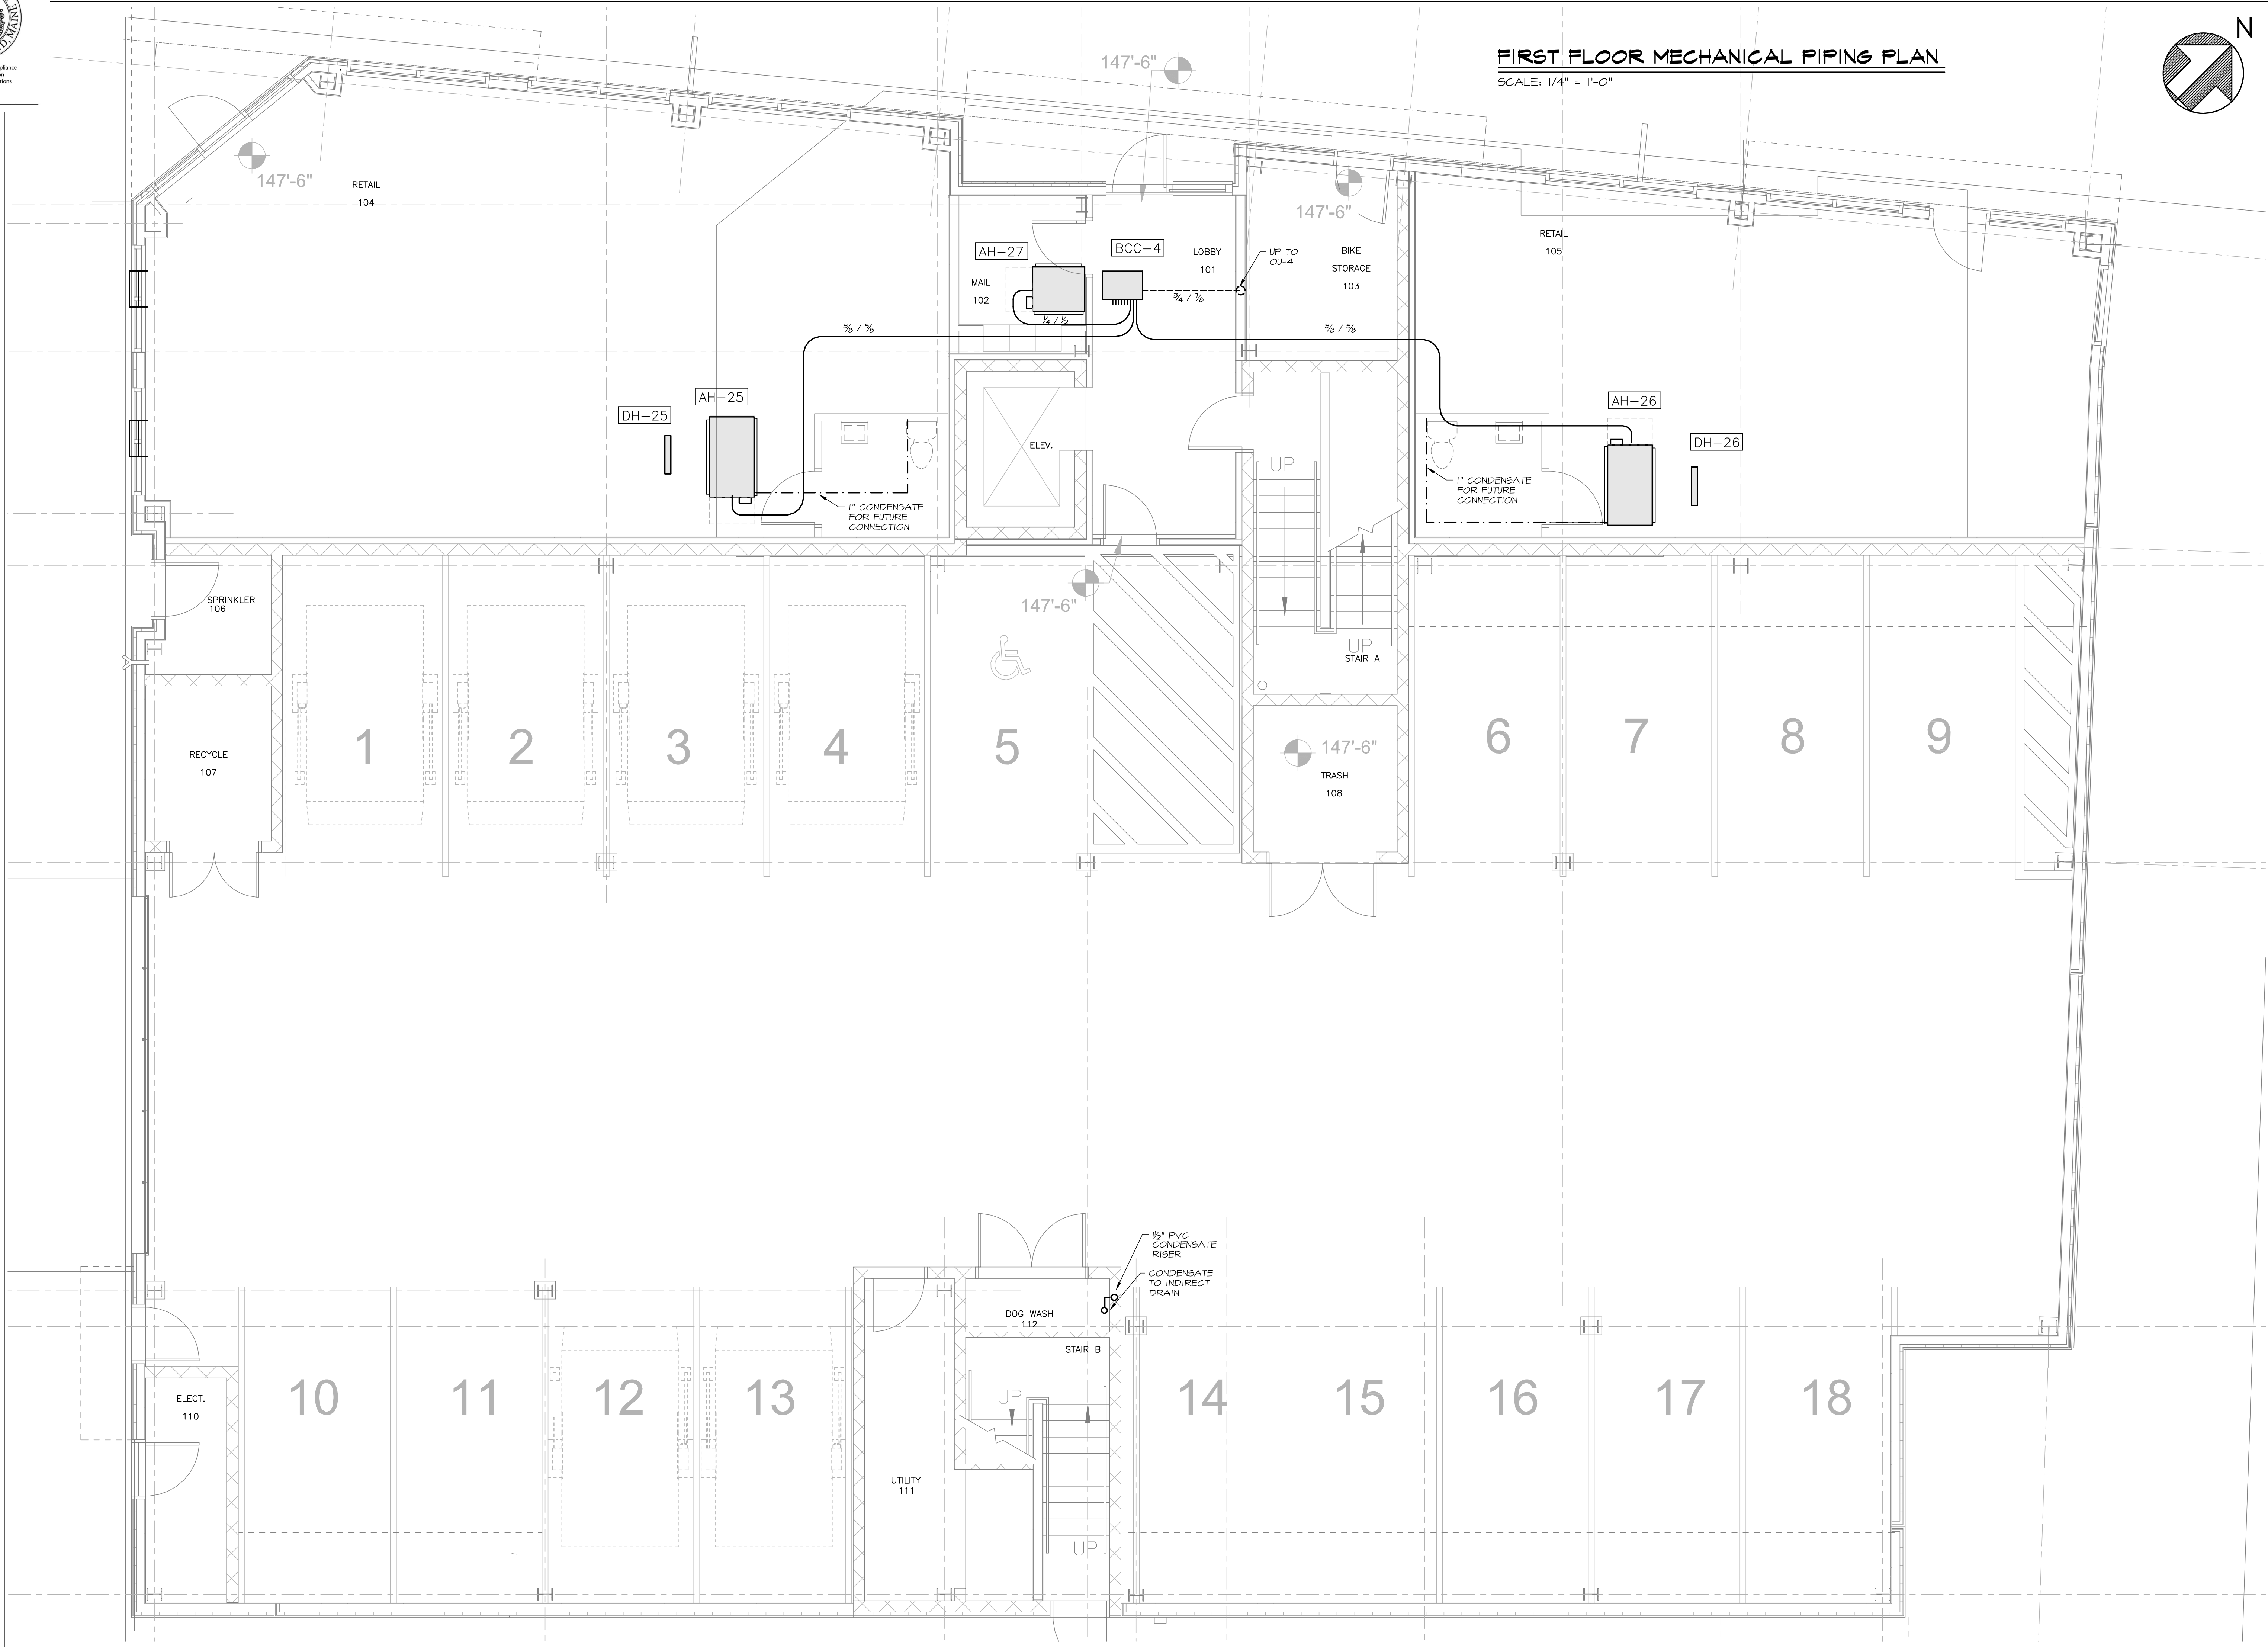

**FIRST FLOOR MECHANICAL PIPING PLAN**  
SCALE: 1/4" = 1'-0"

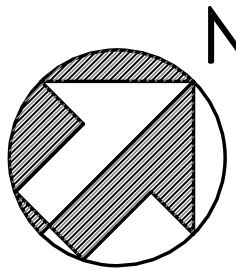

Prepared For:	<b>118 on Munjoy Hill, LLC</b> 118 CONGRESS STREET PORTLAND, ME 04101
Consulting Engineer:	 <b>MECHANICAL SYSTEMS ENGINEERS, INC.</b> ROYAL RIVER CENTER, UNIT #10 156 GORHAM STREET, PORTLAND, ME 04106 TEL: (207) 772-4056 FAX: (207) 772-4056 © COPYRIGHT 2014
Architect:	 <b>ARCHETYPE architects</b> 48 Union Wharf Portland, Maine 04101 (207) 772-6022 Fax (207) 772-4056
Project:	<b>118 ON MUNJOY HILL</b> 118 CONGRESS STREET PORTLAND, MAINE
Revisions:	<b>100% CONSTRUCTION DOCUMENTS</b>
Date:	24 FEB 2014
Scale:	1/4" = 1'-0"
<b>FIRST FLOOR PIPING PLAN</b>	
<b>M6</b> MSE PROJECT 1332	