





Reviewed for Code Compliance
Inspection/Division
Approved with Conditions

Date: 05/16/14

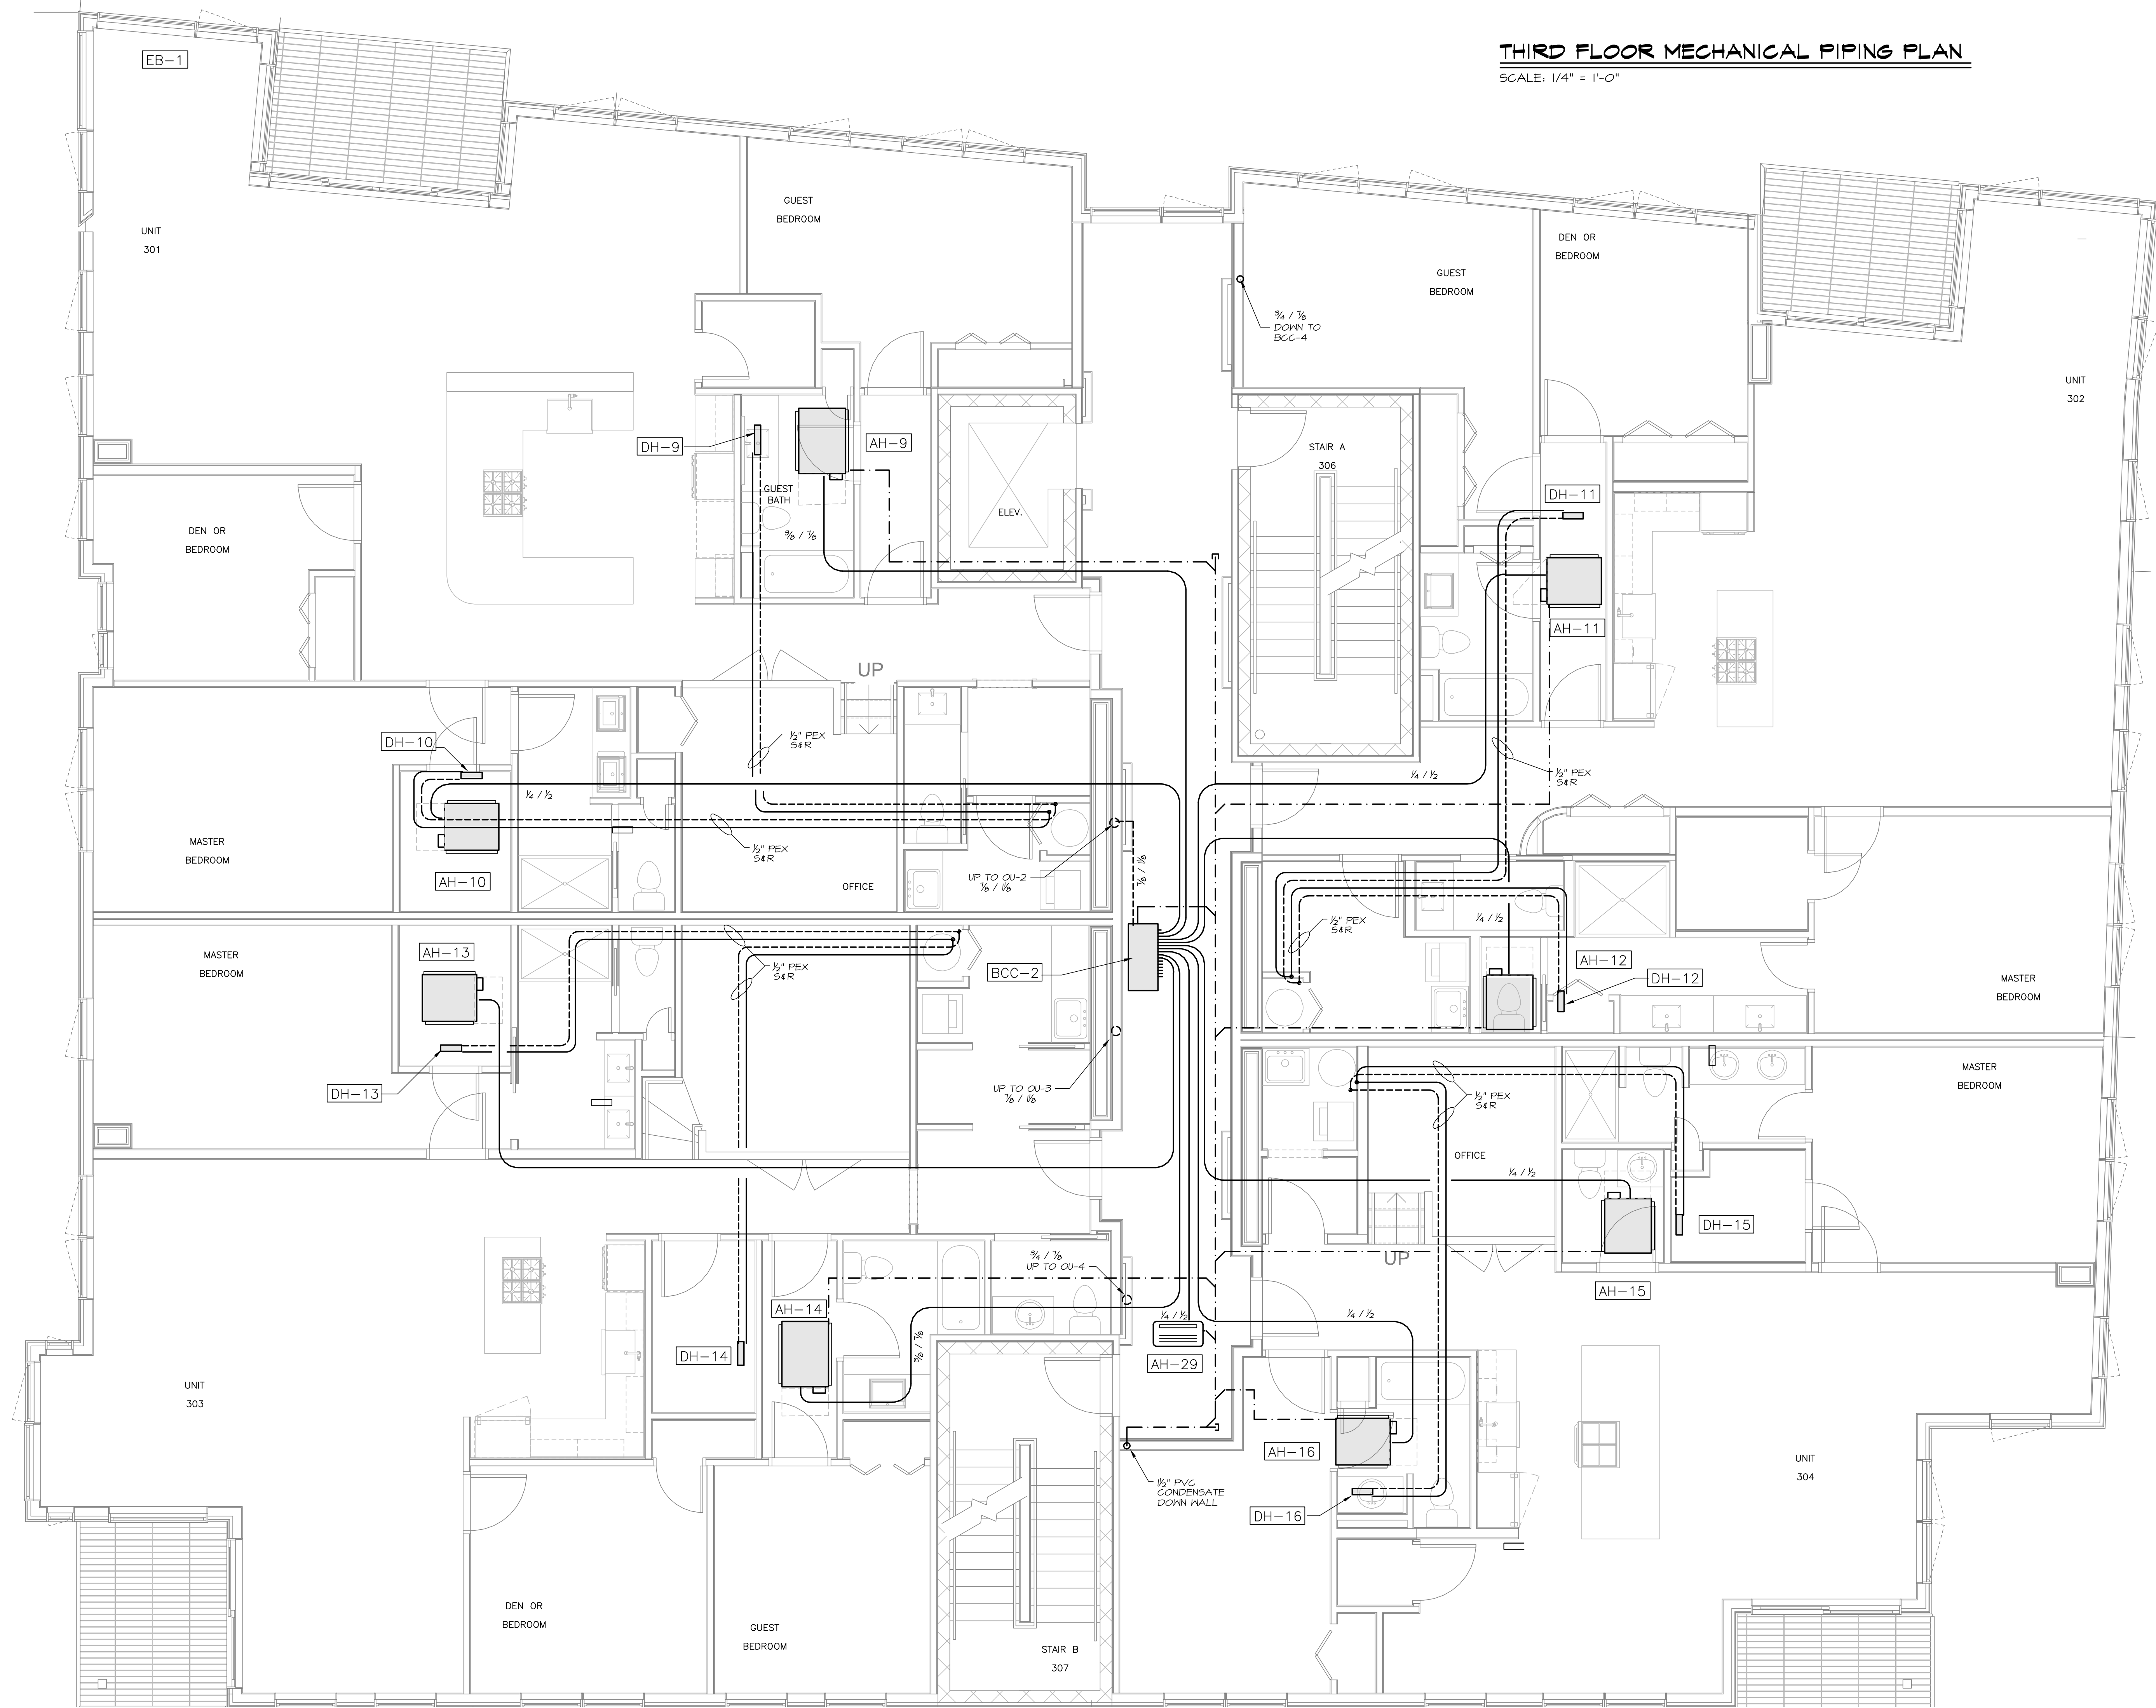

THIRD FLOOR MECHANICAL PIPING PLAN

SCALE: 1/4" = 1'-0"

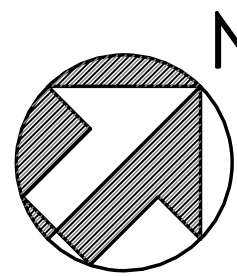

Prepared For:	118 on Munjoy Hill, LLC 118 CONGRESS STREET PORTLAND, ME 04101
Consulting Engineer:	 MECHANICAL SYSTEMS ENGINEERS ROYAL RIVER CENTER, UNIT #10 156 GORHAM, MAINE 04068 TEL: (207) 772-4056 FAX: (207) 772-4056 © COPYRIGHT 2014
Architect:	 ARCHETYPE architects 48 Union Wharf Portland, Maine 04101 (207) 772-6022 Fax (207) 772-4056
Project:	118 ON MUNJOY HILL 118 CONGRESS STREET PORTLAND, MAINE
Revisions:	100% CONSTRUCTION DOCUMENTS
Date:	24 FEB 2014
Scale:	1/4" = 1'-0"
THIRD FLOOR PIPING PLAN	
M8	
MSE PROJECT 1332	