



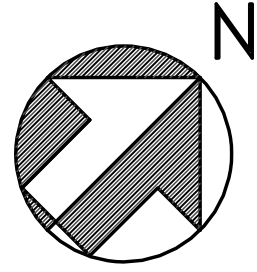

Reviewed for Code Compliance
Inspection/Division
Approved with Conditions

Date: 05/16/14

February 28, 2014 -- 8:03 pm
M:\Projects\1332 118 Congress Street\Drawings\1332 P1-P10.dwg

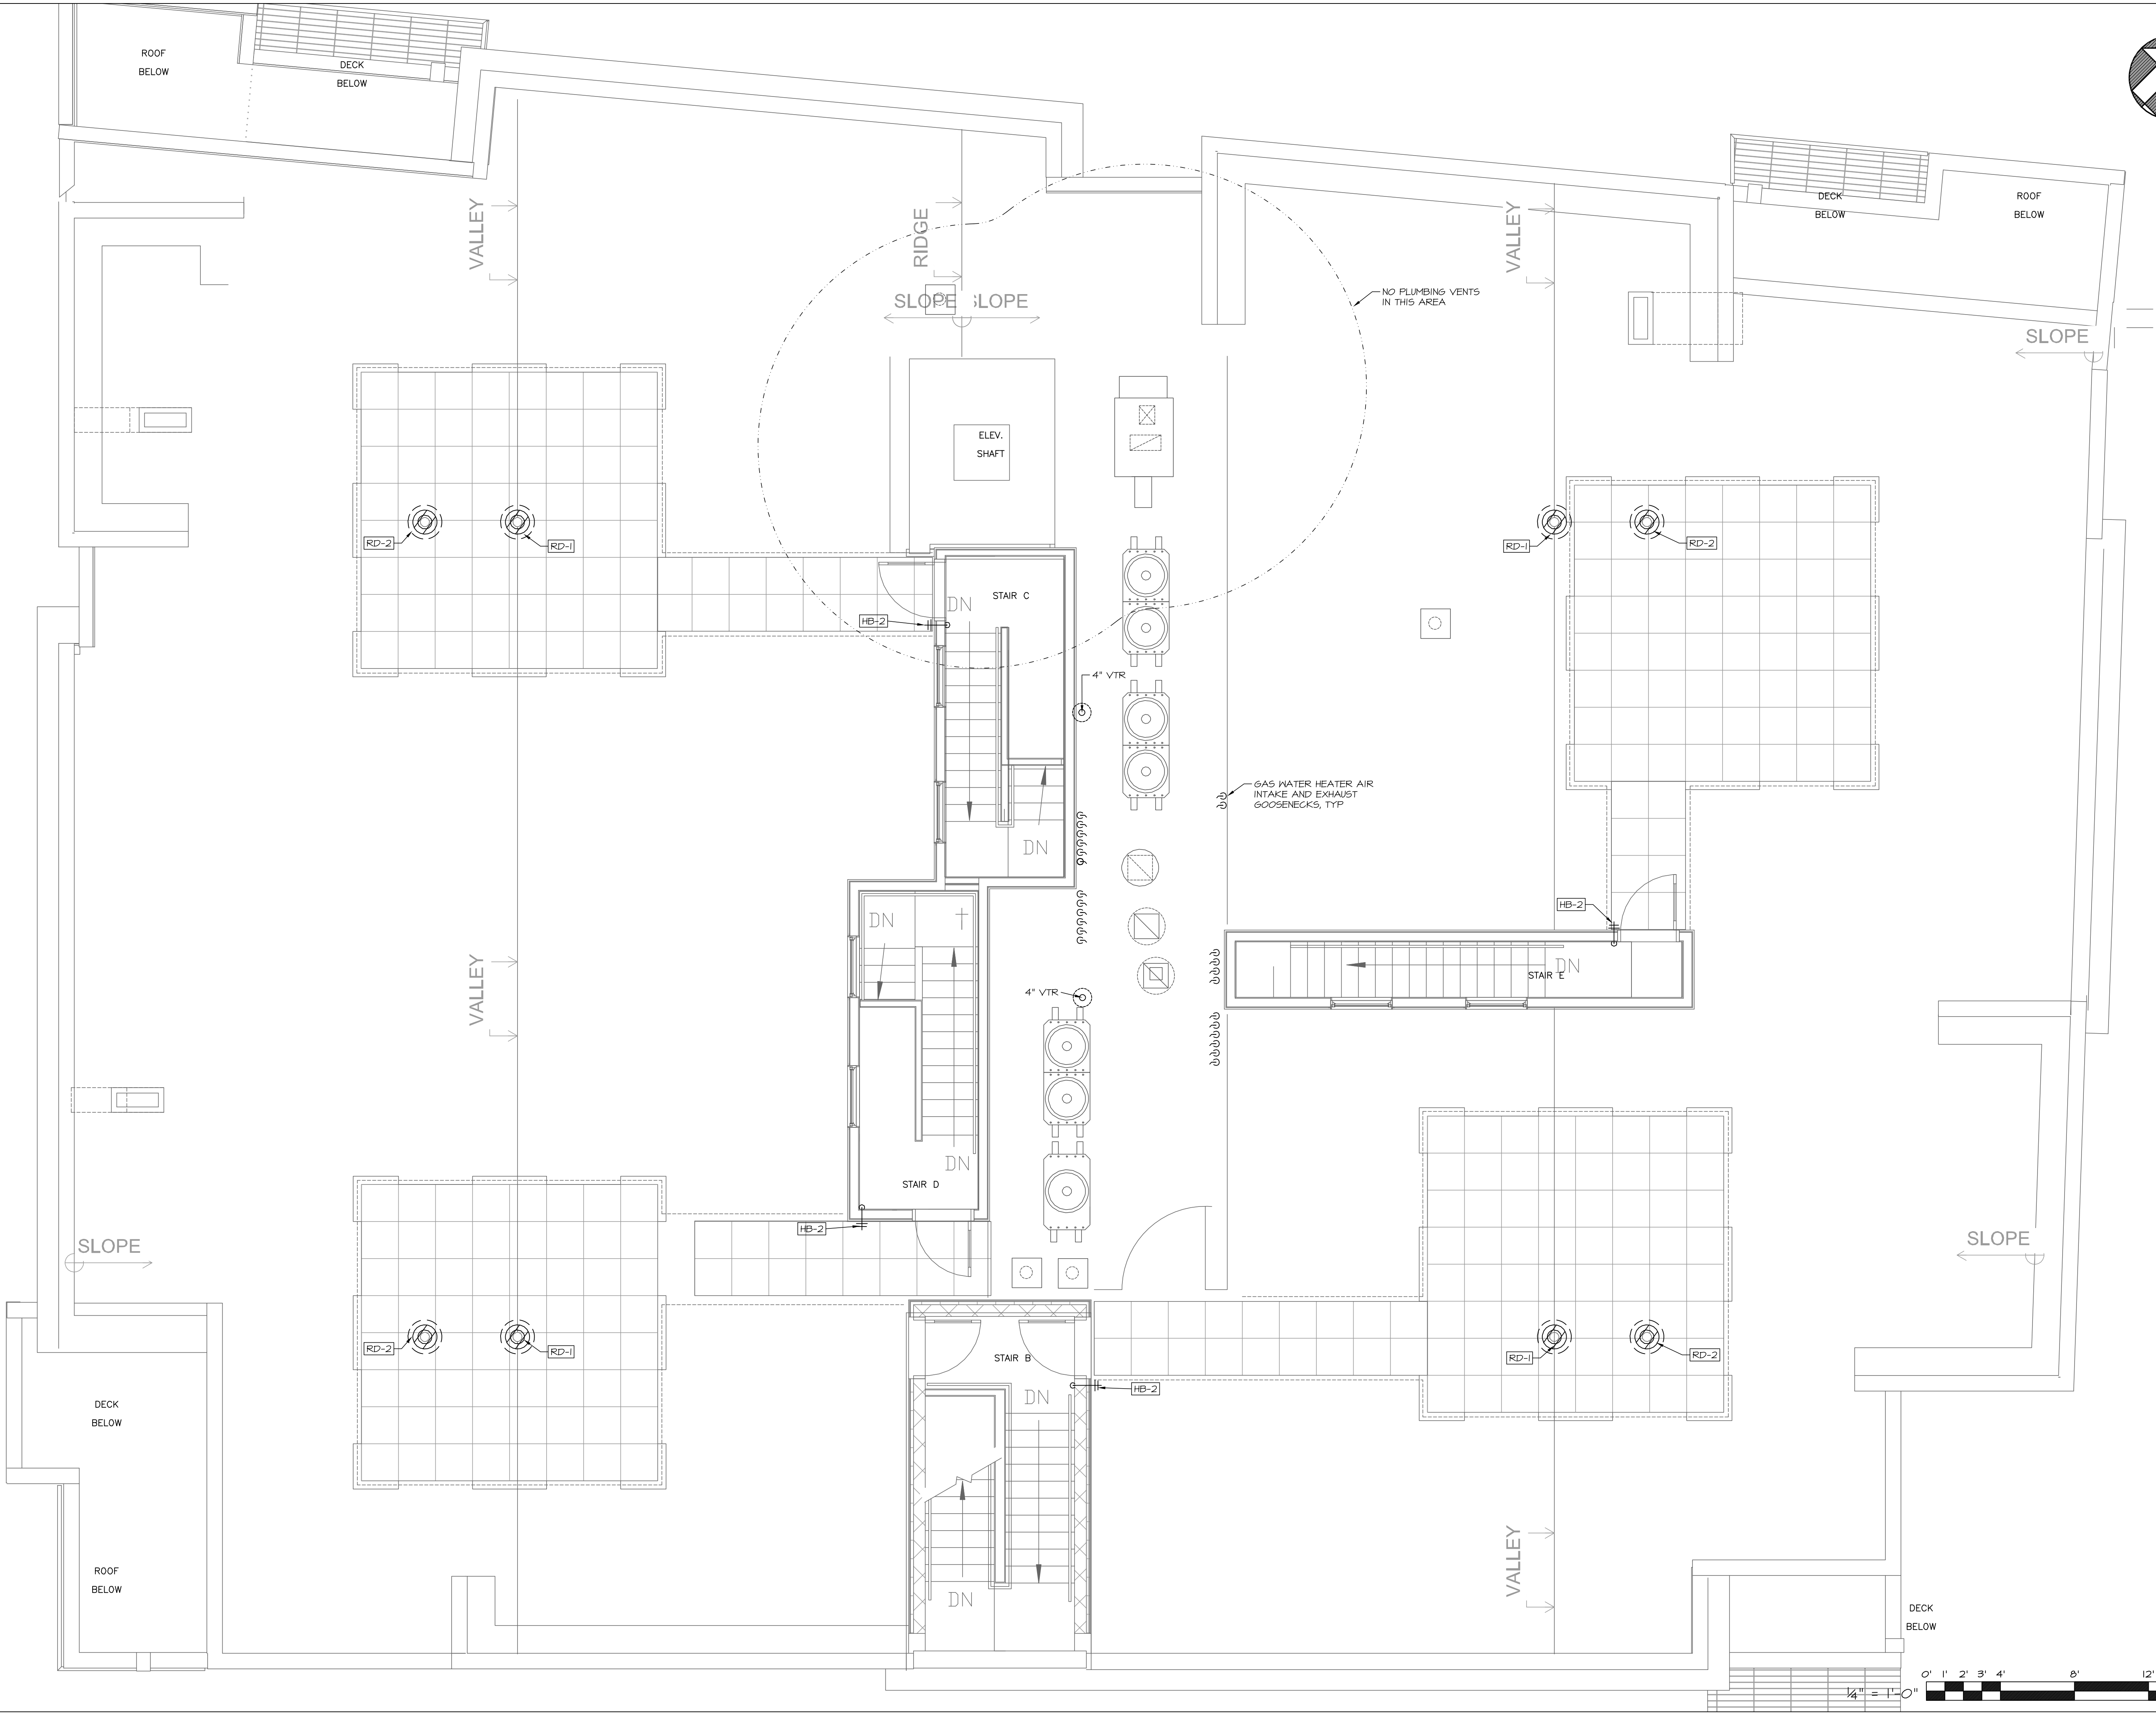

	Prepared For:	118 on Munjoy Hill, LLC	118 CONGRESS STREET PORTLAND, ME 04101
	Consulting Engineer:	 MECHANICAL SYSTEMS ENGINEERS 10 FOREST FALLS DRIVE YACON, MAINE 04089 (207) 848-1441 © copyright 2014	
Architect	Project:	118 ON MUNJOY HILL	118 CONGRESS STREET PORTLAND, MAINE
	Revisions:	100% CONSTRUCTION DOCUMENTS	
Date:	Scale:	24 FEB 2014	1/4" = 1'-0"
		ROOF PLUMBING PLAN	
P10		MSE PROJECT 1332	