



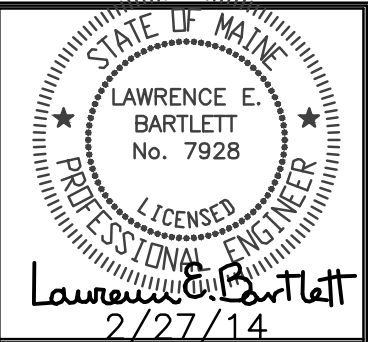

Reviewed for Code Compliance
Inspection Division
Approved with Conditions

Date: 05/16/14

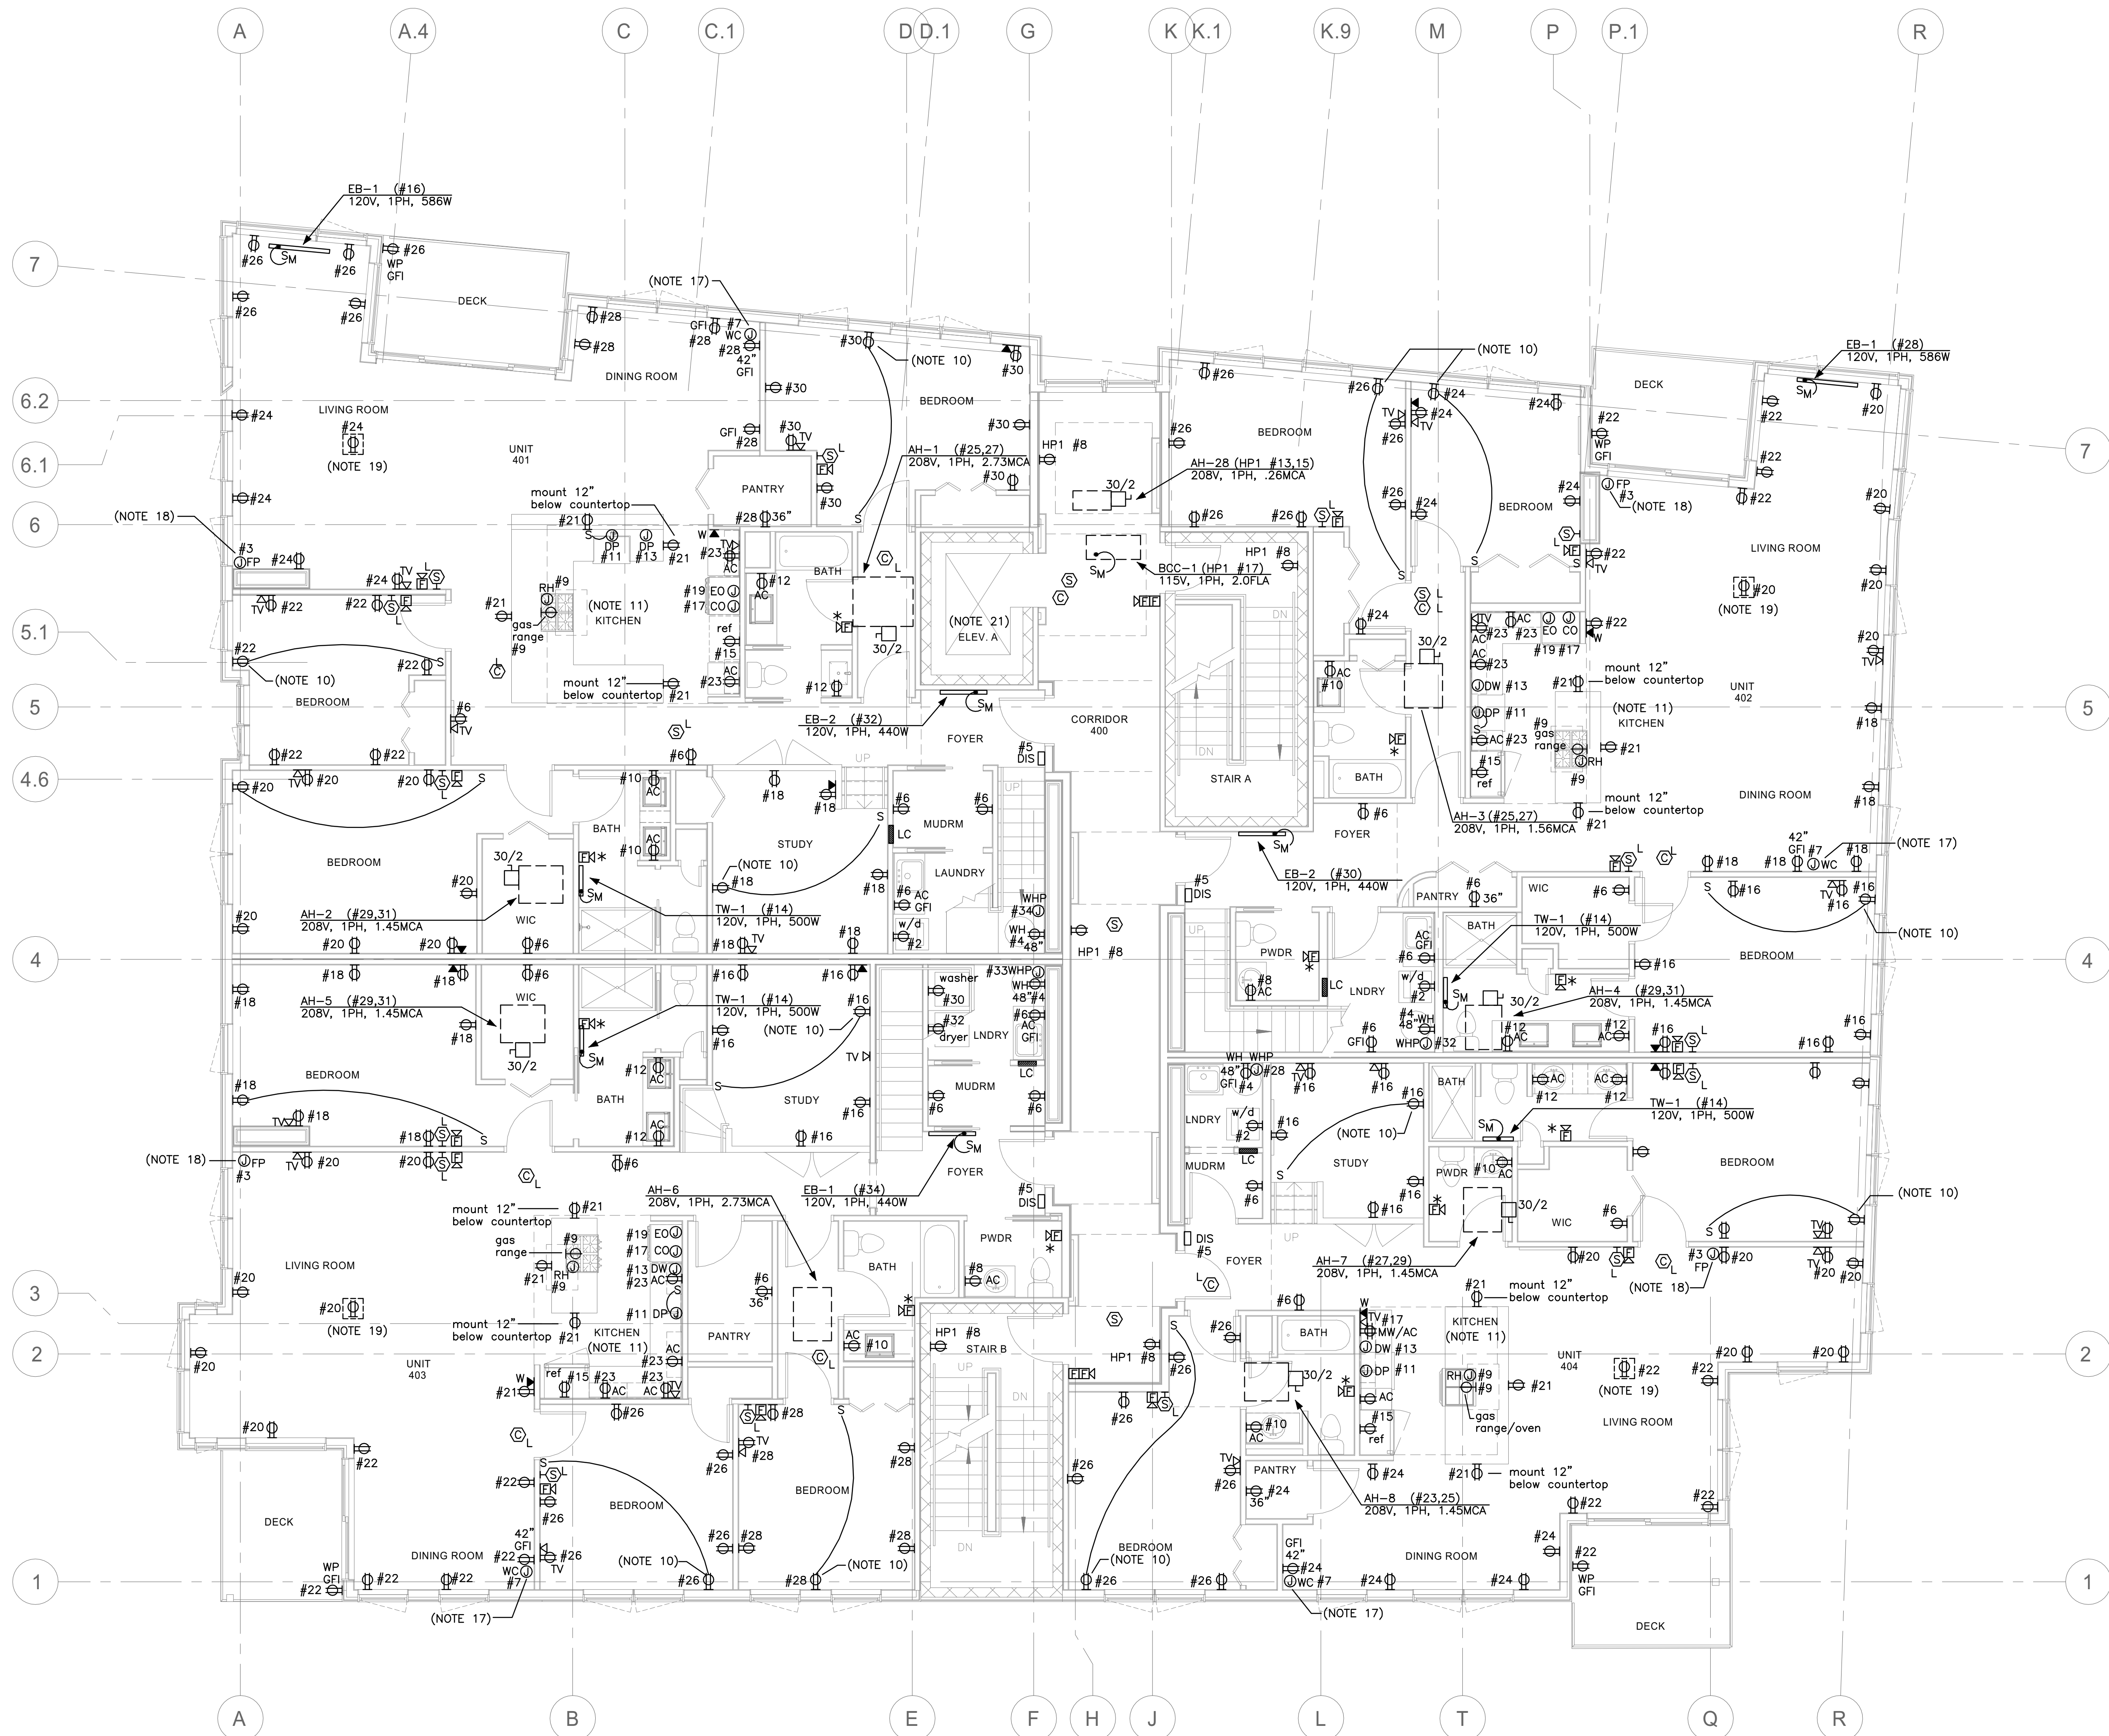

Prepared For:
118 on Munjoy Hill, LLC
118 Congress Street
Portland, Maine

Consultant:
Bartlett Design
LIGHTING & ELECTRICAL ENGINEERING
118 Congress Street
Portland, Maine 04101
TEL: (207) 445-5447 FAX: (207) 445-5448

Architect:
ARCHITYPE architects
48 Union Wharf Portland, Maine 04101
(207) 772-0022 ARCHITYPE@ARCHITYPEPA.COM

Project:
118 ON MUNJOY HILL
118 CONGRESS STREET
PORTLAND, MAINE

Revisions:
01/27/14 50% Pricing Set
02/24/14 100% Construction Documents

Date: 27 JAN 2014
Scale: 3/16" = 1'-0"
FOURTH FLOOR ELECTRICAL PLAN

E1.04