
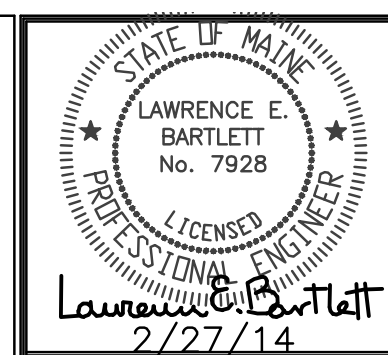


Date: 05/16/14

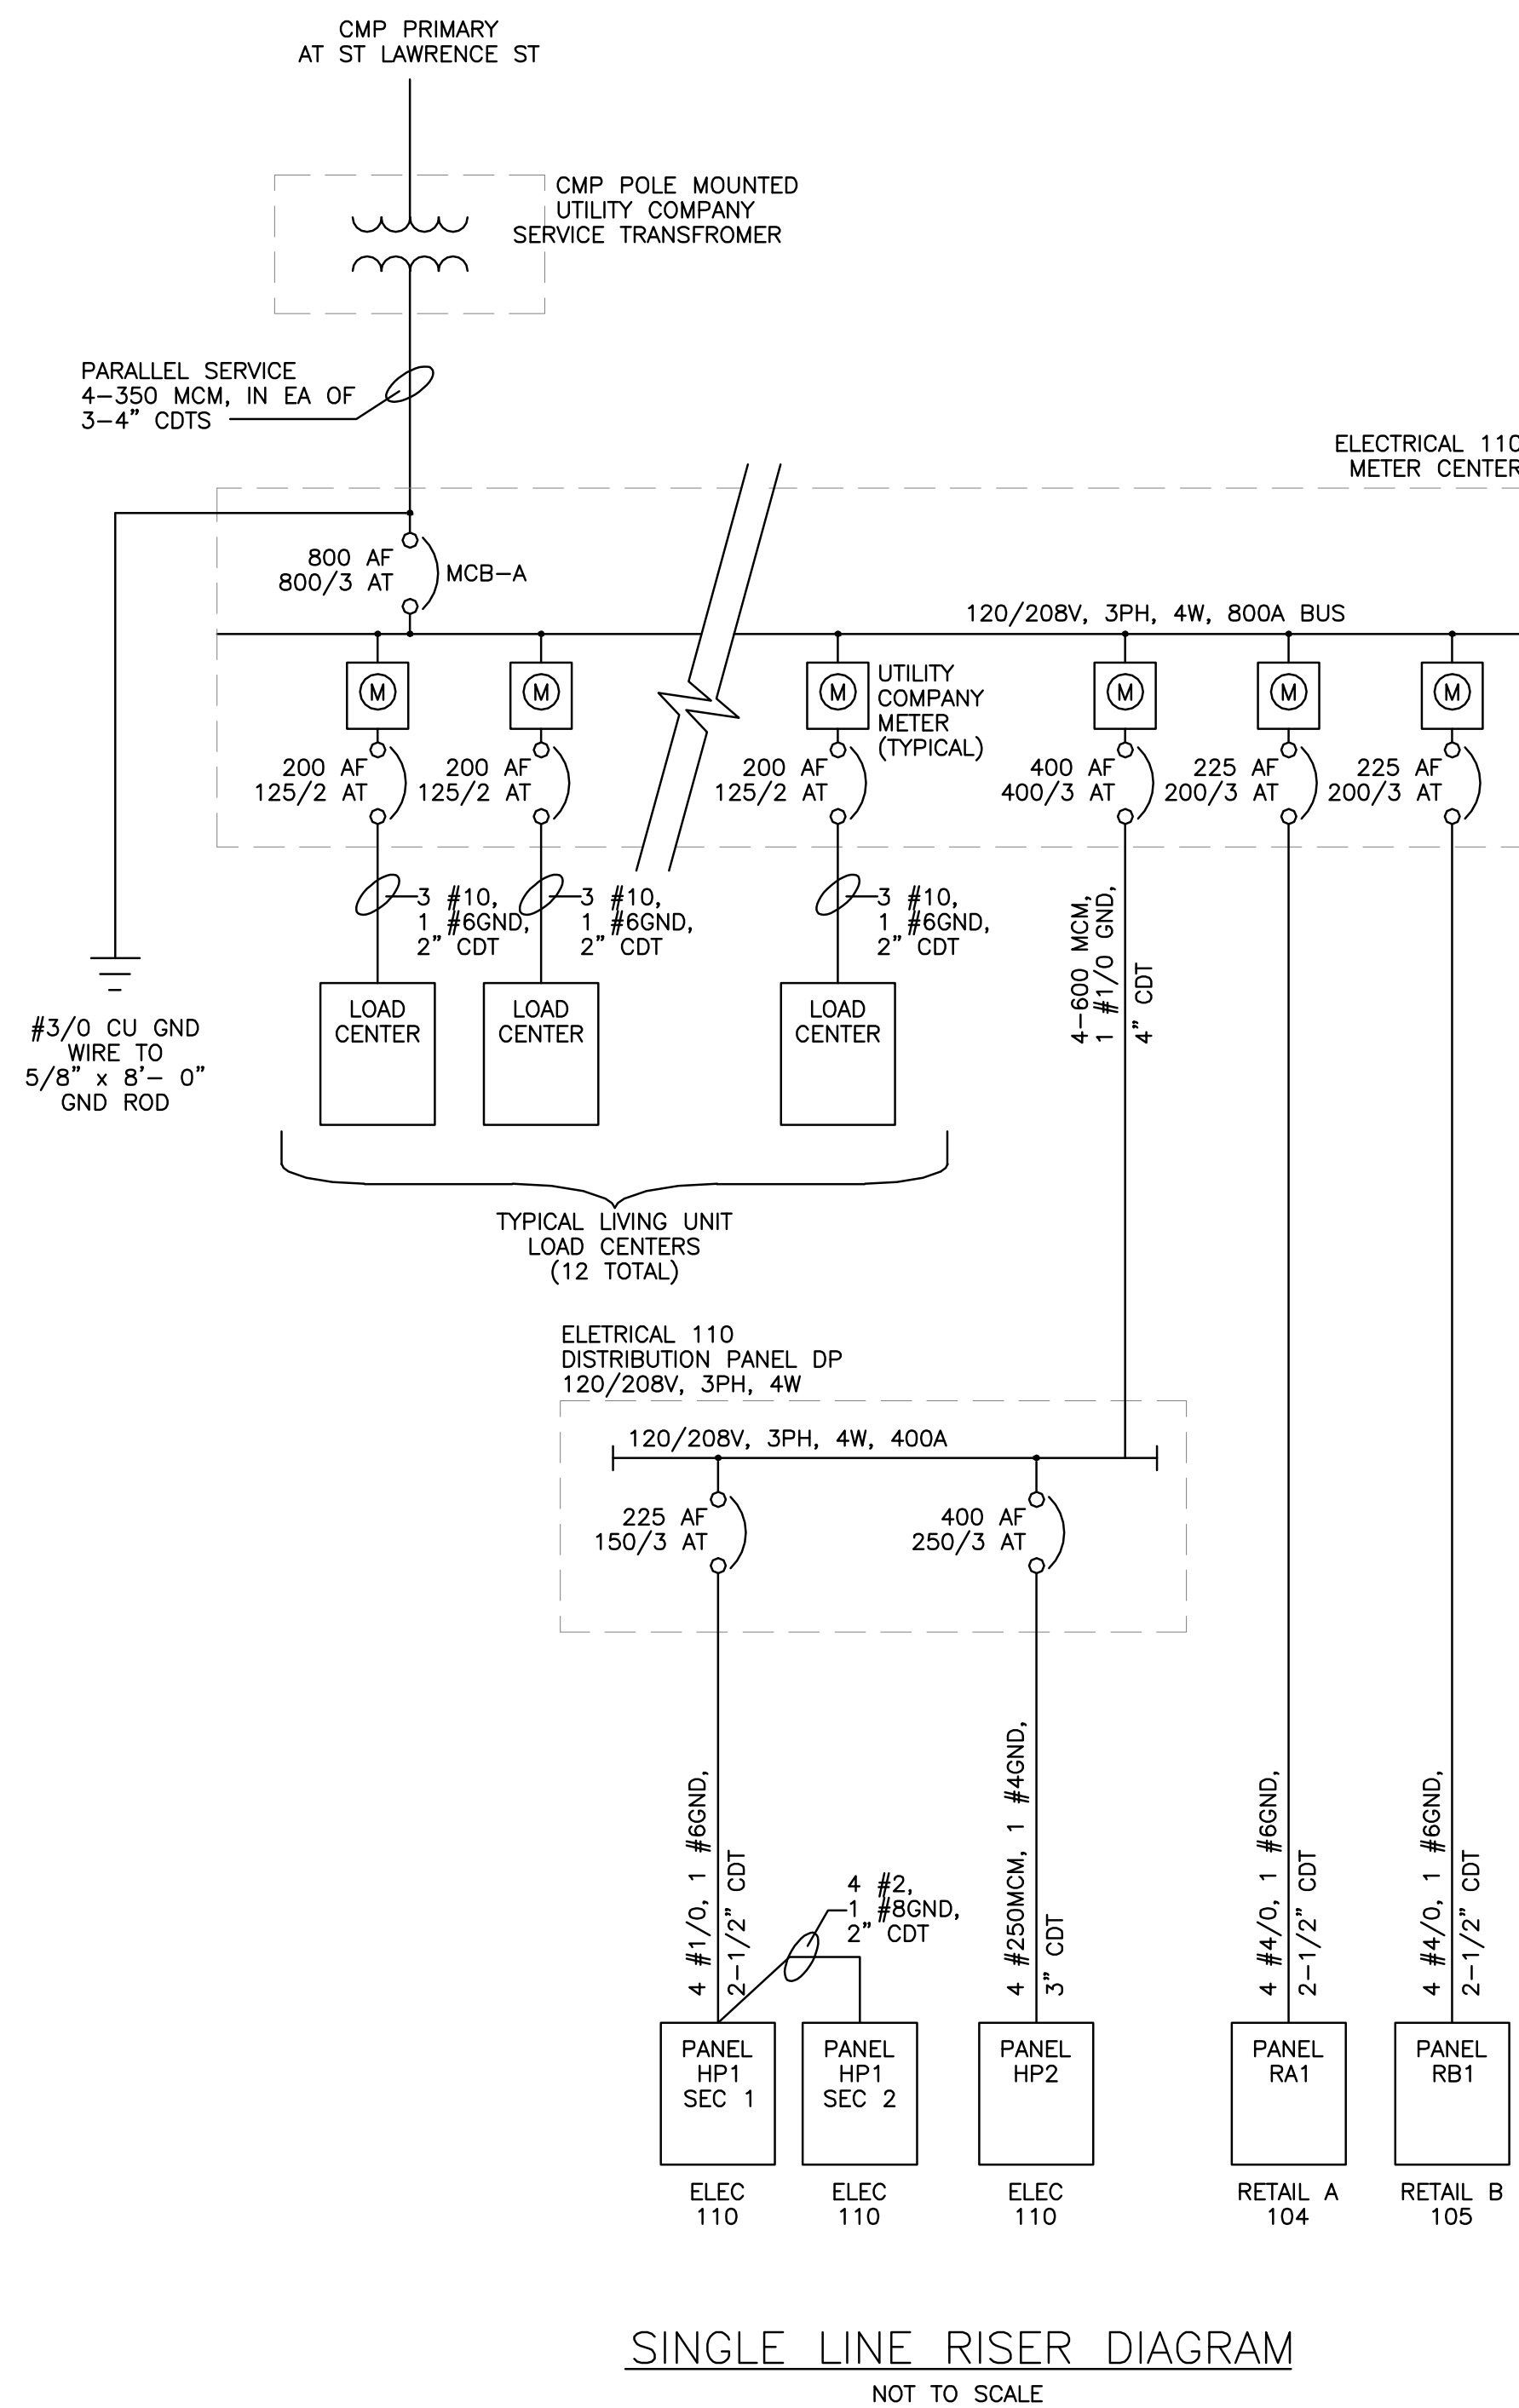

Prepared For:  
118 on Munjoy  
Hill, LLC

---

118 Congress Street  
Portland, Maine

Consultant:

**Bartlett Design**  
LIGHTING & ELECTRICAL ENGINEERING  
942 WASHINGTON STREET, BATH, ME 04530  
TEL (207) 443-5447 FAX (207) 443-5560

Architect:

**ARCHETYPE**  
**a**rchitects

48 Union Wharf Portland, Maine 04101  
(207) 772-6022 ARCHETYPE@ARCHETYPEPA.COM

Project:  
118 ON MUNJOY  
HILL  
118 CONGRESS STREET  
PORTLAND, MAINE

Revisions:	
01/27/14	50% Pricing Set
02/24/14	100% Construction Documents

Date: 27 JAN 2014	Scale: 3/16" = 1'-0"
<b>ROOF ELECTRICAL / LIGHTING PLAN &amp; SINGLE LINE DIAGRAM</b>	

## E1.05