



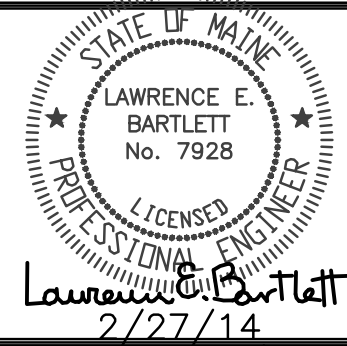

Reviewed for Code Compliance
Inspection Division
Approved with Conditions

Date: 05/16/14

CONGRESS STREET

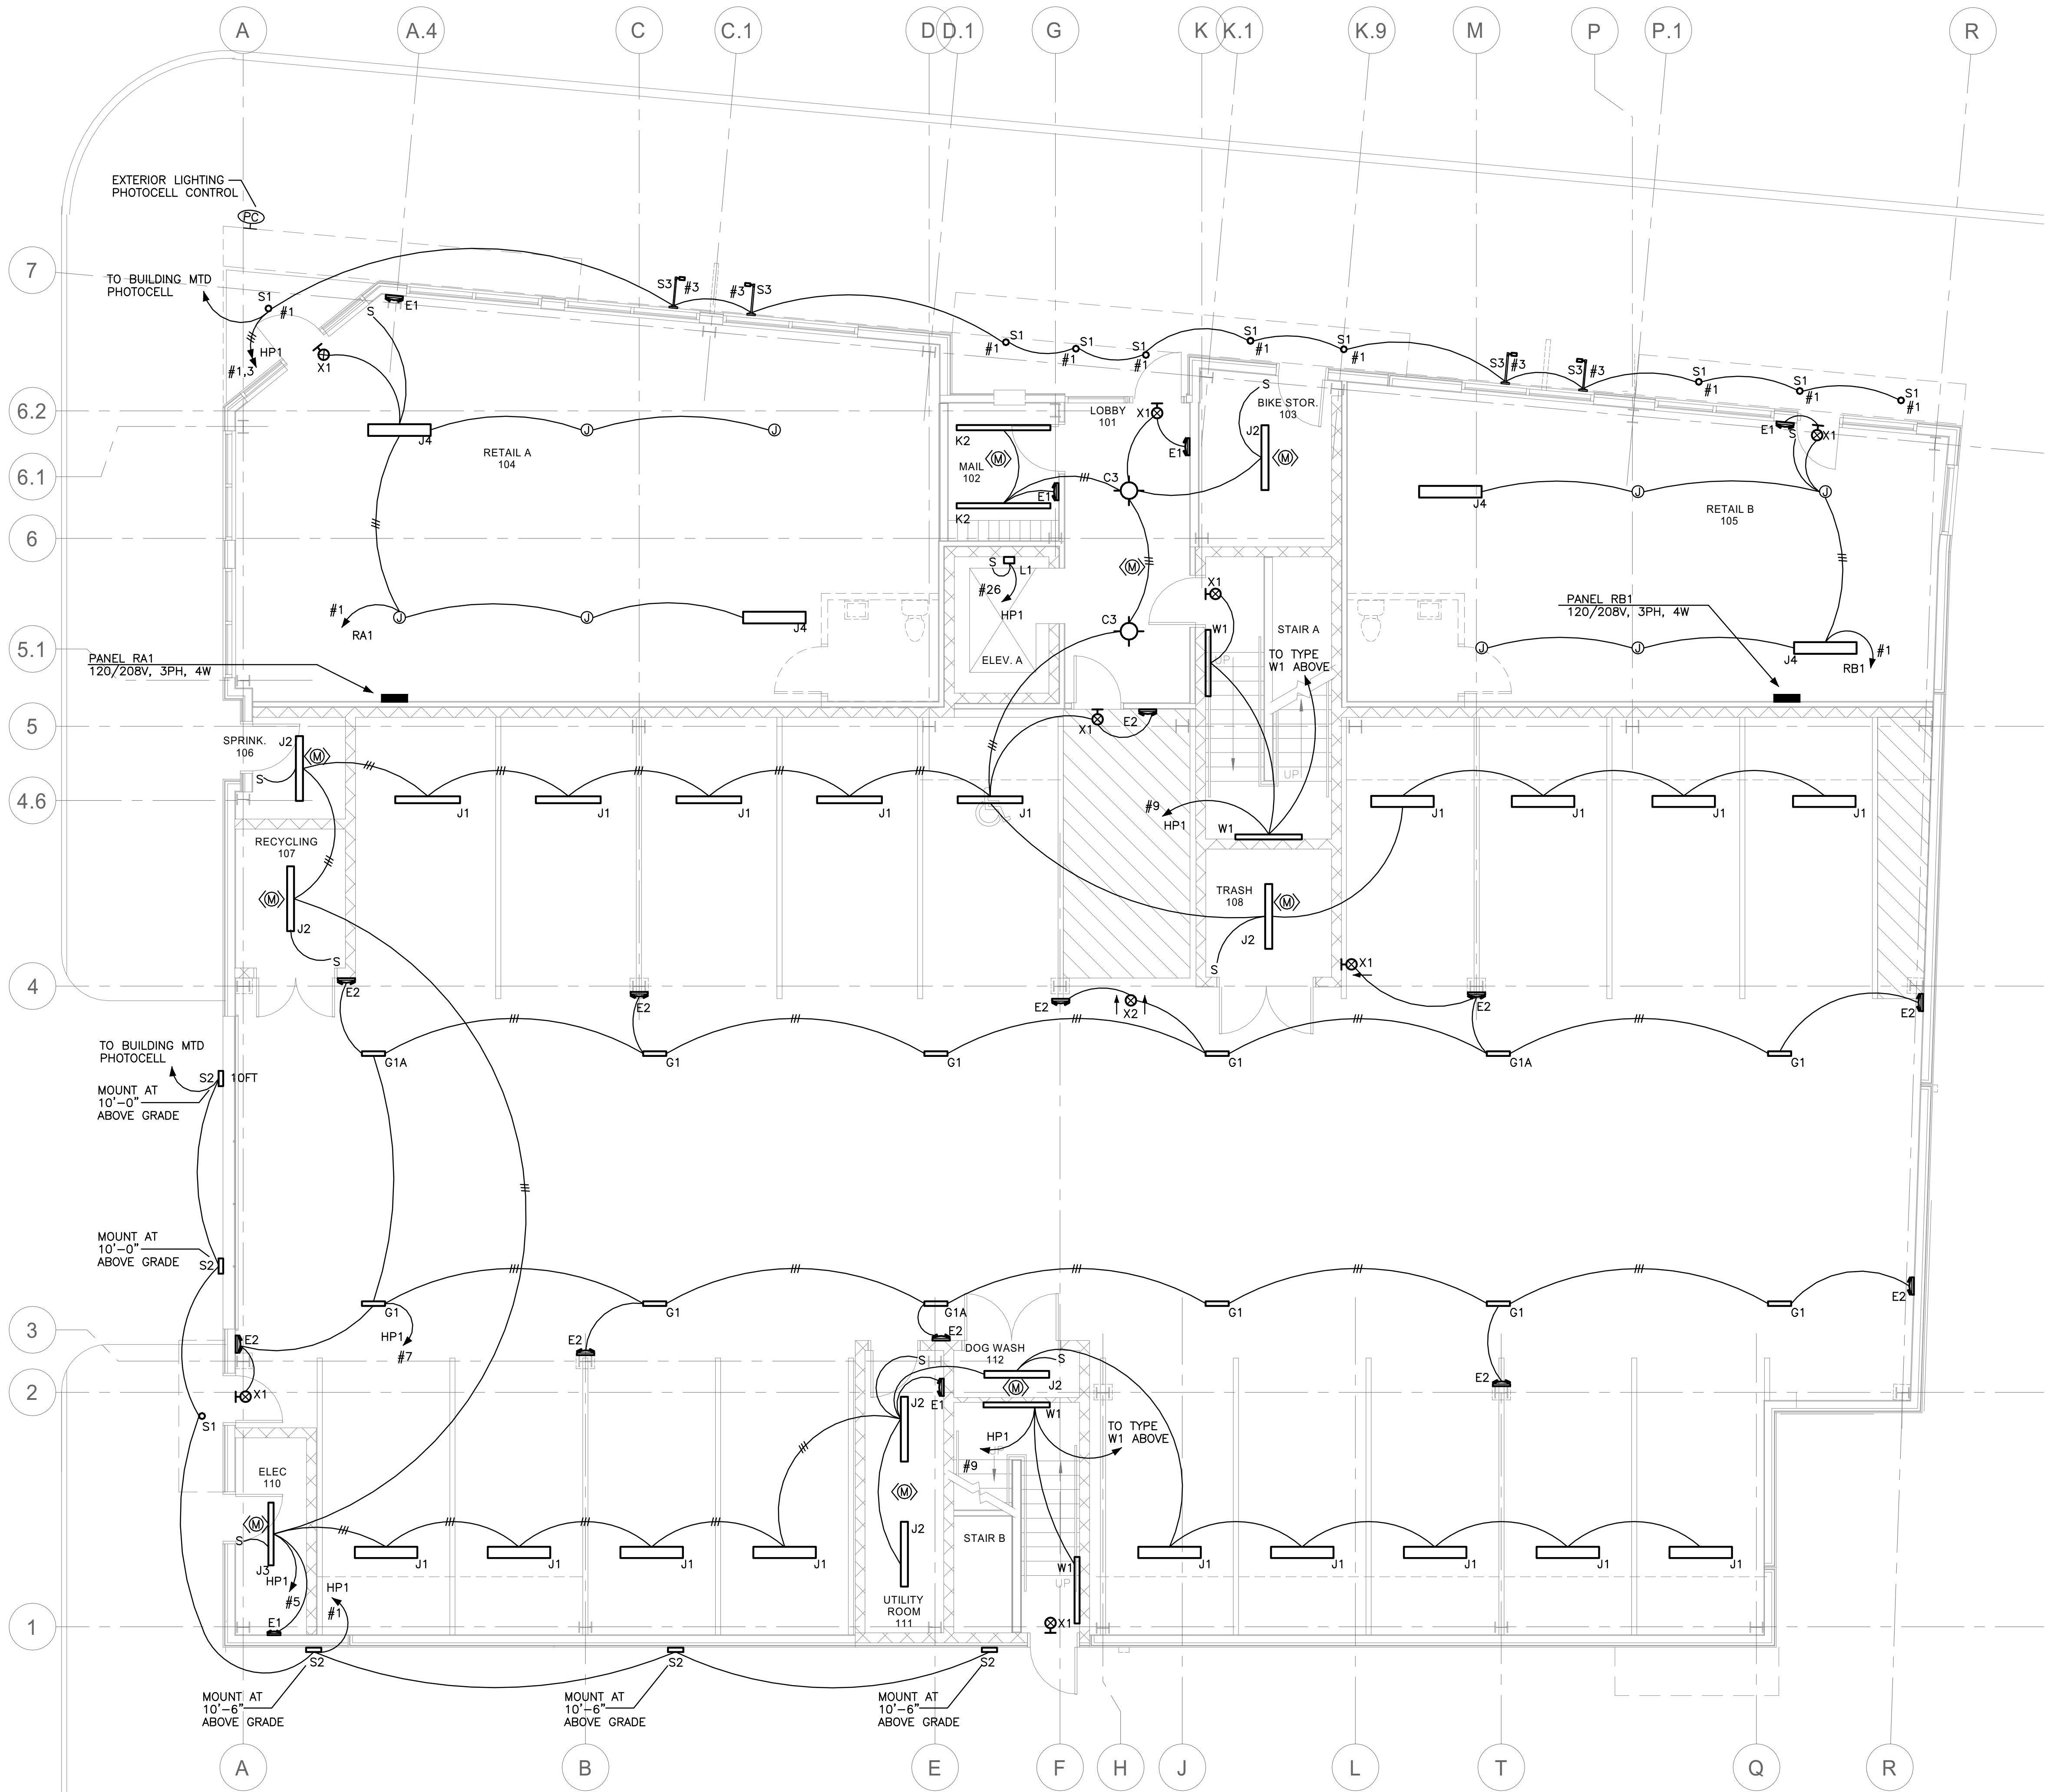

Prepared For:
118 on Munjoy Hill, LLC
118 Congress Street
Portland, Maine

Consultant:
Bartlett Design
LIGHTING & ELECTRICAL ENGINEERING
118 Congress Street
Portland, Maine 04101
TEL: (207) 445-5447 FAX: (207) 445-5500

Architect:
ARCHETYPE architects
48 Union Wharf Portland, Maine 04101
(207) 772-6022 ARCHETYPE@ARCHETYPEPA.COM

Project:
118 ON MUNJOY HILL
118 CONGRESS STREET
PORTLAND, MAINE

Revisions:
01/27/14 50% Pricing Set
02/24/14 100% Construction Documents

Date:
27 JAN 2014
Scale:
3/16" = 1'-0"
GROUND FLOOR LIGHTING PLAN

E2.01