



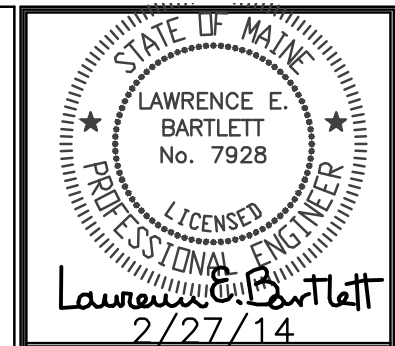

Reviewed for Code Compliance  
Inspection Division  
Approved with Conditions  
Date: 05/16/14

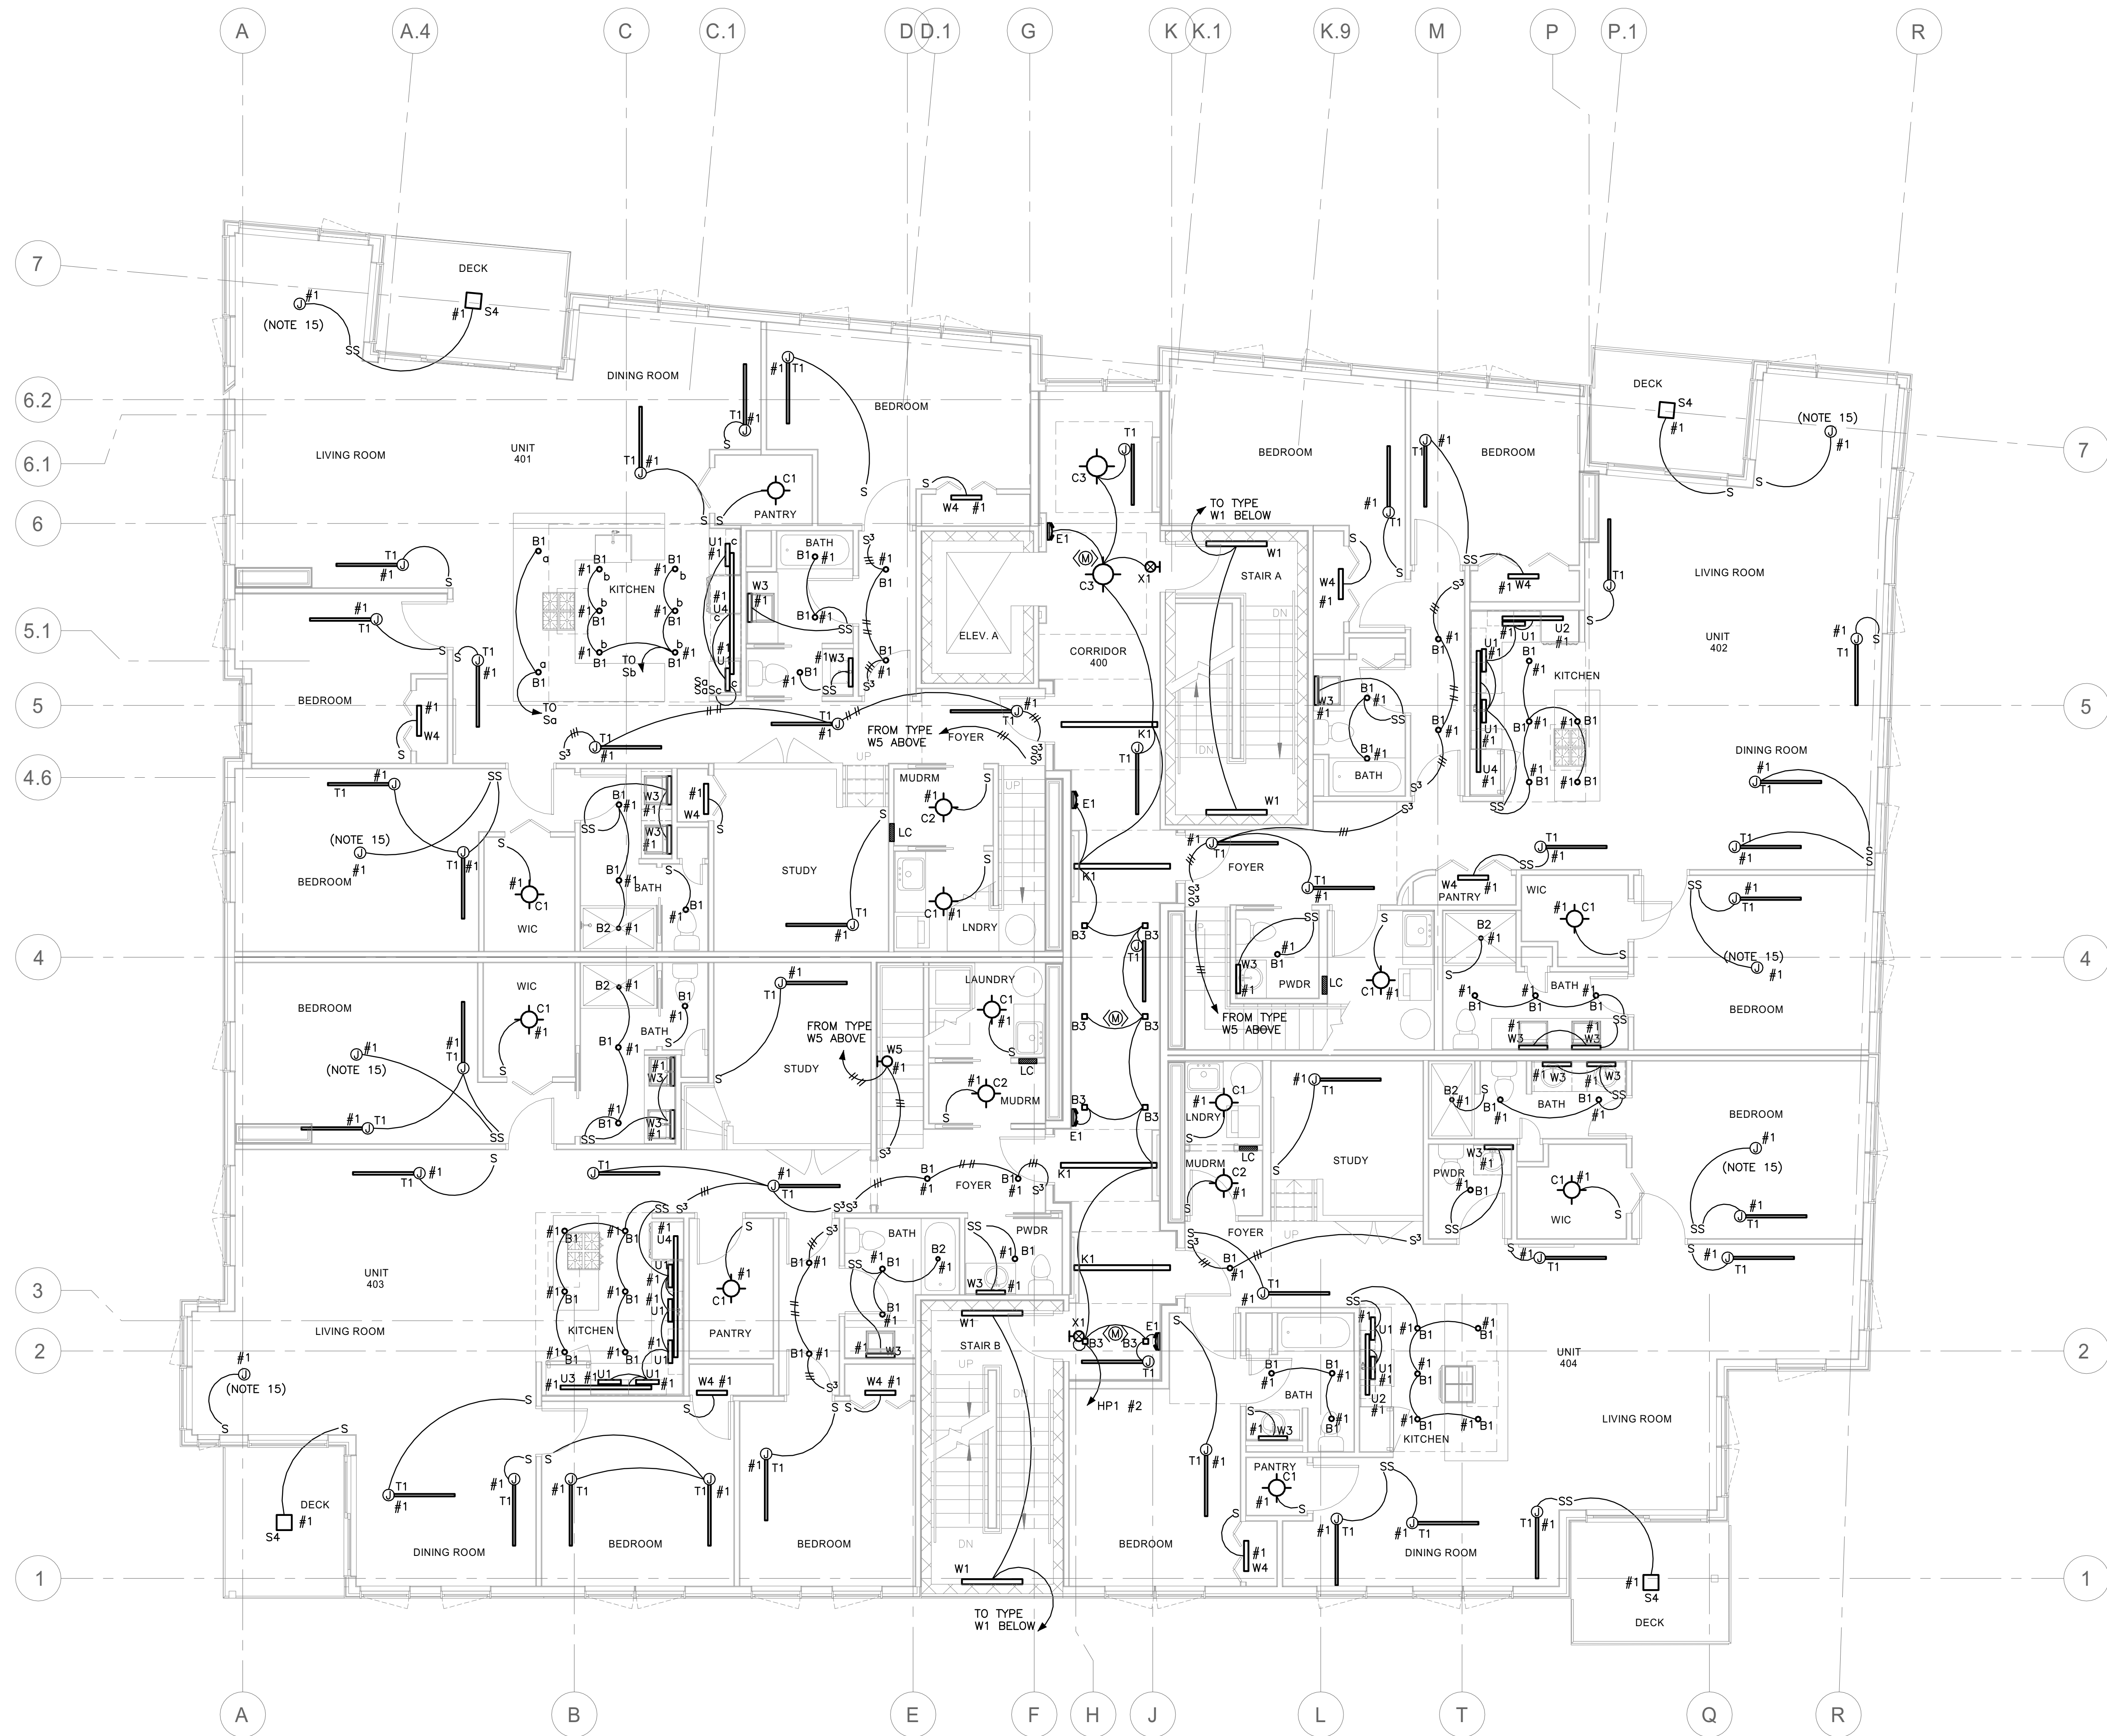

Prepared For:  
**118 on Munjoy Hill, LLC**  
118 Congress Street  
Portland, Maine

Consultant:  
**Bartlett Design**  
LIGHTING & ELECTRICAL ENGINEERING  
118 Congress Street  
Portland, Maine 04101  
TEL: (207) 445-3447 FAX: (207) 445-3447

Architect:  
**ARCHETYPE architects**  
48 Union Wharf Portland, Maine 04101  
(207) 772-6022 ARCHETYPE@ARCHETYPEPA.COM

Project:  
**118 ON MUNJOY HILL**  
118 CONGRESS STREET  
PORTLAND, MAINE

Revisions:  
01/27/14 50% Pricing Set  
02/24/14 100% Construction Documents

Date: 27 JAN 2014  
Scale: 3/16" = 1'-0"  
**FOURTH FLOOR LIGHTING PLAN**

**E2.04**