
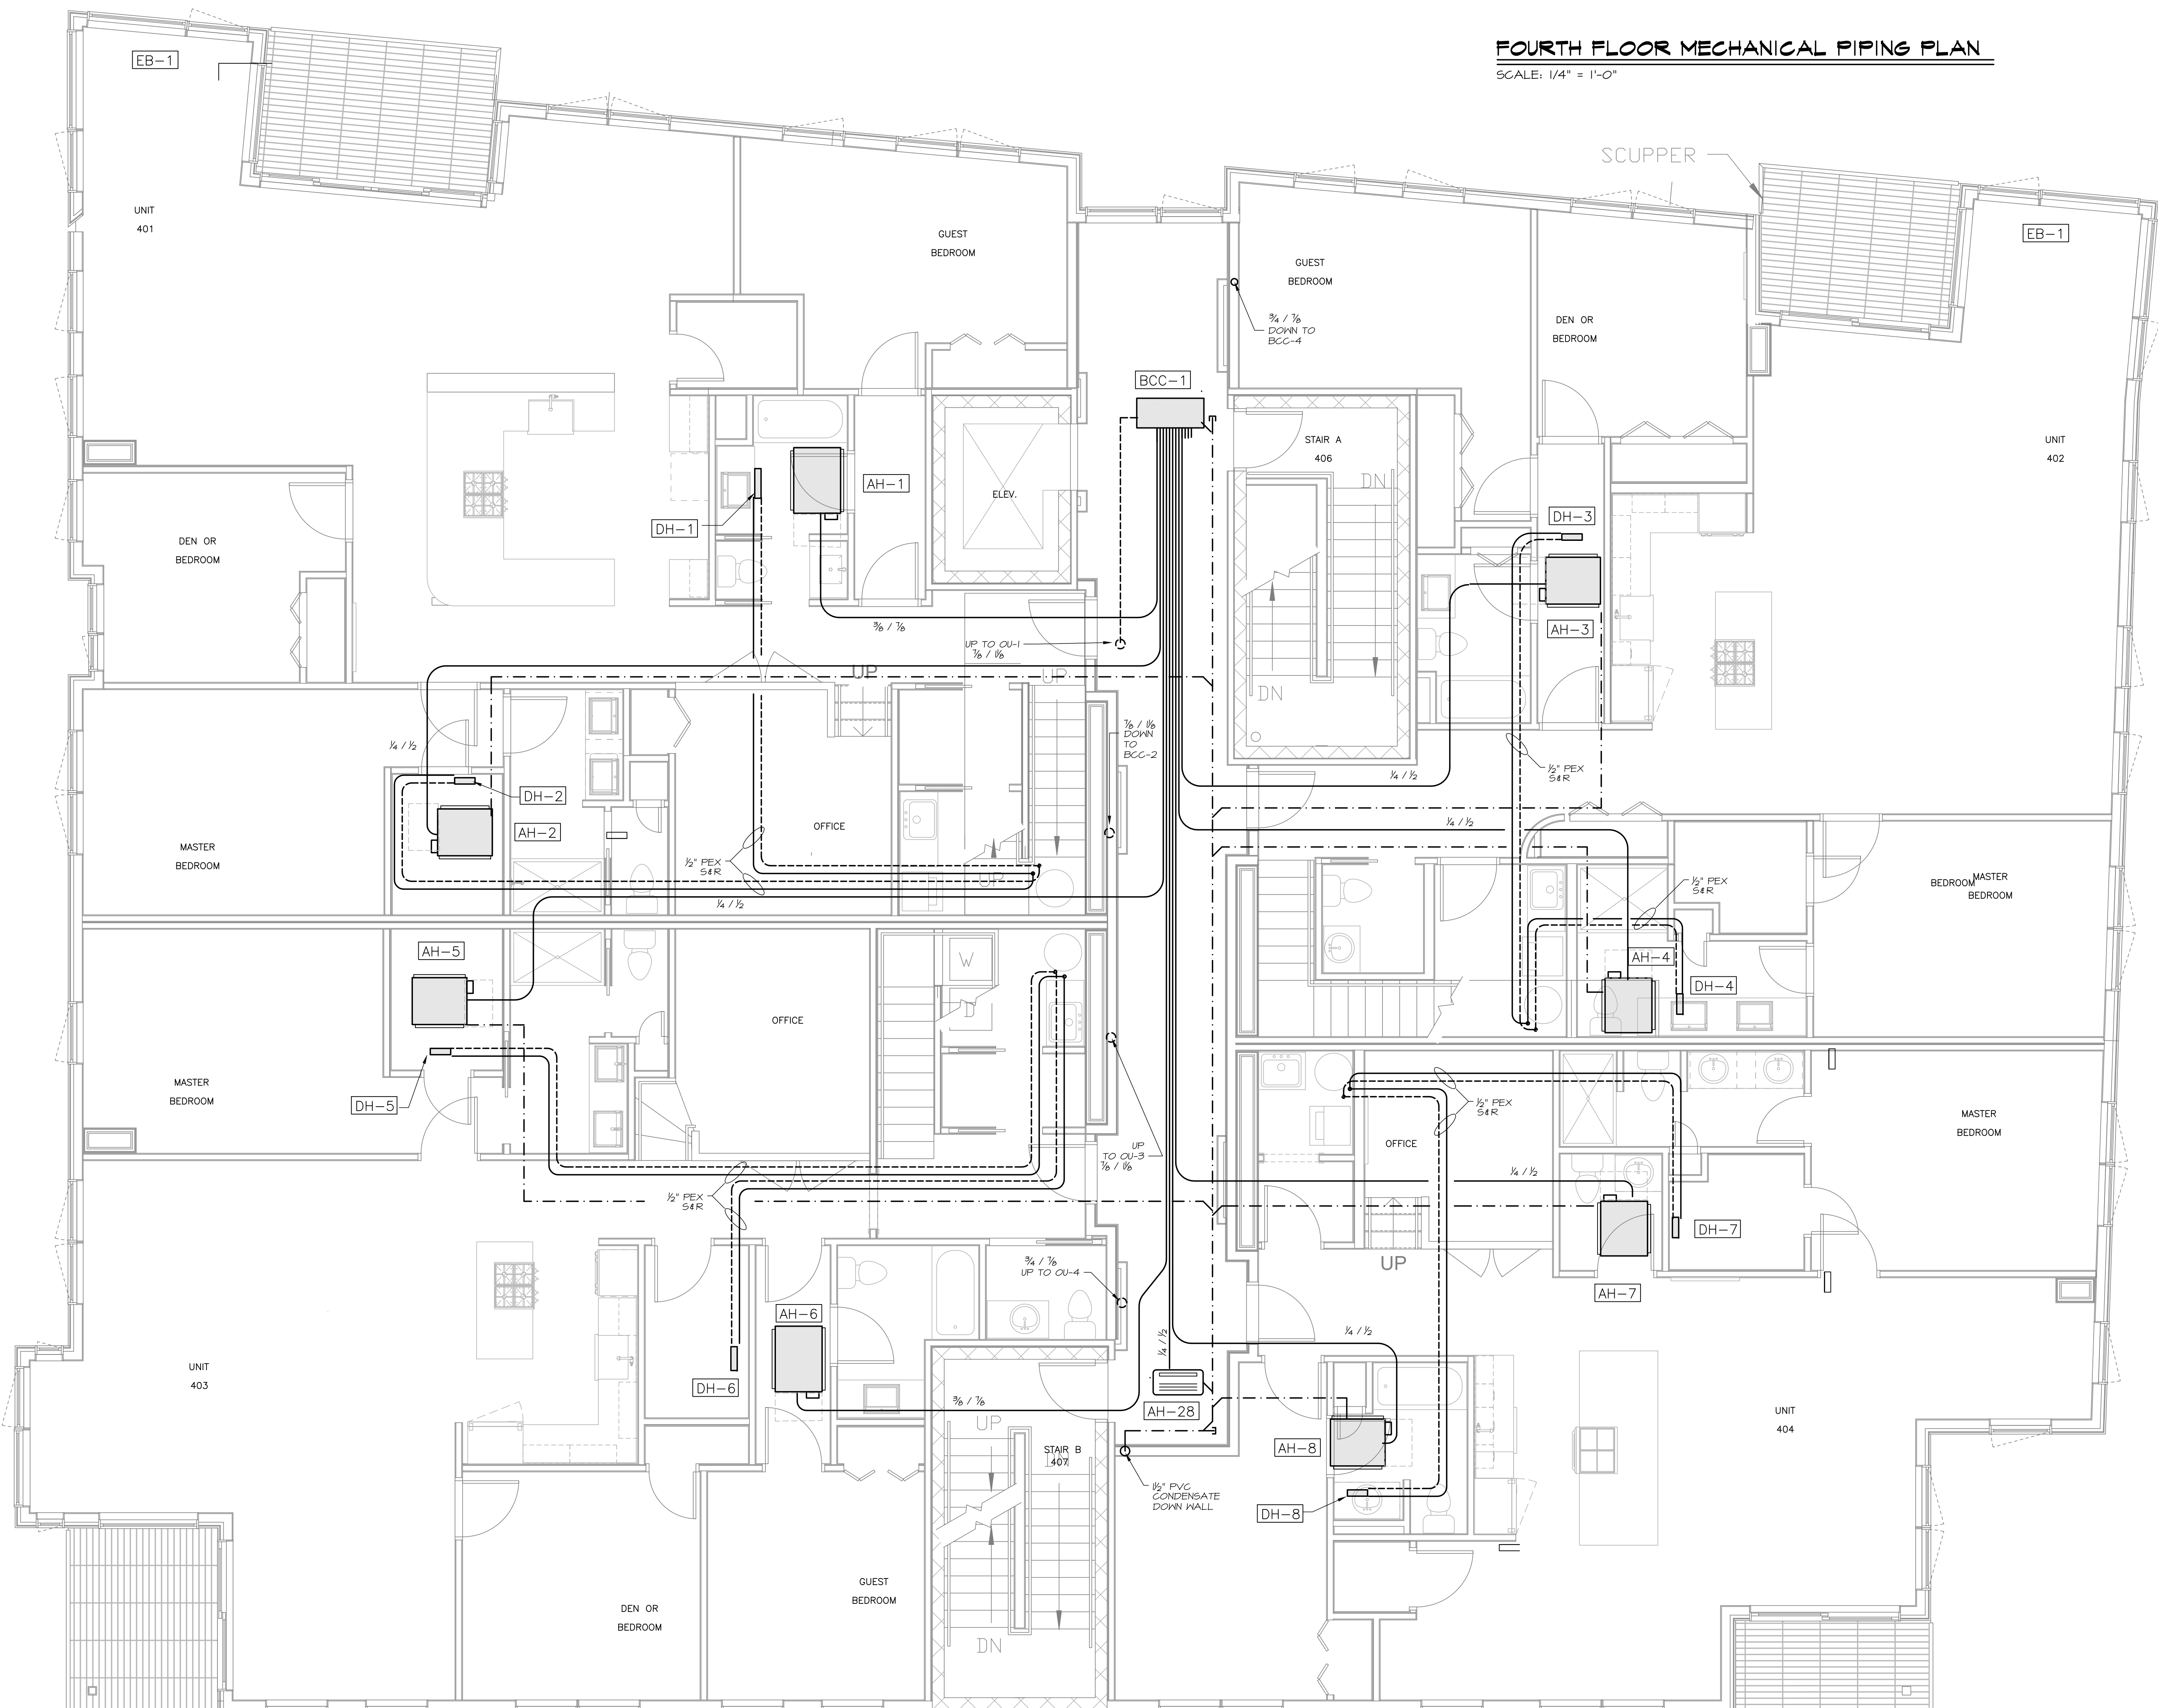
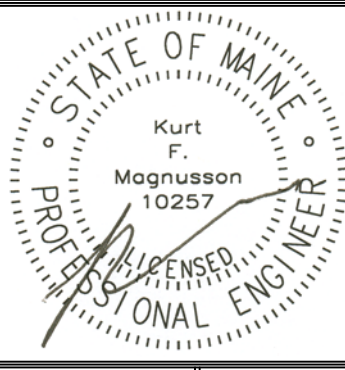


**FOURTH FLOOR MECHANICAL PIPING PLAN**  
SCALE: 1/4" = 1'-0"

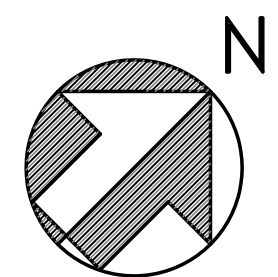

Prepared For:  
**118 on Munjoy Hill, LLC**  
118 CONGRESS STREET  
PORTLAND, ME 04101

Consulting Engineer:  
**Mechanical Systems Engineers**  
10 FOREST HILLS DRIVE  
ROYAL FALLEN CENTER UNIT #10  
ROYAL FALLEN, ME 04961  
TEL: (207) 886-1441  
FAX: (207) 886-1441  
© copyright 2014

Architect:  
**ARCHETYPE architects**  
48 Union Wharf Portland, Maine 04101  
(207) 772-6022 Fax (207) 772-4056

Project:  
**118 ON MUNJOY HILL**  
118 CONGRESS STREET  
PORTLAND, MAINE

Revisions:  
**100% CONSTRUCTION DOCUMENTS**

Date: 24 FEB 2014  
Scale: 1/4" = 1'-0"  
**FOURTH FLOOR PIPING PLAN**

**M9**  
MSE PROJECT 1332