



CONGRESS STREET

ST. LAWRENCE STREET

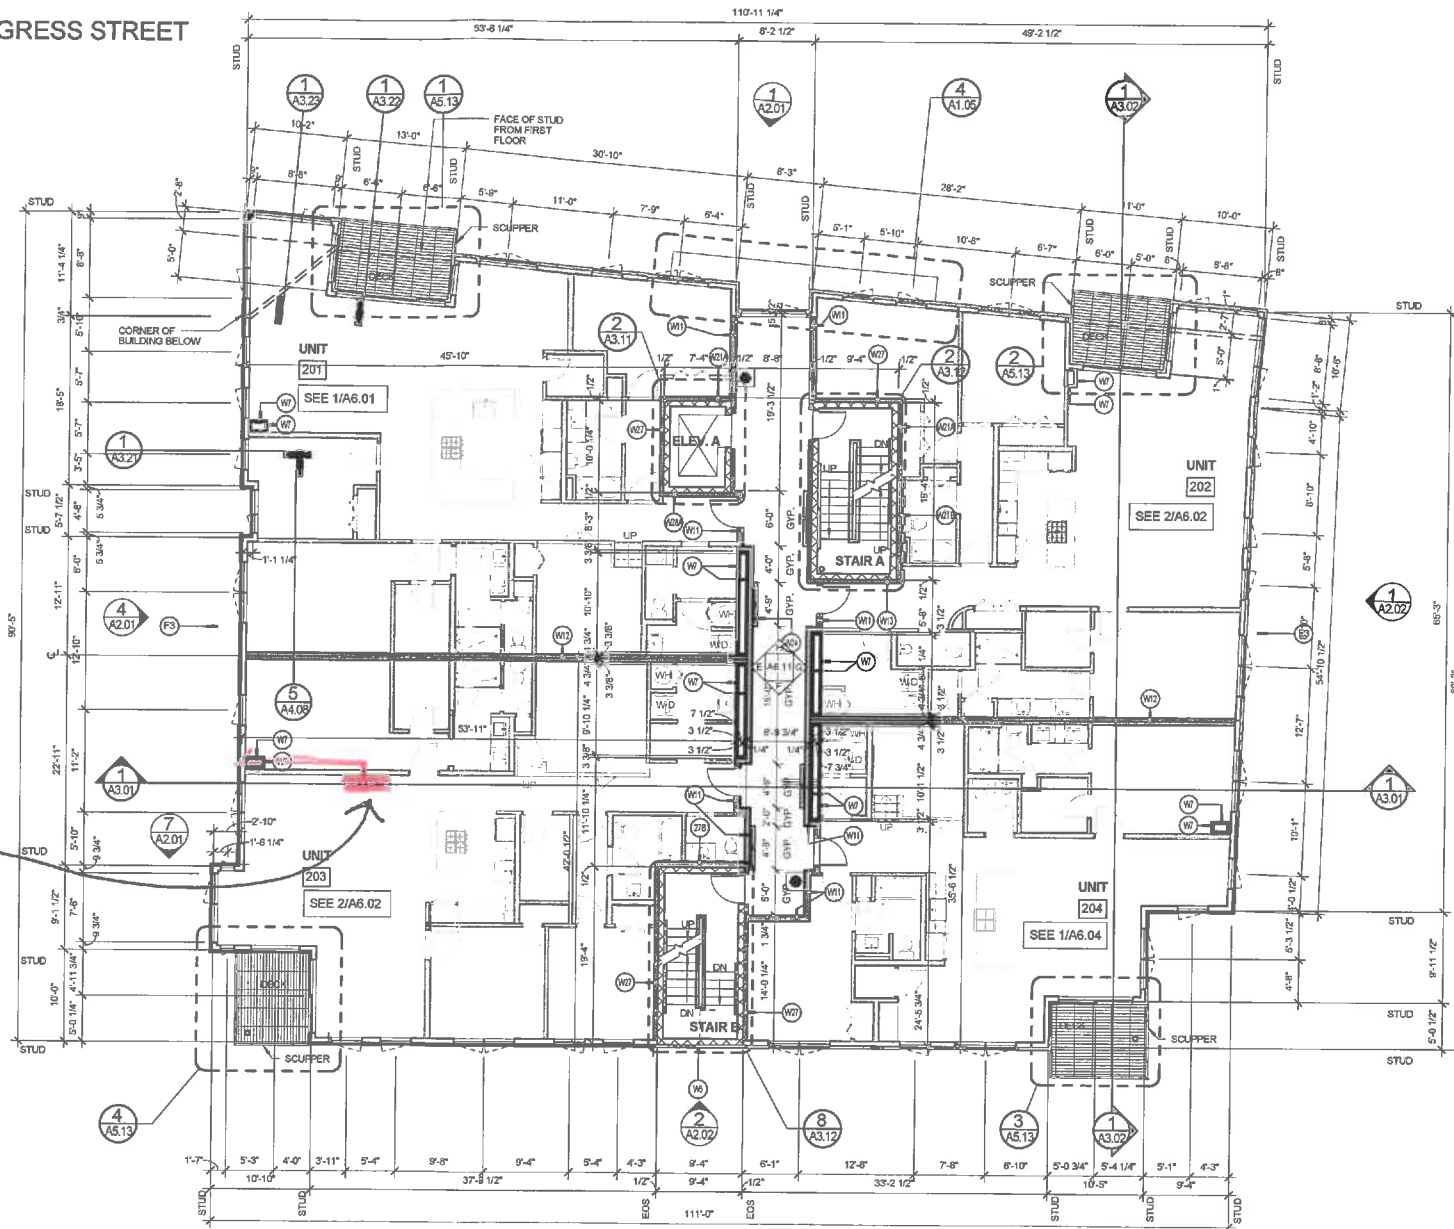

Location of proposed gas fireplace

1 SECOND FLOOR PLAN  
1/8" = 1'-0"

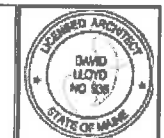

Prepared For:  
**118 on Munjoy Hill, LLC**  
118 CONGRESS STREET  
PORTLAND, ME 04101

Consultant:  
**ARCHETYPE Architects**  
48 Union Wharf Portland, Maine 04101  
(207) 772-5022 Fax (207) 772-4056

Project:  
**118 ON MUNJOY HILL**  
118 CONGRESS STREET  
PORTLAND, MAINE

Revisions:

Date: 11 MAR 2014  
Scale: 1/8" = 1'-0"  
**SECOND FLOOR PLAN**

**A1.02**

Project address 118 Congress st unit 203