


ELECTRICAL & PHOTOMETRIC SITE PLAN NOTES:

1. CALCULATED VALUES REPRESENT MAINTAINED FOOTCANDLE LEVELS AT GRADE.
2. LIGHTING CALCULATIONS WERE PERFORMED USING A 0.9 LIGHT LOSS FACTOR.
3. MOUNTING HEIGHTS FOR TYPE S2 LIGHTS ARE LISTED ON THE PHOTOMETRIC PLAN. THE TYPE S1 LIGHTS SHALL BE RECESSED INTO CANOPY CEILINGS.
4. MAXIMUM FOOTCANDLE LEVEL WAS CALCULATED TO BE 3.6.
5. TYPE S1:
RECESSED LED DOWNLIGHT WITH NARROW BEAM SYMMETRICAL LIGHT DISTRIBUTION, CLEAR TEMPERED GLASS LENS, DIE-CAST ALUMINUM STEP BAFFLE AND INTERNAL ALUMINUM REFLECTOR. FIXTURE UTILIZES A 6.5W LED LAMP WITH AN INTEGRAL 120V DRIVER. COLOR TEMP 3K. UL LISTED FOR WET LOCATION. FIXTURE FINISH: BRUSHED STAINLESS STEEL.
BEGA LIGHTING #6604 LED
- TYPE S2
WALL MOUNTED DIE-CAST ALUMINUM FIXTURE WITH TEMPERED ETCHED GLASS LENS AND ALUMINUM REFLECTOR. FIXTURE UTILIZES A 12W LED LAMP WITH AN INTEGRAL 120V ELECTRONIC DRIVER. COLOR TEMP 3K. UL LISTED FOR WET LOCATIONS. FIXTURE FINISH: WHITE.
BEGA LIGHTING #2380 LED WHT
- TYPE S3
24IN LONG WALL MOUNTED STRAIGHT STEM 8W LED SIGN LIGHT WITH 180deg VERTICAL AND 360deg HORIZONTAL LOCKING ADJUSTMENT, FIELD CHANGEABLE OPTICAL DISTRIBUTION AND INTEGRAL TRANSFORMER LOCATED IN FIXTURE CANOPY. PROVIDE FIXTURE WITH MEDIUM FLOOD DISTRIBUTION, SOFT FOCUS LENS AND 45deg CUT-OFF END CAP. COLOR TEMP 3K. UL LISTED FOR WET LOCATIONS. FIXTURE FINISH: WHITE.
B-K LIGHTING #SN LED e22 MFL A9 WHT 12 A 24 C PC

SCALE: NOT TO SCALE

NOTES


5

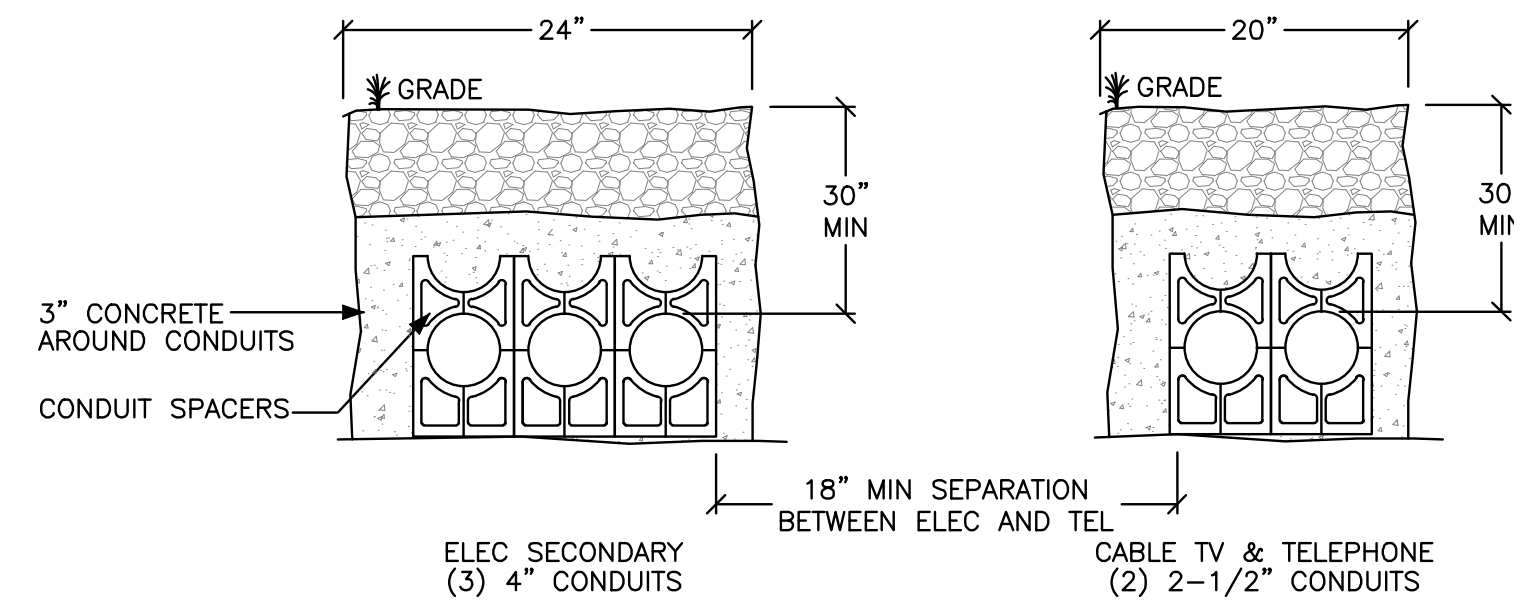

SCALE: NOT TO SCALE

DUCT SECTION


4

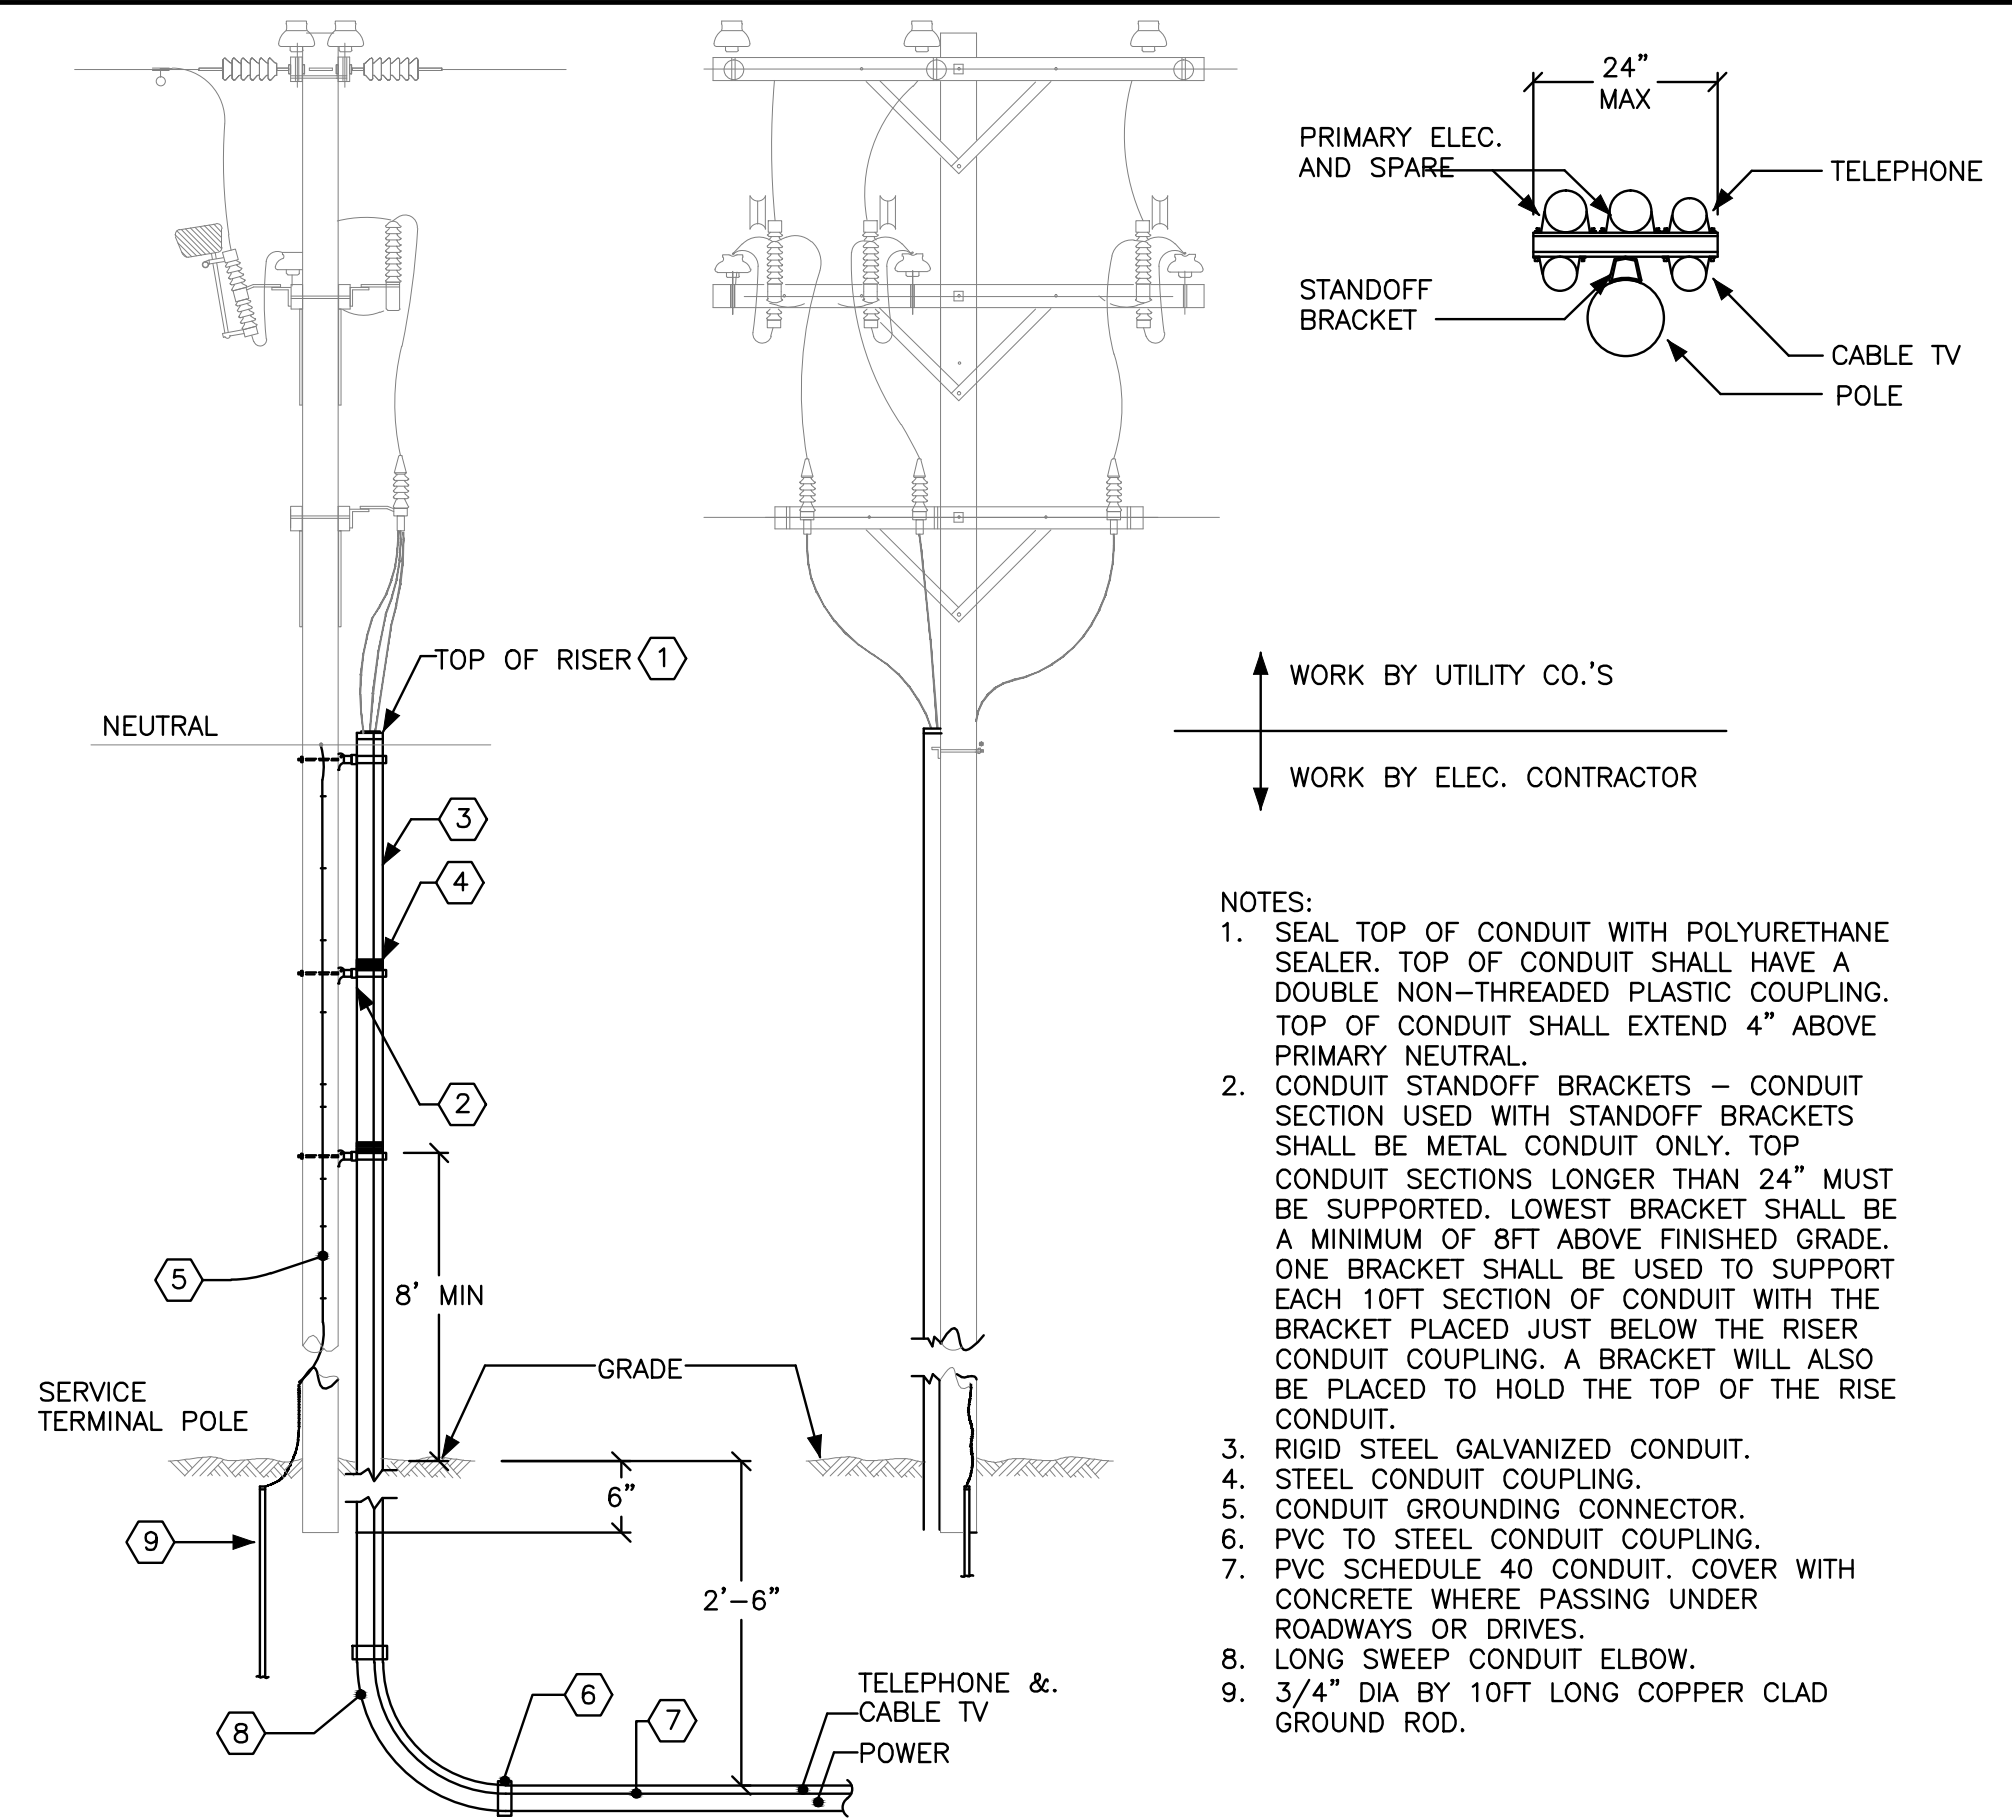

SCALE: NOT TO SCALE

SERVICE RISER POLE DETAIL


3

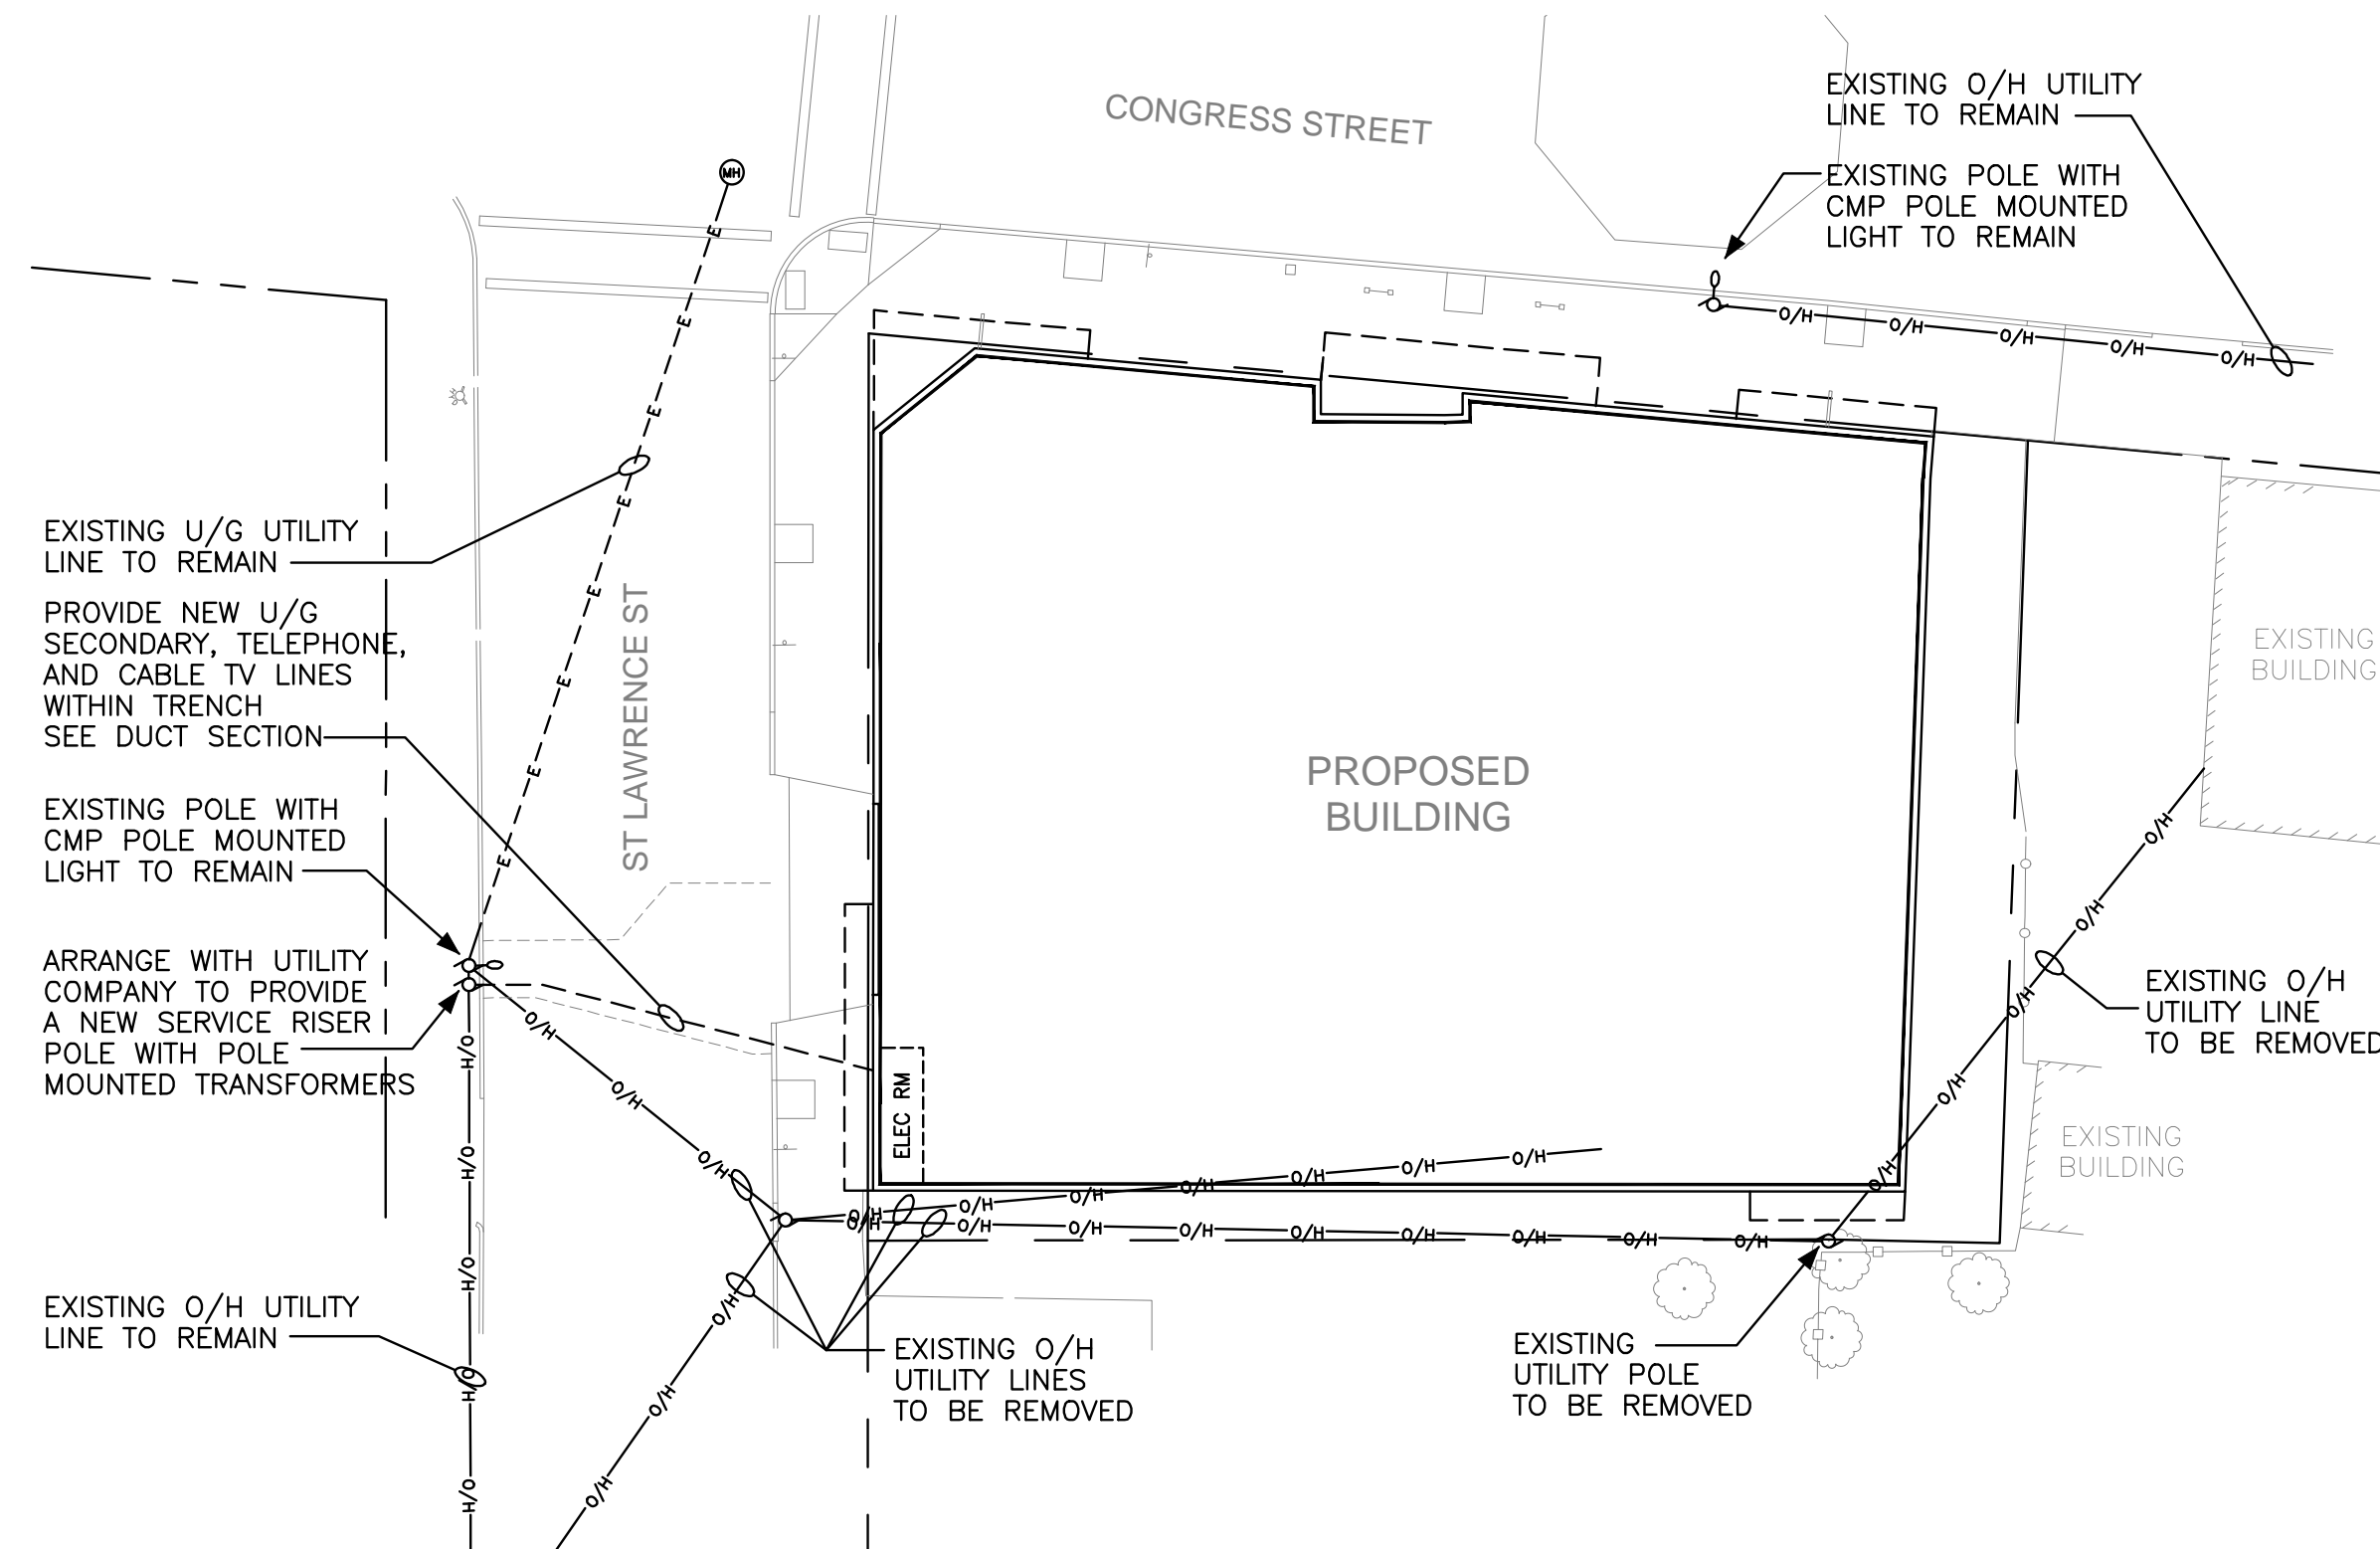

SCALE: 1" = 20'-0"

ELECTRICAL SITE PLAN


2

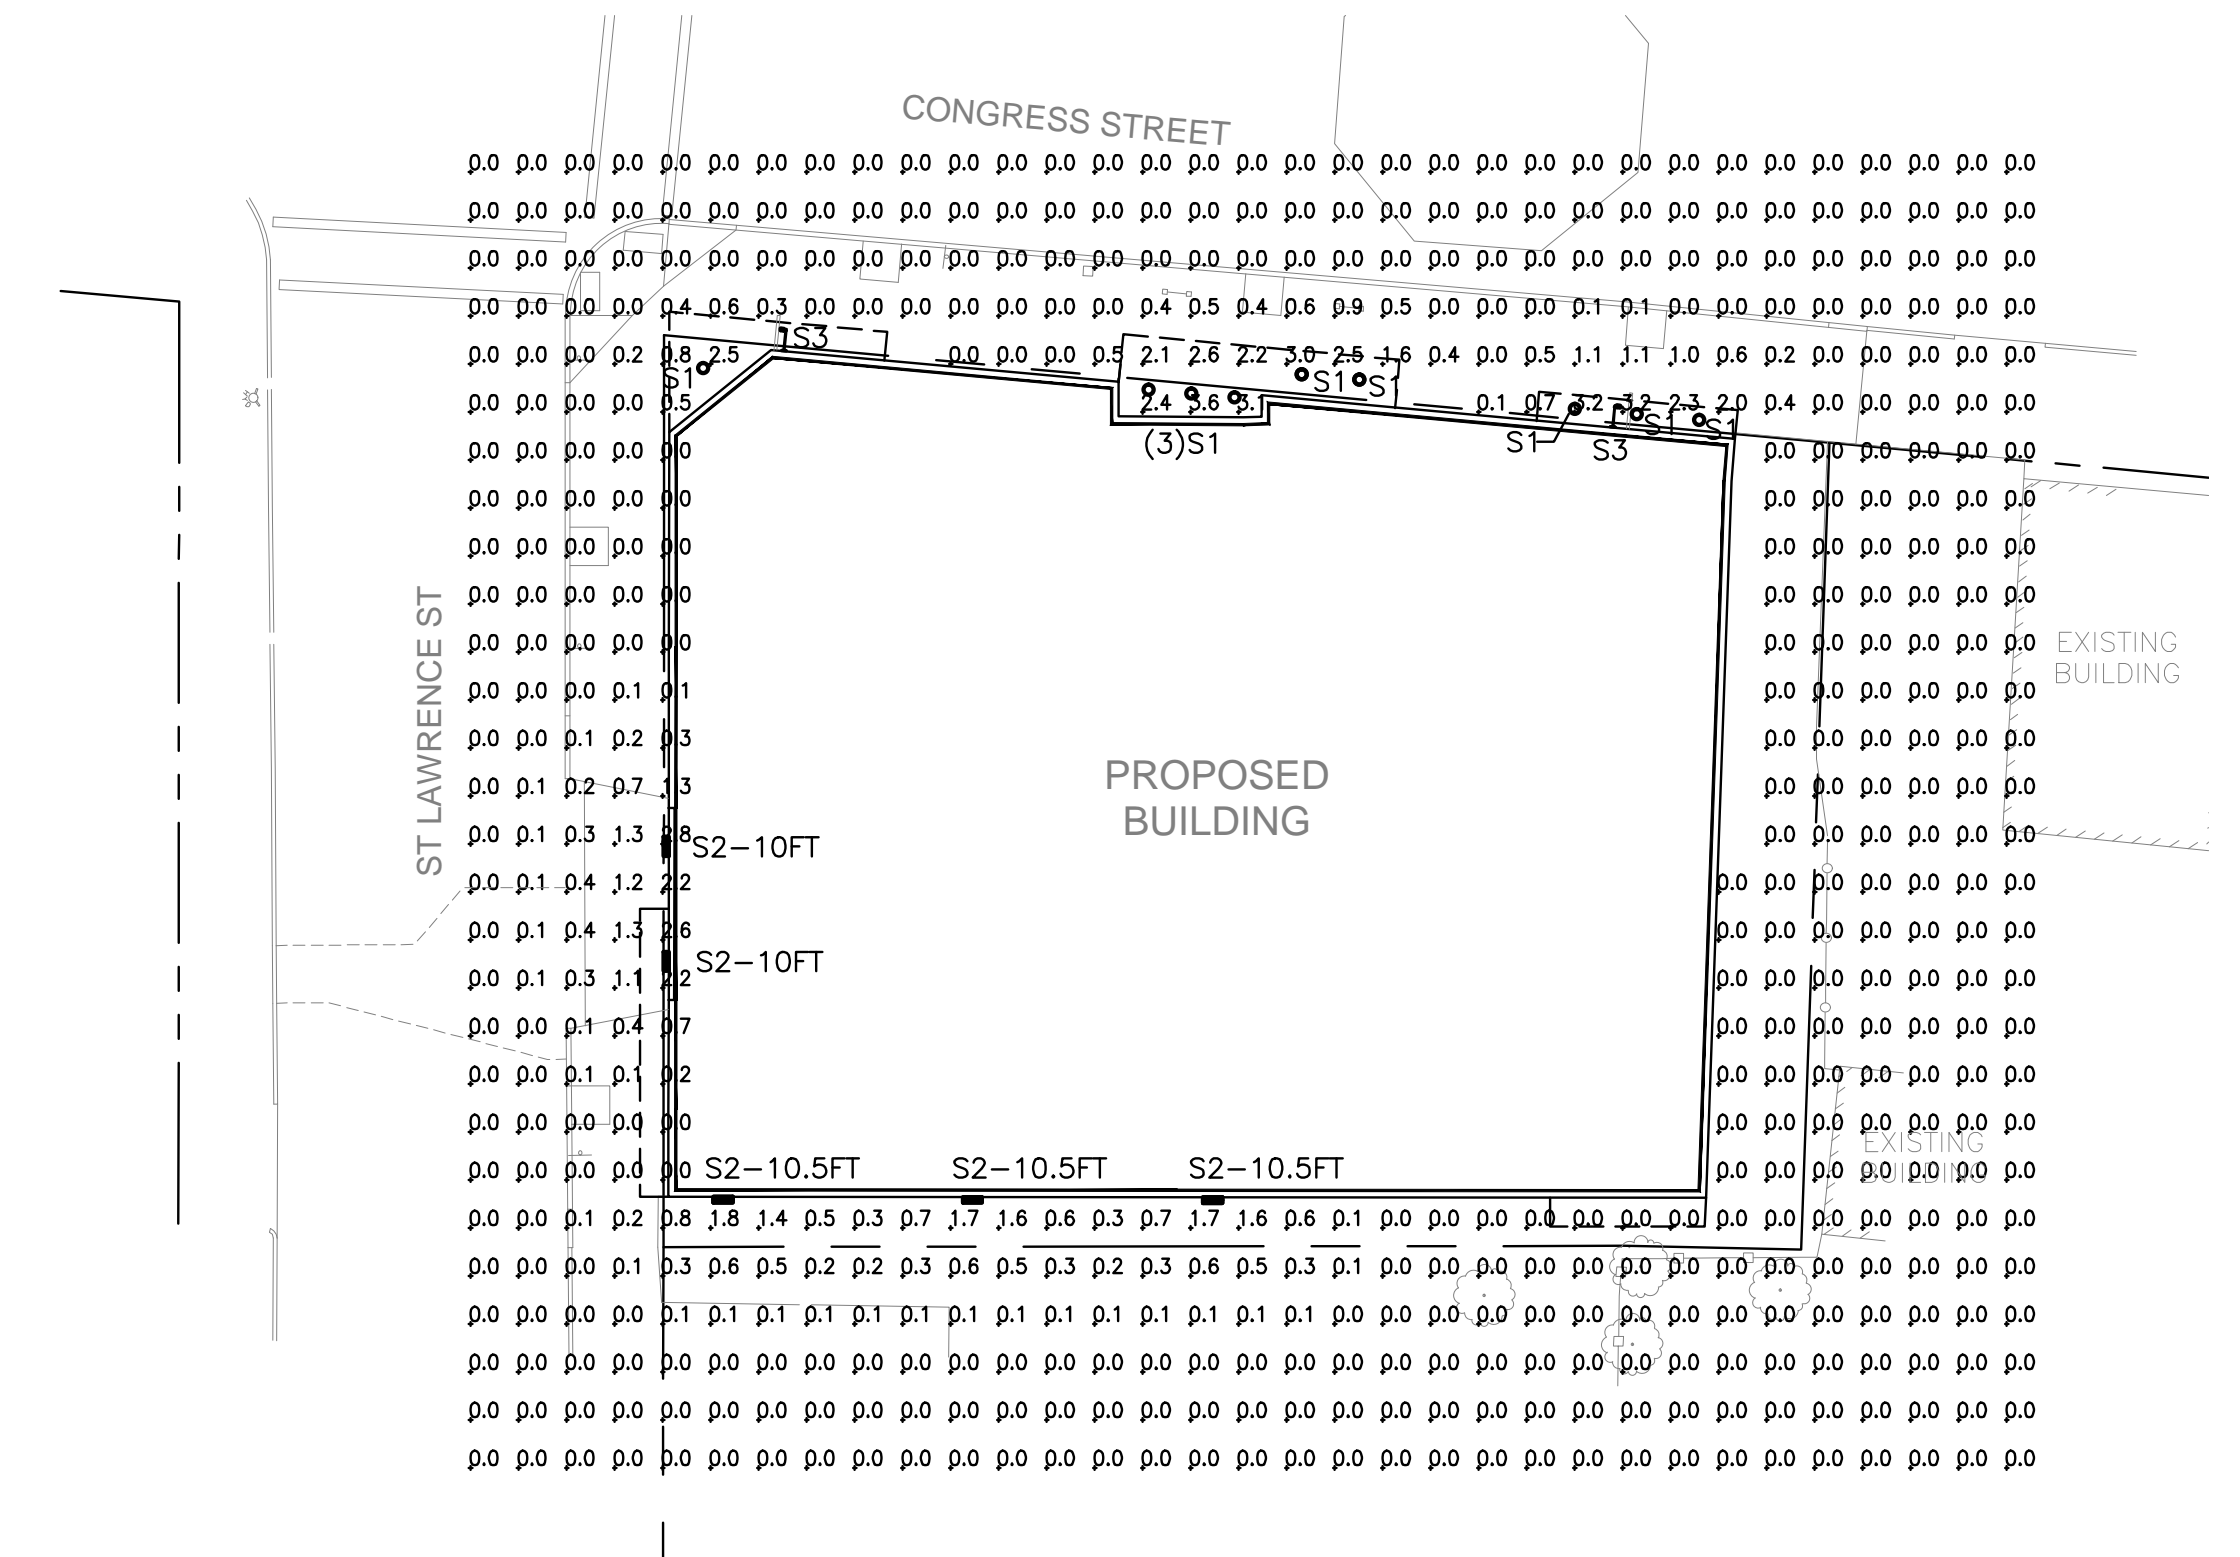

SCALE: 1" = 20'-0"

PHOTOMETRIC SITE PLAN

1

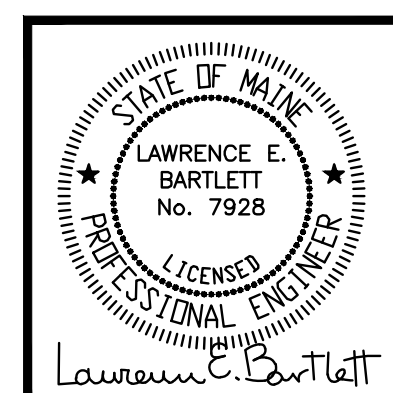

Bartlett Design
LIGHTING & ELECTRICAL ENGINEERING
942 WASHINGTON STREET, BATH, ME 04530
TEL (207) 443-6447 FAX (207) 443-6560

date drawn: 11/12/13
date issued: 11/12/13
drawn by: JLC
scale: 1" = 20'-0"

project 118 CONDOMINIUMS
CONGRESS ST, PORTLAND MAINE
ELECTRICAL & PHOTOMETRIC SITE PLAN
drawing title

project no. 13-0049
revisions:

E0.1

sheet number