


REVISION	DESCRIPTION	DATE
0	ISSUED FOR REVIEW & APPROVAL	4/21/2016

RESERVED FOR CITY STAMP

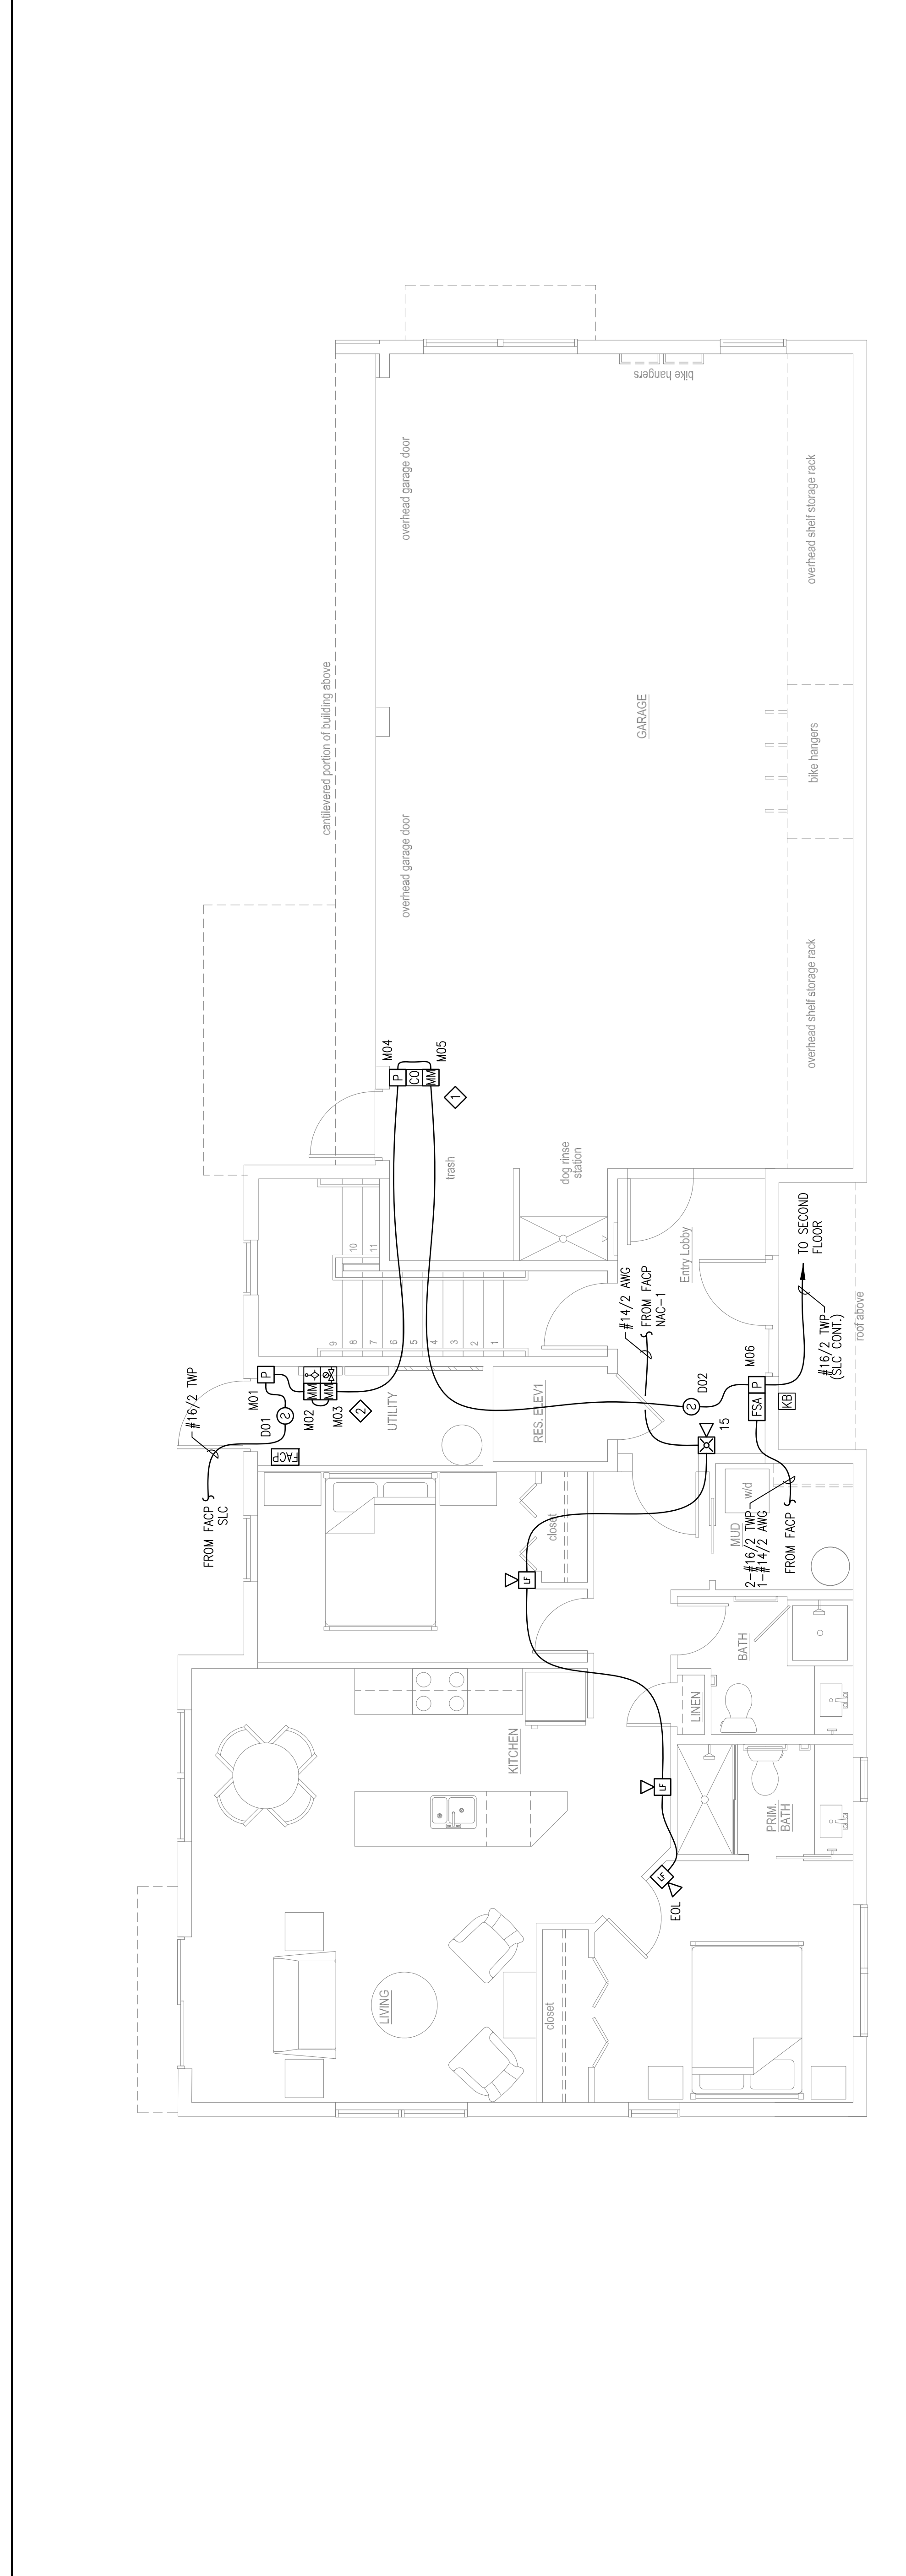

**FIRST FLOOR FIRE ALARM PLAN**  
SCALE: 1/4"=1'-0"

**SHEET NOTES:**

- ◆ ADDRESSABLE MONITOR MODULE(S) PROVIDED TO MONITOR ALL WATER FLOW, PRESSURE SWITCHES, TAMPER SWITCHES AND POST INDICATING VALVES ASSOCIATED WITH THE FIRE SPRINKLER SYSTEM. INSTALLING CONTRACTOR SHALL FIELD VERIFY EXACT MOUNTING, CIRCUITING AND PROGRAMMING REQUIREMENTS. FIELD VERIFY EXACT QUANTITY AND LOCATION(S).
- ◆ ADDRESSABLE MONITOR MODULE PROVIDED TO MONITOR THE KITCHEN HOOD FIRE SUPPRESSION SYSTEM. INSTALLING CONTRACTOR SHALL FIELD VERIFY EXACT MOUNTING, CIRCUITING AND PROGRAMMING REQUIREMENTS. FIELD VERIFY EXACT QUANTITY AND LOCATION(S).

**CUNNINGHAM**  
**Security Systems**

10 Princes Point Road, Yarmouth, Maine 04096  
Office: 207.846.3350 • Fax: 207.846.6080

**4 UNIT APARTMENT BUILDING**  
**93 ST. LAWRENCE STREET**  
**PORTLAND, MAINE 04101**  
**FIRST FLOOR FIRE ALARM PLAN**

DRAWN	JPB UNICAD JOB #16252
CHECKED	WAYNE B. HAWES NCET # 90496
DATE	4/21/2016
REVISION	0
SCALE	1/4"=1'-0"