

REVISION	0	ISSUED FOR REVIEW & APPROVAL	4/21/2016
DESCRIPTION			
DATE			


RESERVED FOR CITY STAMP

CUNNINGHAM
Security Systems
 10 Princes Point Road, Yarmouth, Maine 04096
 Office: 207.846.3350 • Fax: 207.846.6080

4 UNIT APARTMENT BUILDING
93 ST. LAWRENCE STREET
PORTLAND, MAINE 04101
SECOND FLOOR FIRE ALARM PLAN

DRAWN	JPB	UNICAD JOB #16252
CHECKED	WAYNE B. HAWES	PROJECT # 90496
DATE	4/21/2016	
REVISION	0	
SCALE	1/4"=1'-0"	

FA-3

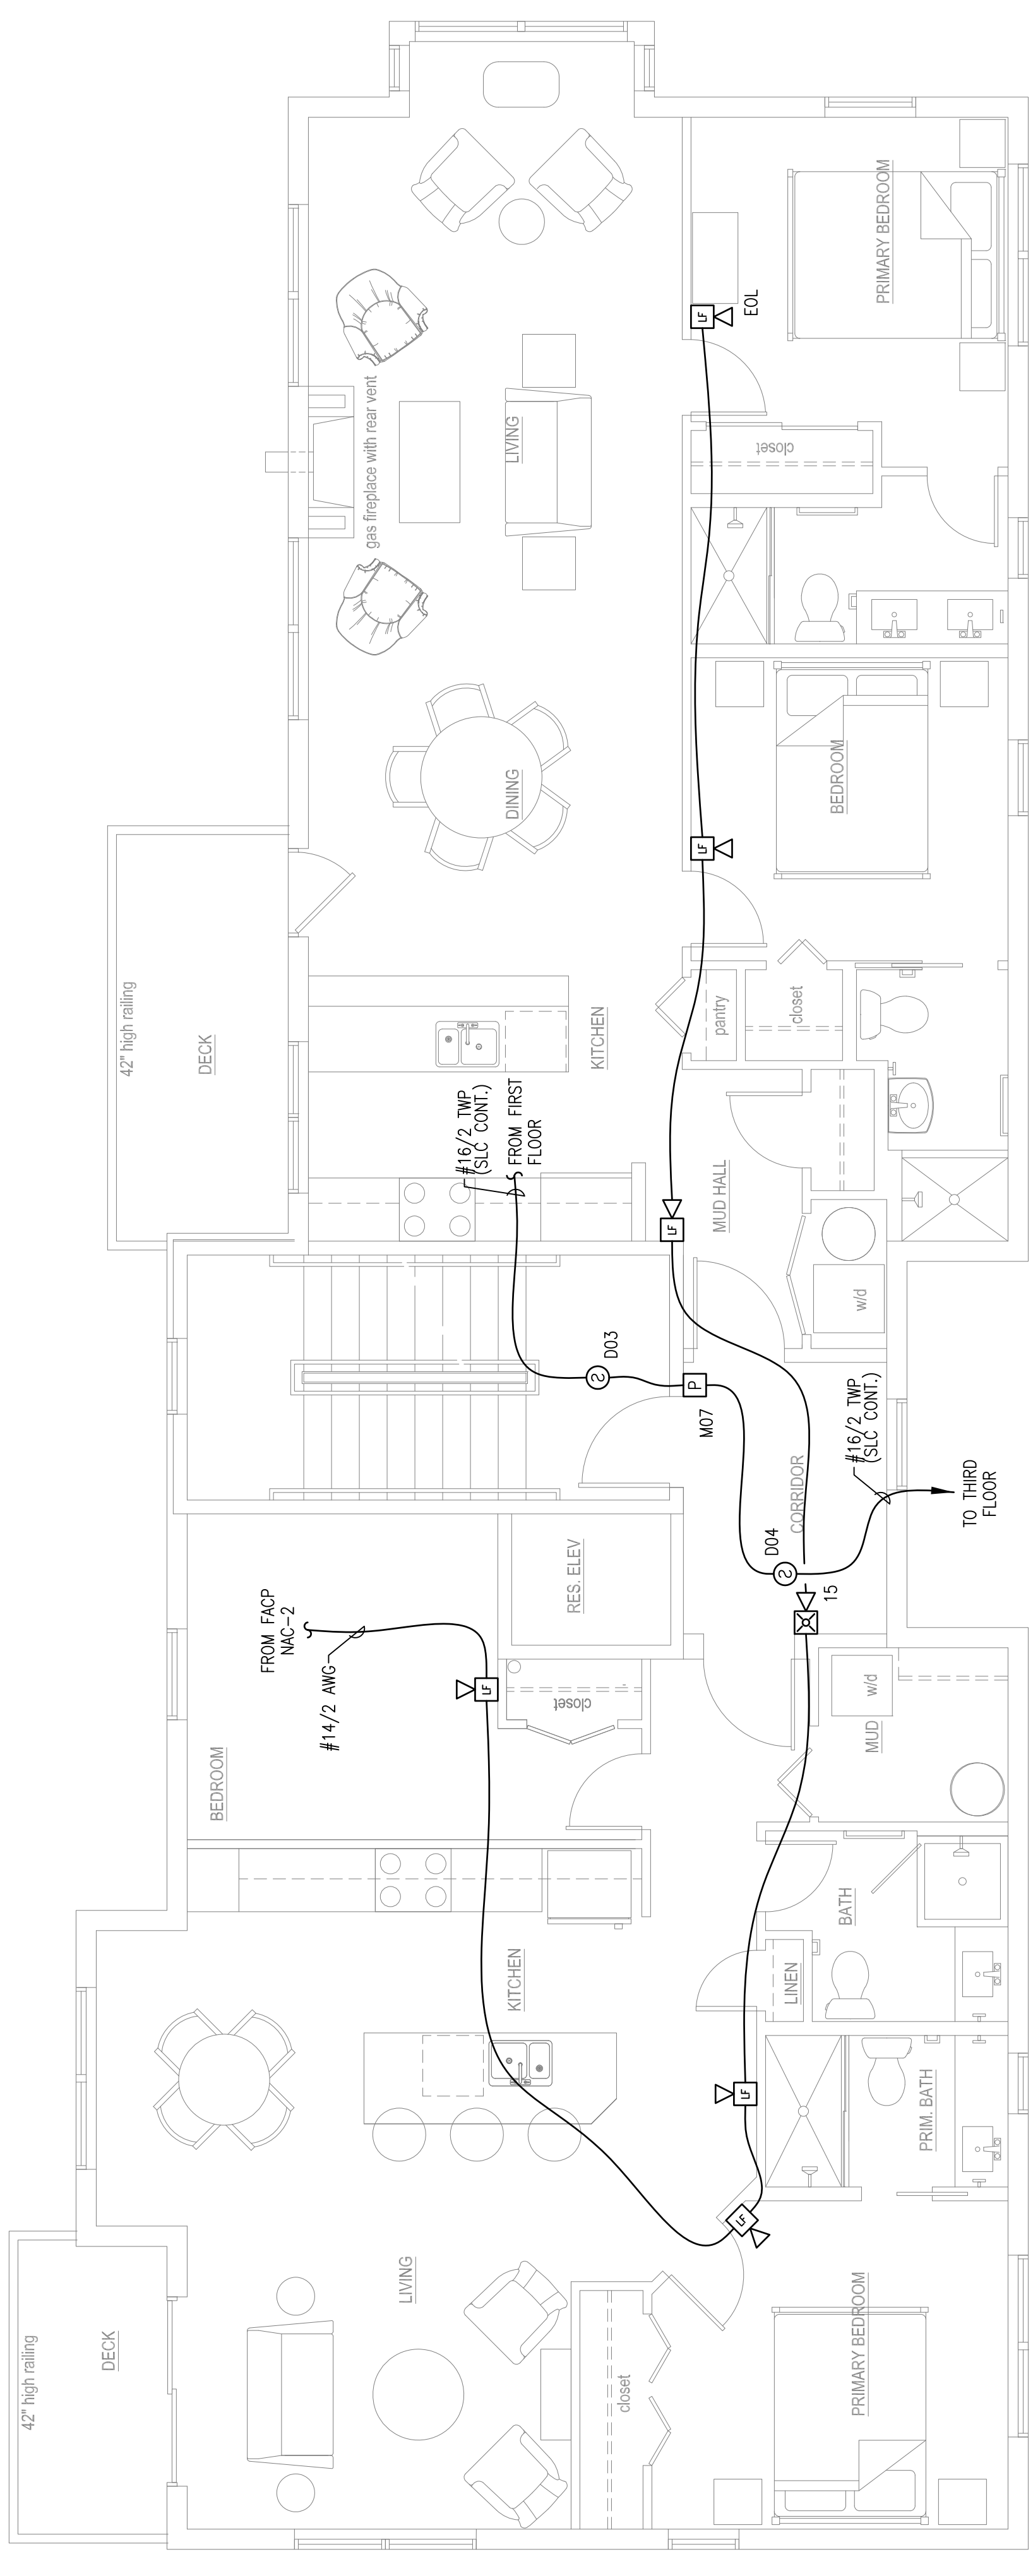

SECOND FLOOR FIRE ALARM PLAN
 SCALE: 1/4"=1'-0"

