

| REVISION | DESCRIPTION                  | DATE      |
|----------|------------------------------|-----------|
| 0        | ISSUED FOR REVIEW & APPROVAL | 4/21/2016 |

RESERVED FOR CITY STAMP


**CUNNINGHAM**  
**Security Systems**  
 10 Princes Point Road, Yarmouth, Maine 04096  
 Office: 207.846.3350 • Fax: 207.846.6080

**4 UNIT APARTMENT BUILDING**  
**93 ST. LAWRENCE STREET**  
**PORTLAND, MAINE 04101**  
**THIRD FLOOR FIRE ALARM PLAN**

|          |                                |
|----------|--------------------------------|
| DRAWN    | JPB UNICAD JOB #16252          |
| CHECKED  | WAYNE B. HAWES<br>NCET # 90496 |
| DATE     | 4/21/2016                      |
| REVISION | 0                              |
| SCALE    | 1/4"=1'-0"                     |

**FA-4**

**UNICAD** Inc.  
 575 W. 40th St.  
 Office: 603.865.6410  
 www.unicad.net  
 Fire Alarm Design & Drafting Services

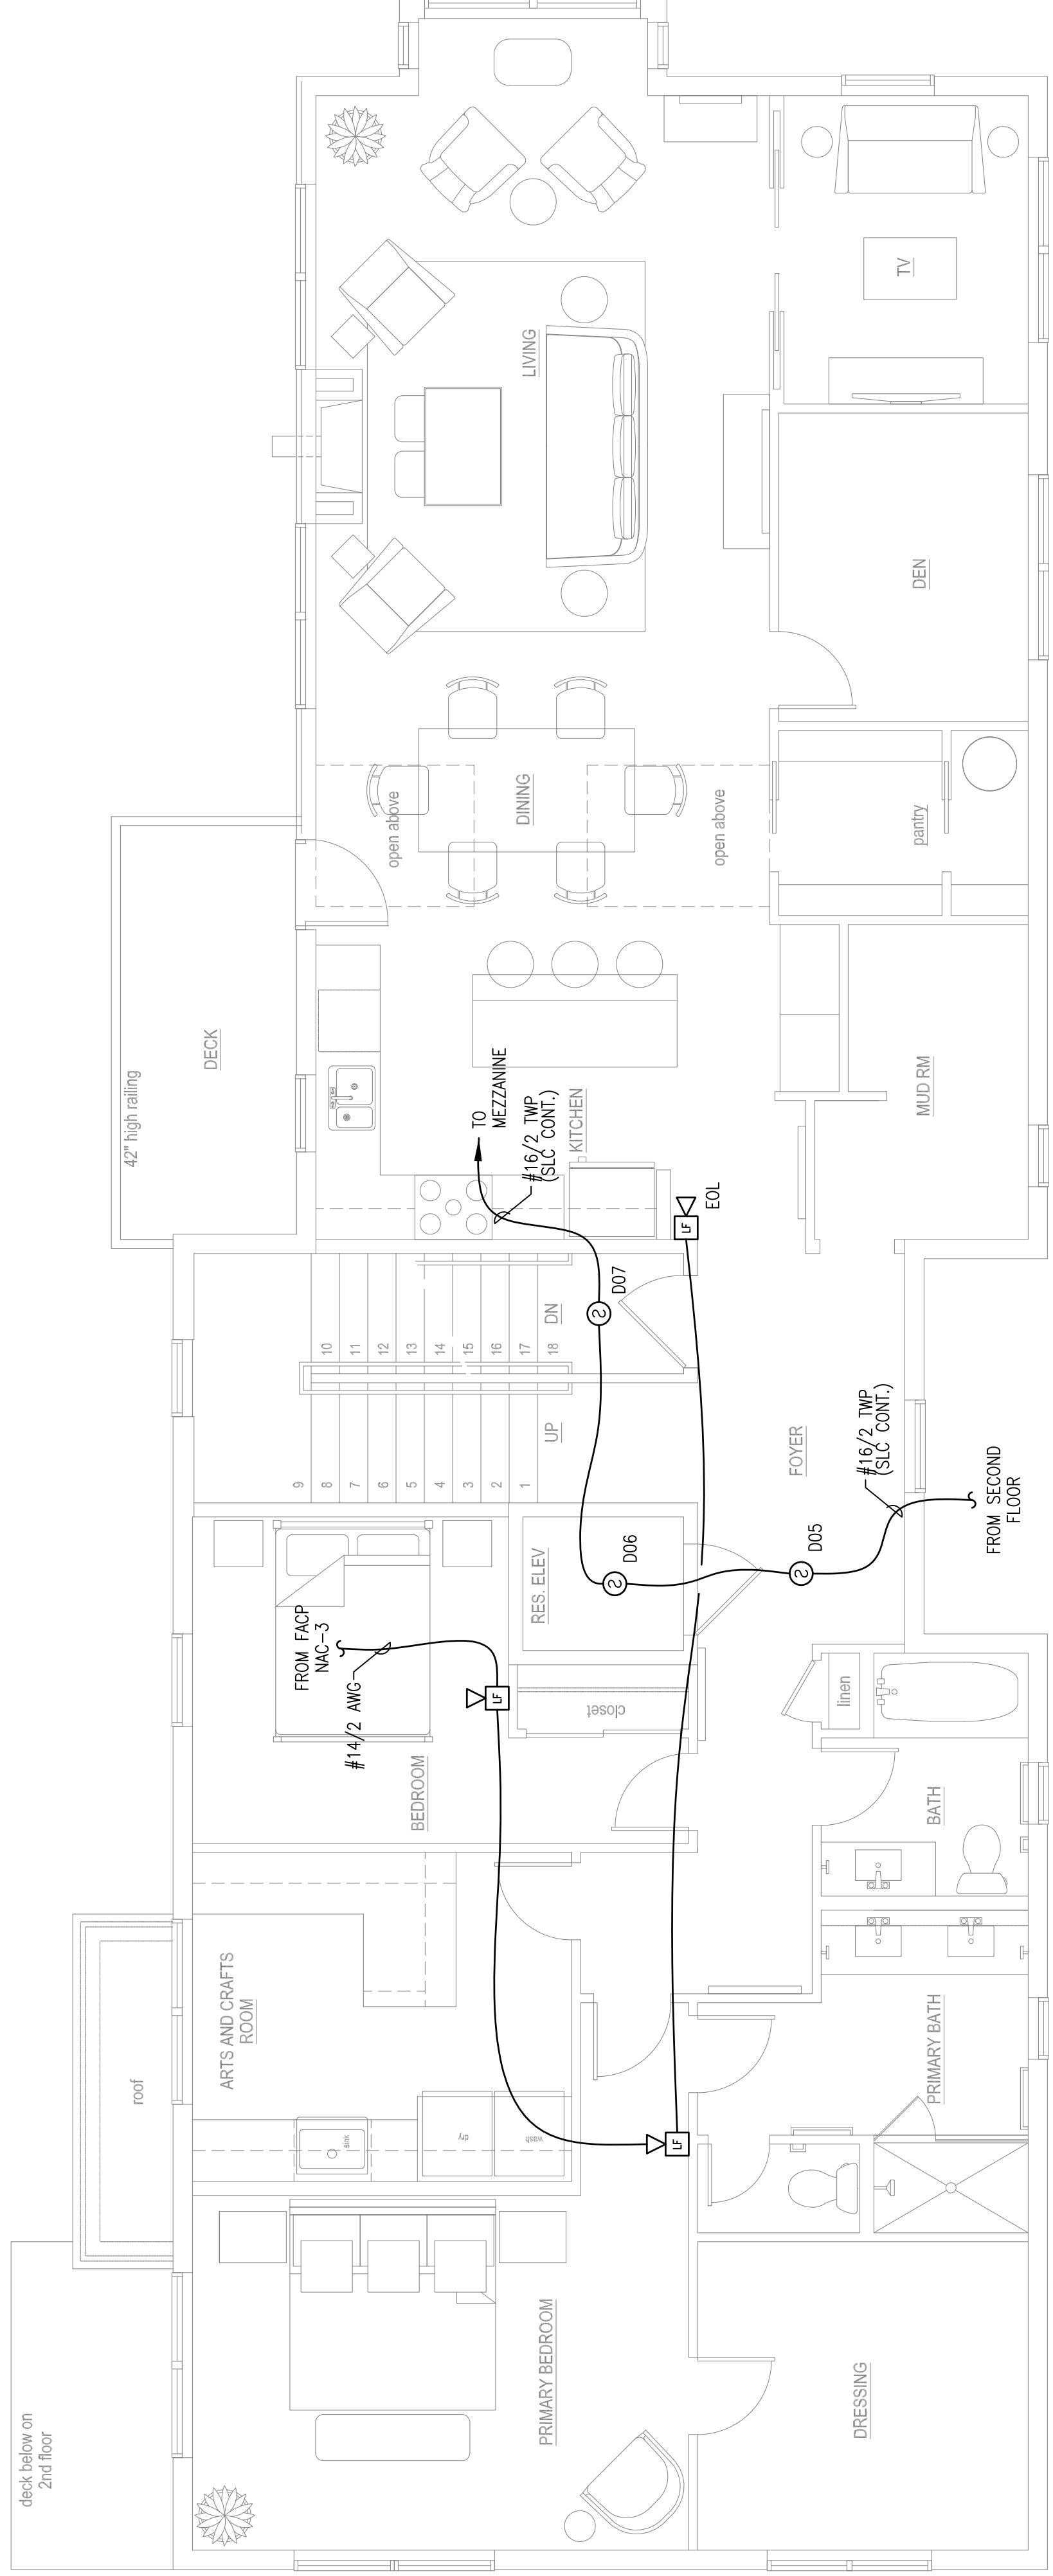

**THIRD FLOOR FIRE ALARM PLAN**  
 SCALE: 1/4"=1'-0"