

REVISION	DESCRIPTION	DATE
0	ISSUED FOR REVIEW & APPROVAL	4/21/2016

RESERVED FOR CITY STAMP


**CUNNINGHAM**  
**Security Systems**  
 10 Princes Point Road, Yarmouth, Maine 04096  
 Office: 207.846.3350 • Fax: 207.846.6080

**4 UNIT APARTMENT BUILDING**  
**93 ST. LAWRENCE STREET**  
**PORTLAND, MAINE 04101**  
**ROOF/MEZZANINE FIRE ALARM PLAN**

DRAWN	JPB UNICAD JOB #16252
CHECKED	WAYNE B. HAWES NCET # 90496
DATE	4/21/2016
REVISION	0
SCALE	1/4"=1'-0"

**FA-5**

**UNICAD** Inc.  
 579 W. 40th St.  
 Portland, ME 04102  
 Office: 603.865.6410  
 www.unicad.net  
 Fire Alarm Design & Drafting Services

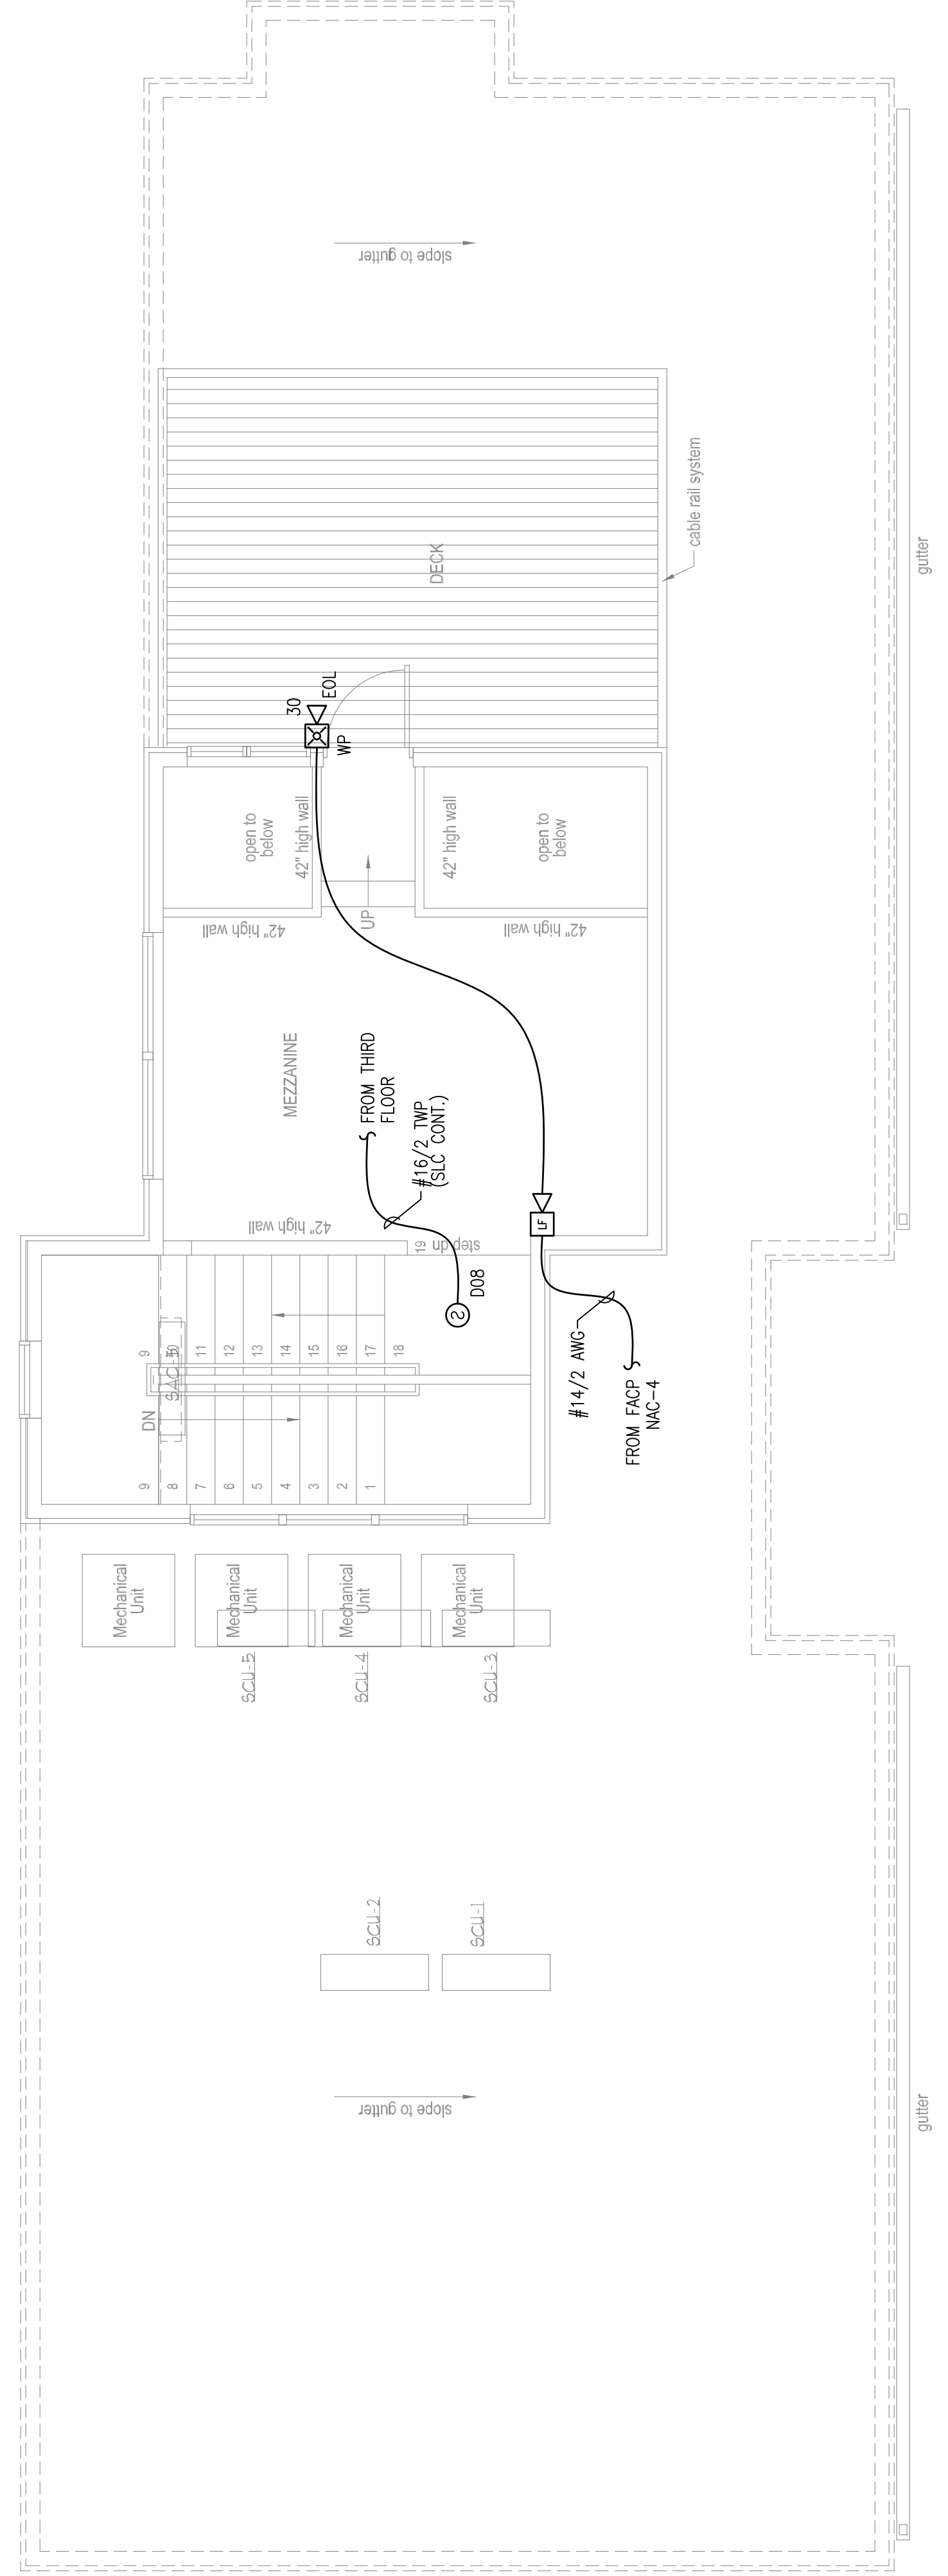

**ROOF/MEZZANINE FIRE ALARM PLAN**  
 SCALE: 1/4"=1'-0"