


1 SECOND FLOOR ELECTRICAL PLAN
SCALE: 1/4" = 1'-0"

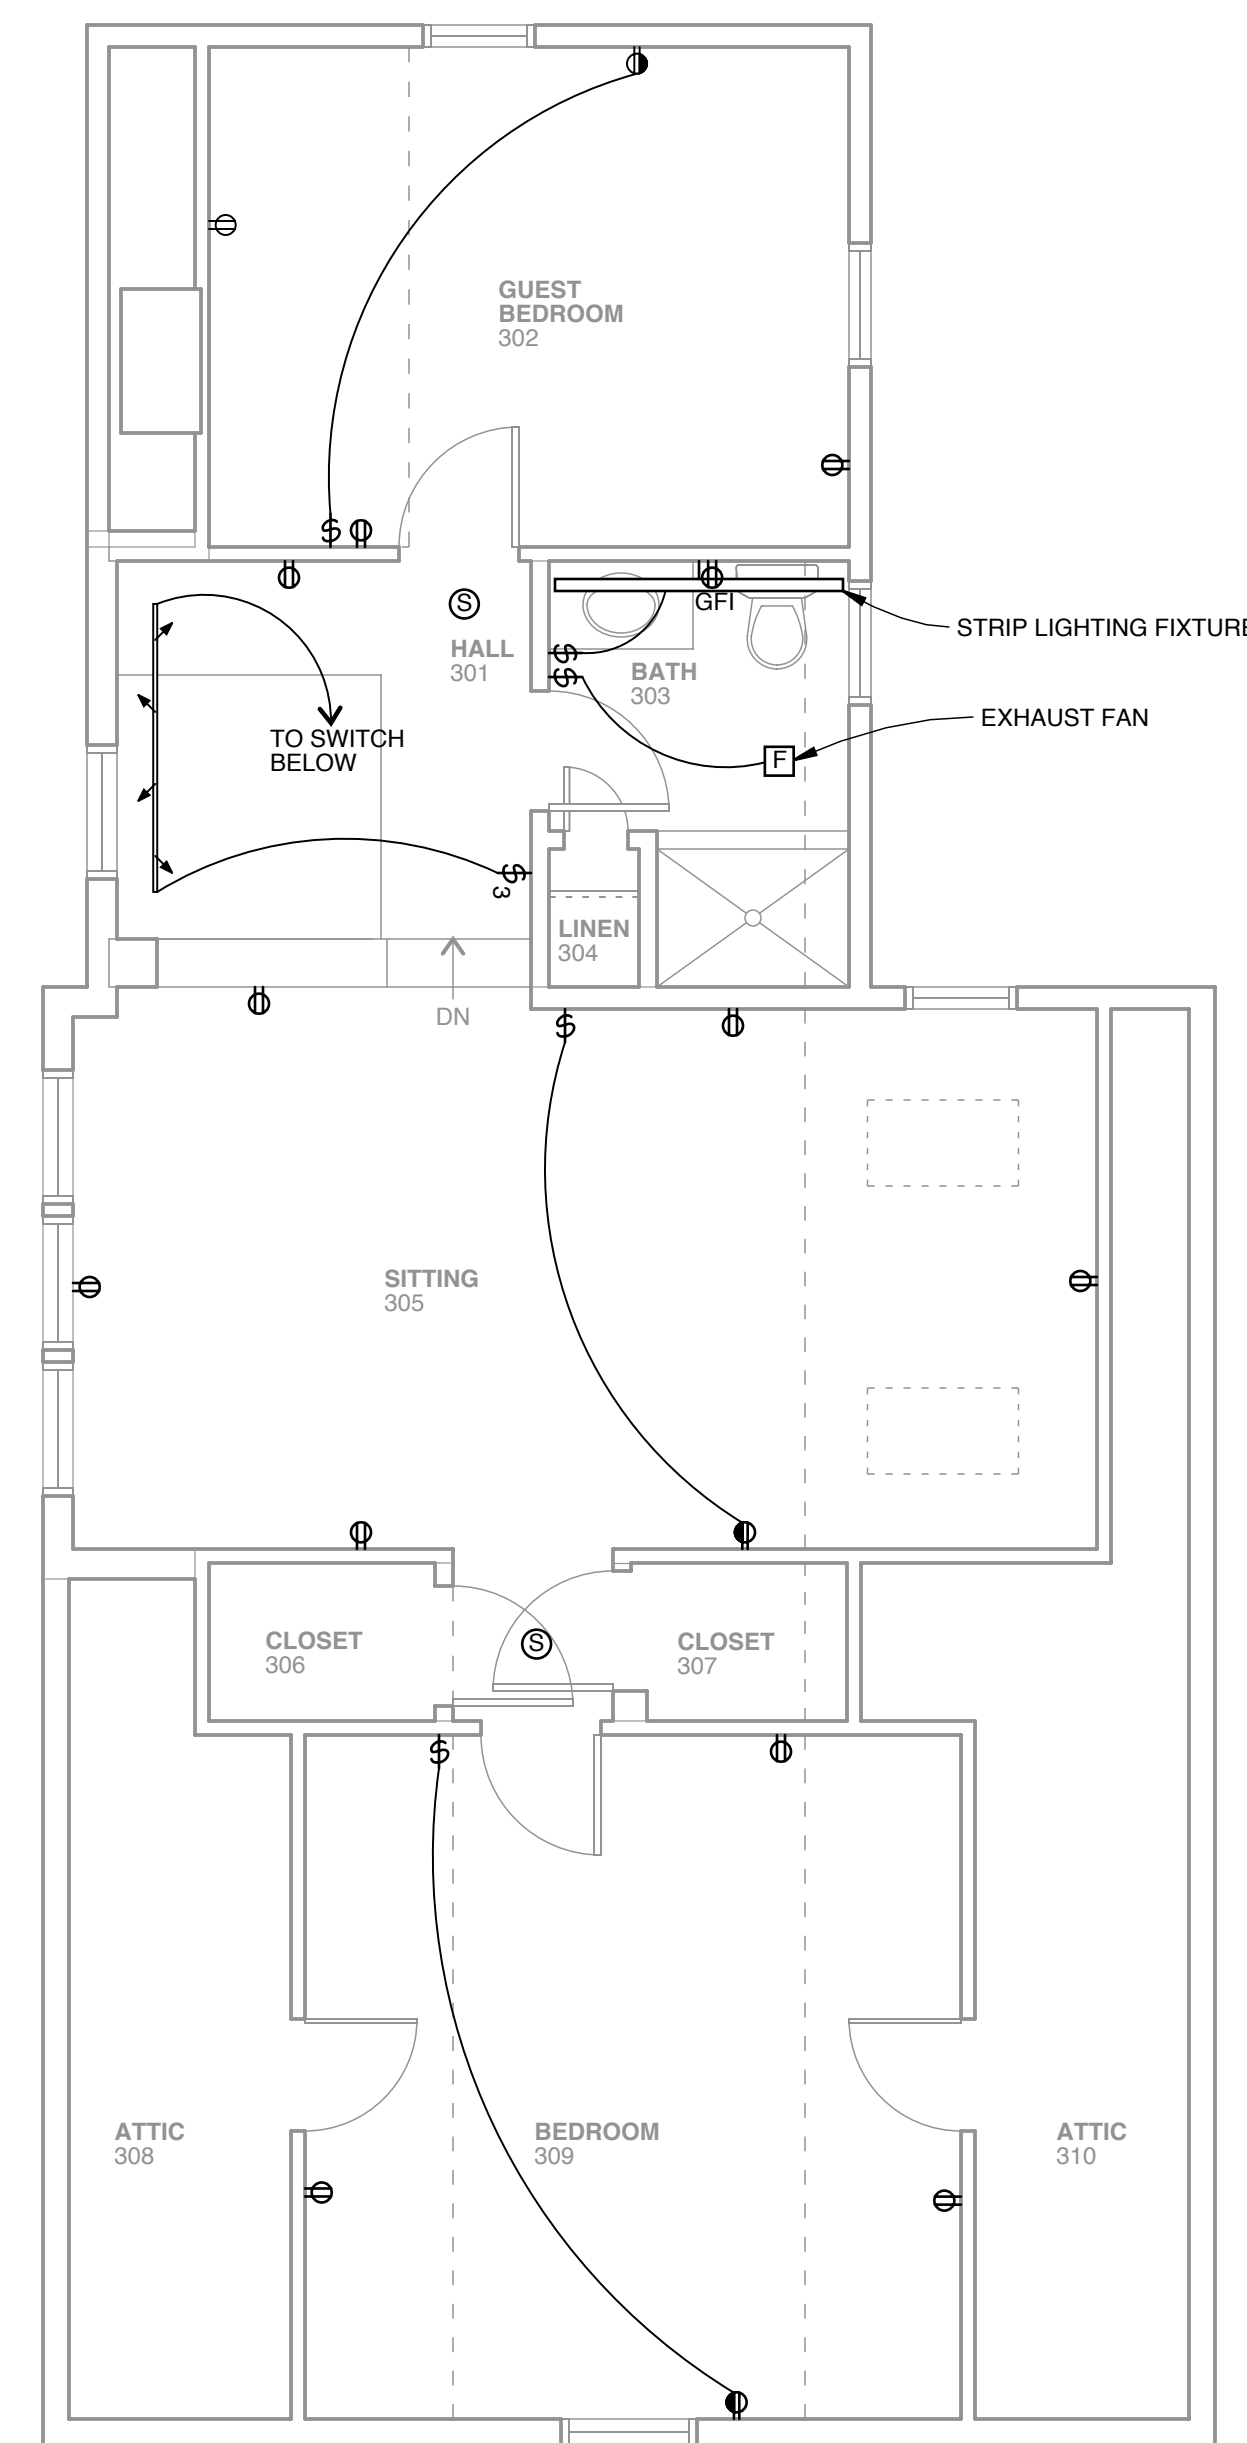

2 THIRD FLOOR ELECTRICAL PLAN
SCALE: 1/4" = 1'-0"

- ELECTRICAL LEGEND**
- DUPLEX OUTLET
 - GFI DUPLEX OUTLET
 - DUPLEX OUTLET
 - SINGLE-POLE SWITCH
 - 3-WAY SWITCH
 - EXHAUST FAN
 - SMOKE DETECTOR
 - RECESS LIGHTING FIXTURE
 - SURFACE LIGHTING FIXTURE
 - 6'-0" STRIP LIGHT FIXTURE
 - 6'-0" TRACK LIGHT

**Michael R. Charek
Architect**
25 Hartley Street
Portland, Maine 04103
(207) 761-0556

**Akerlind Residence
Renovations**
44 Monument Street
Portland, ME 04101

Title
2ND AND 3RD
FLOOR
ELECTRICAL
PLANS

Scale: 1/4" = 1'-0"

Date: 3/24/06

Revisions
**ISSUED FOR
PERMIT**

Sheet
A4

