




**1 BASEMENT ELECTRICAL PLAN**  
SCALE = 1/4" = 1'-0"

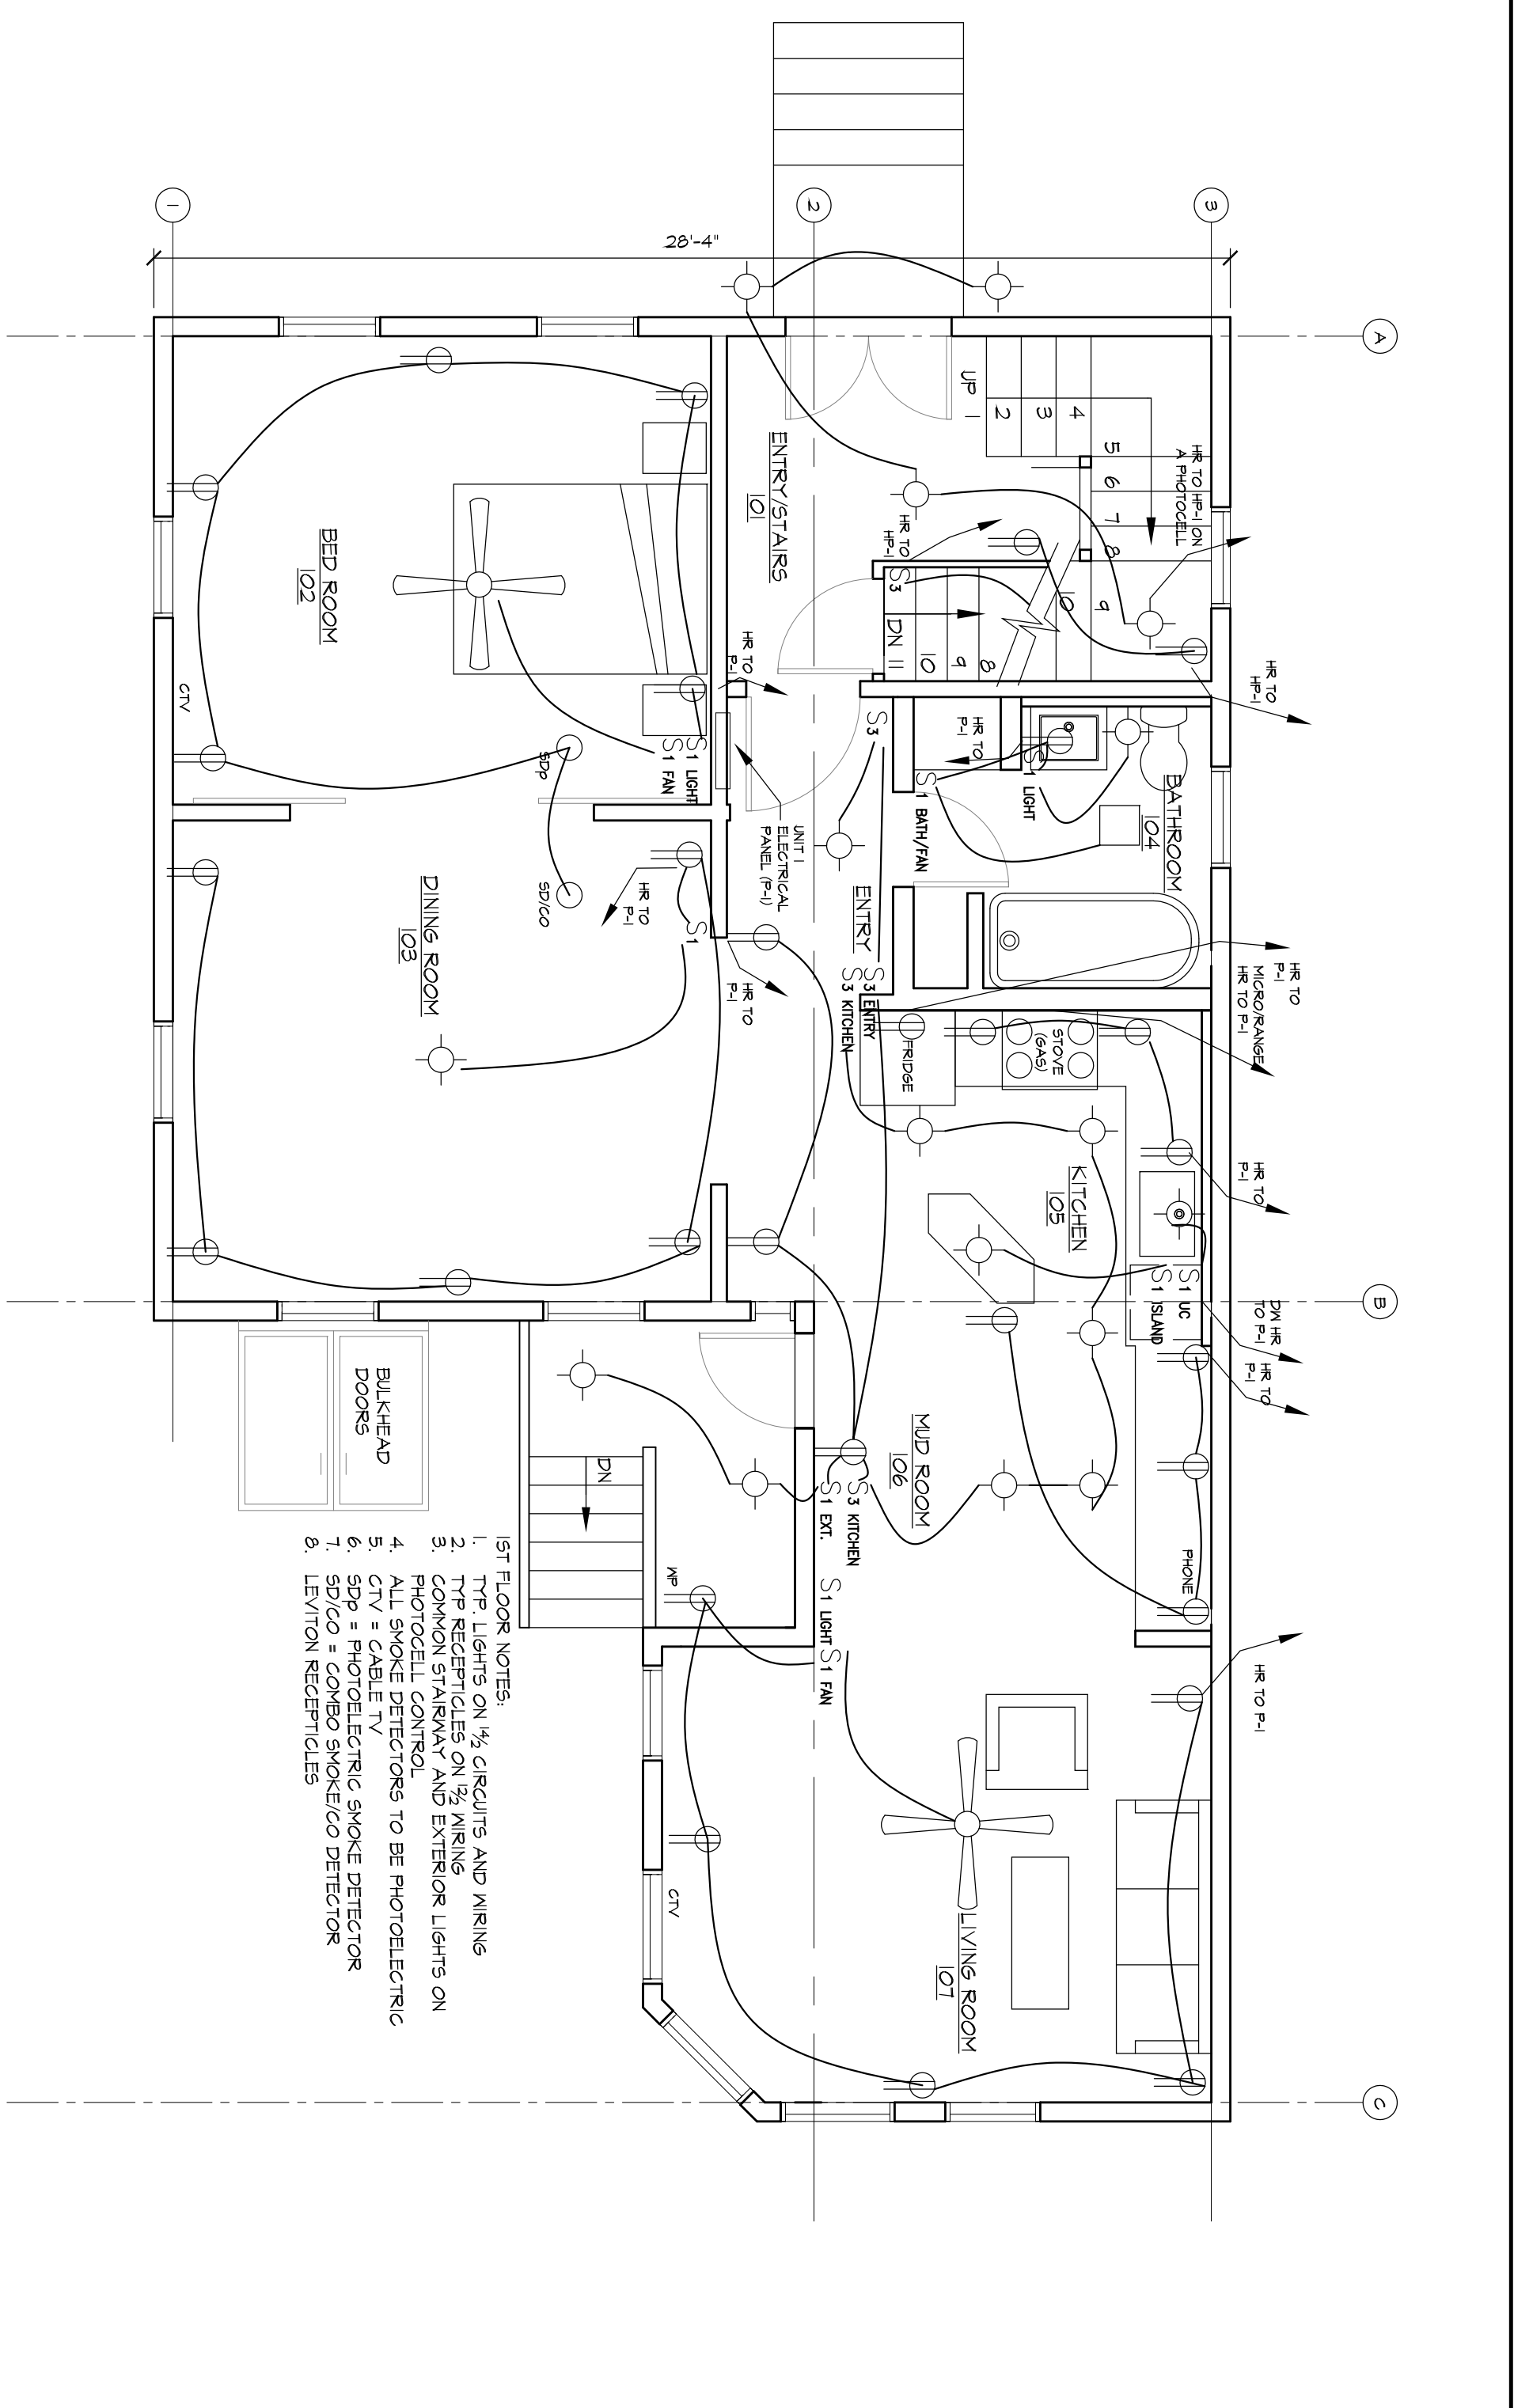

**2 FIRST FLOOR ELECTRICAL PLAN**  
SCALE = 1/4" = 1'-0"

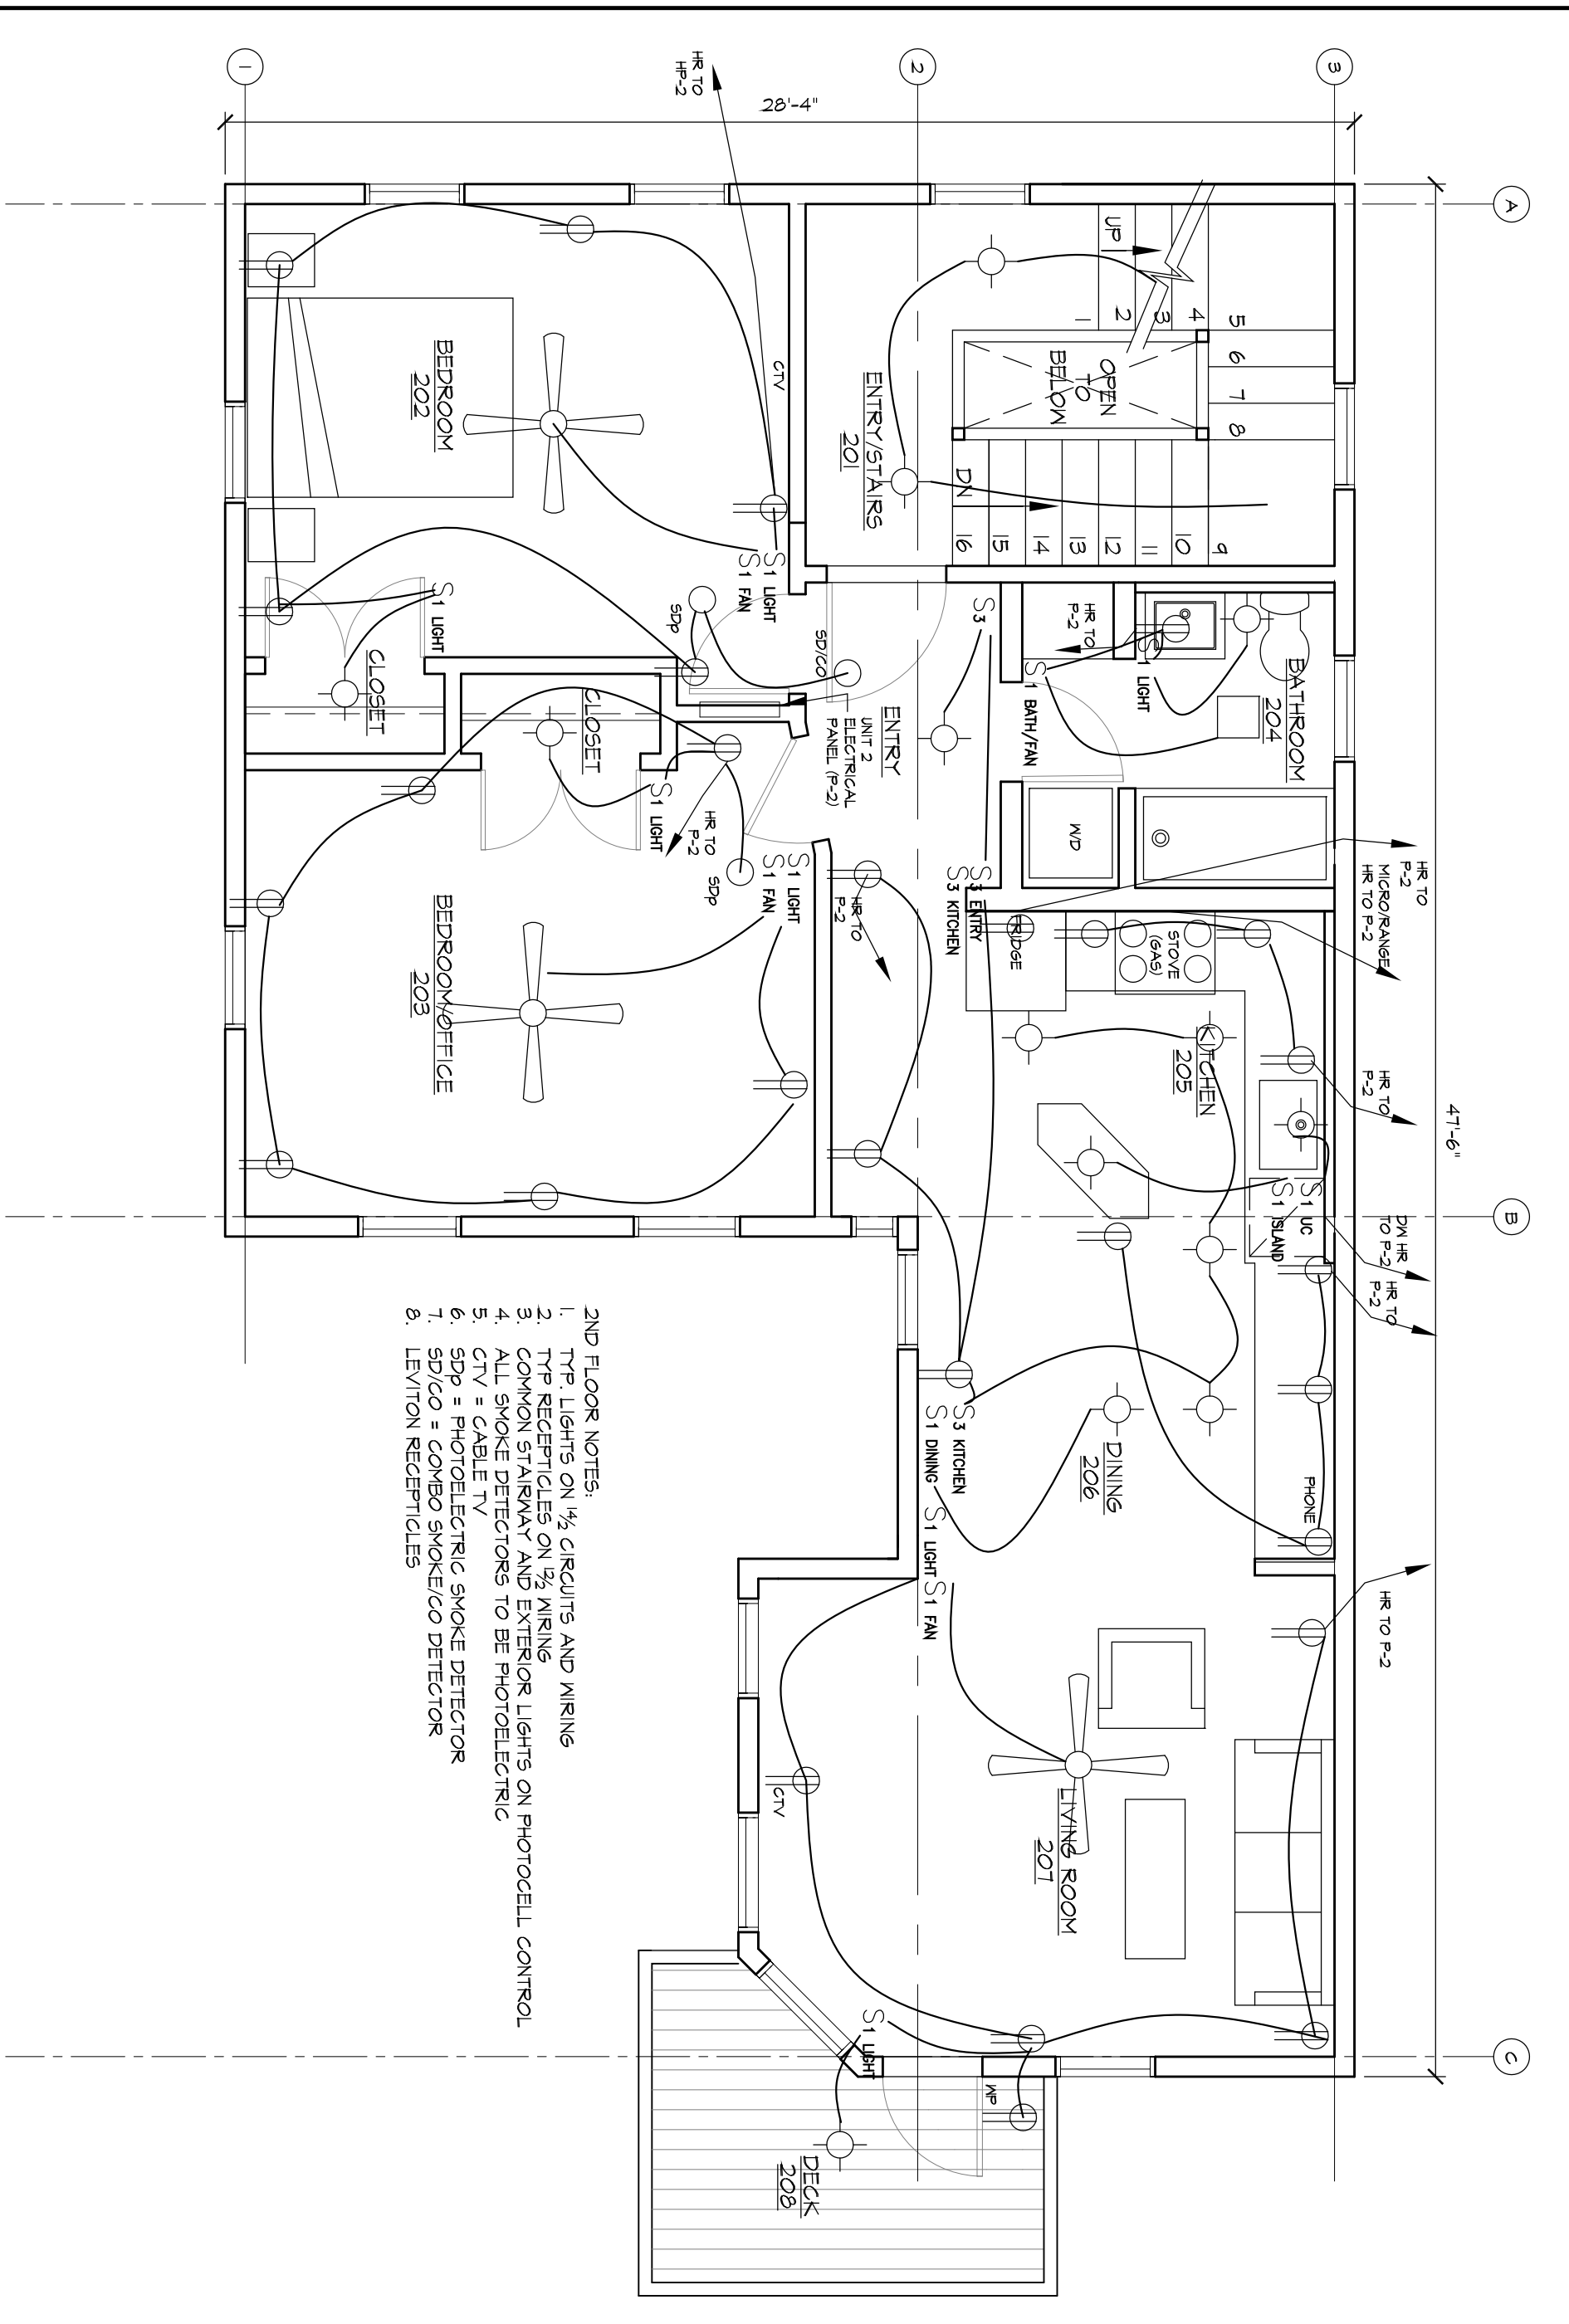

**3 SECOND FLOOR ELECTRICAL PLAN**  
SCALE = 1/4" = 1'-0"

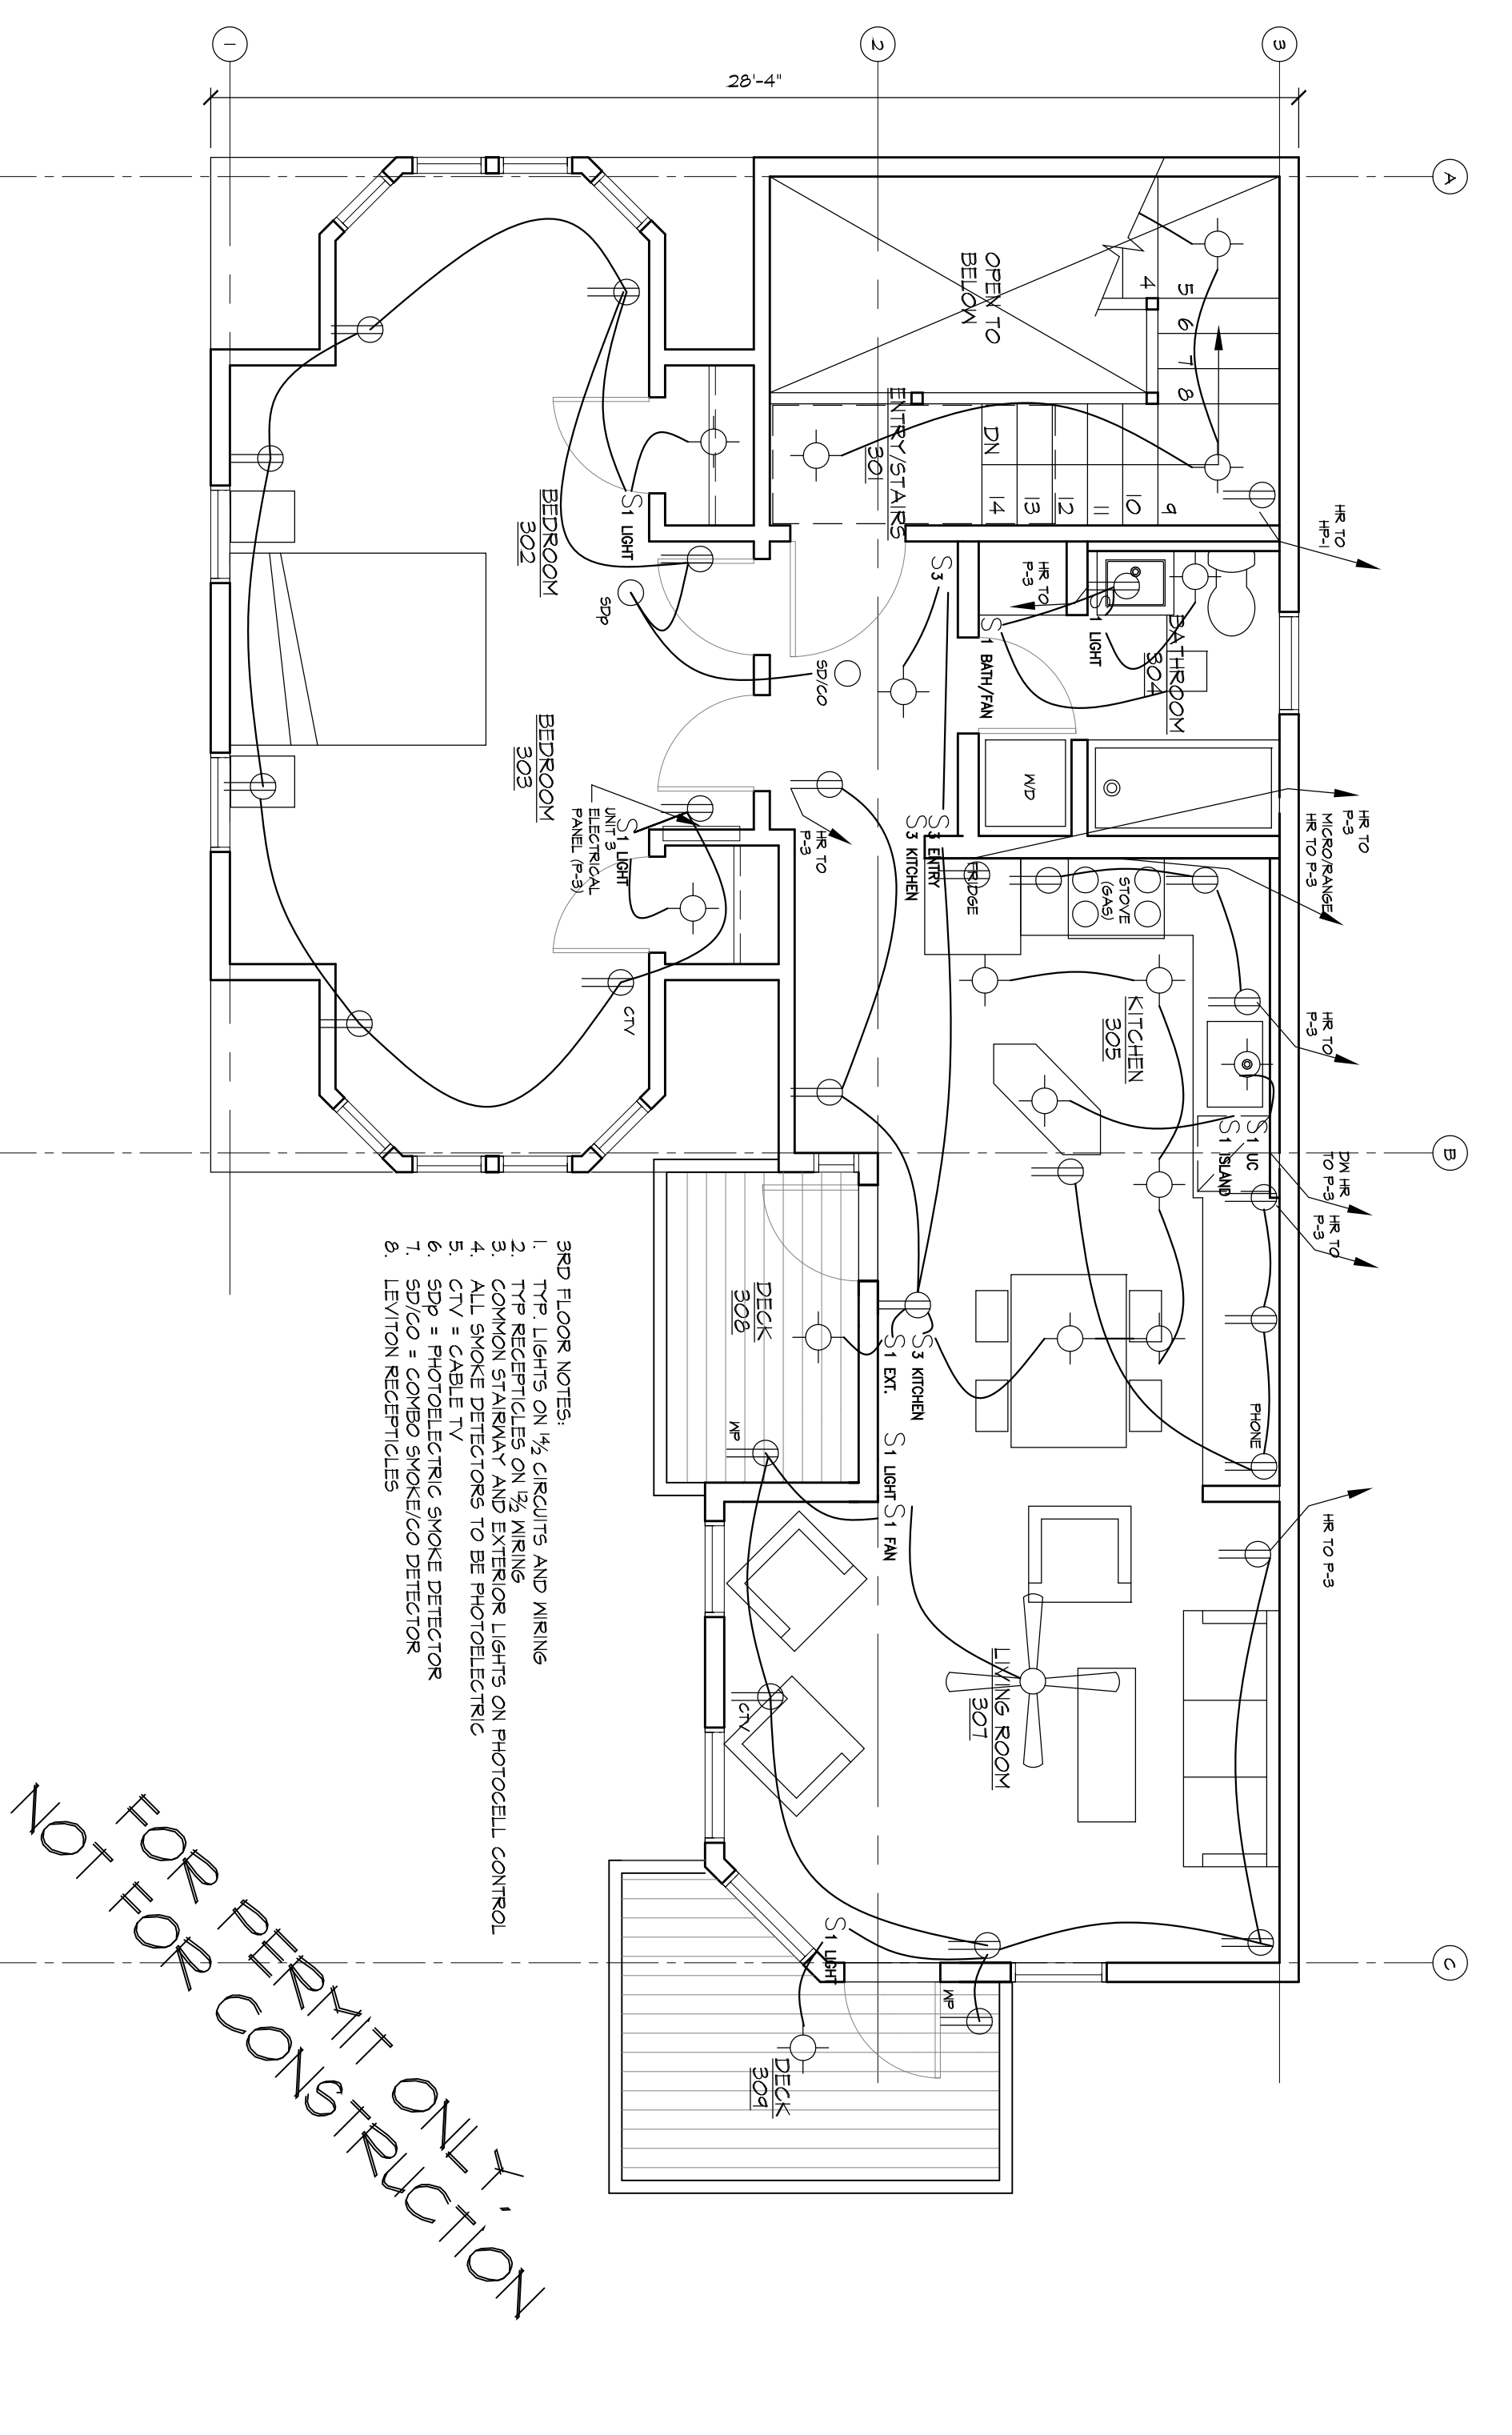

**4 THIRD FLOOR ELECTRICAL PLAN**  
SCALE = 1/4" = 1'-0"

FOR PERMIT ONLY  
NOT FOR CONSTRUCTION

ELECTRICAL  
DESIGN/BUILD  
BY JOE  
CORMIER,  
CORMIER  
ELECTRIC  
201-423-5225.

DRAFTED BY  
LACHMAN  
ARCHITECTS  
AND  
PLANNERS

ALTERATIONS TO  
52 MONUMENT STREET  
PORTLAND, MAINE

TITLE  
ELECTRICAL  
FLOOR  
PLANS

DATE:  
ORIGINAL: 11/5/13  
REVISION 1:  
REVISION 2:  
REVISION 3:  
DESIGNED FOR:  
BUILDING PERMIT SET

DRAWING NO:  
E1