




1 BASEMENT MECHANICAL AND GAS PLAN  
SCALE = 1/4" = 1'-0"

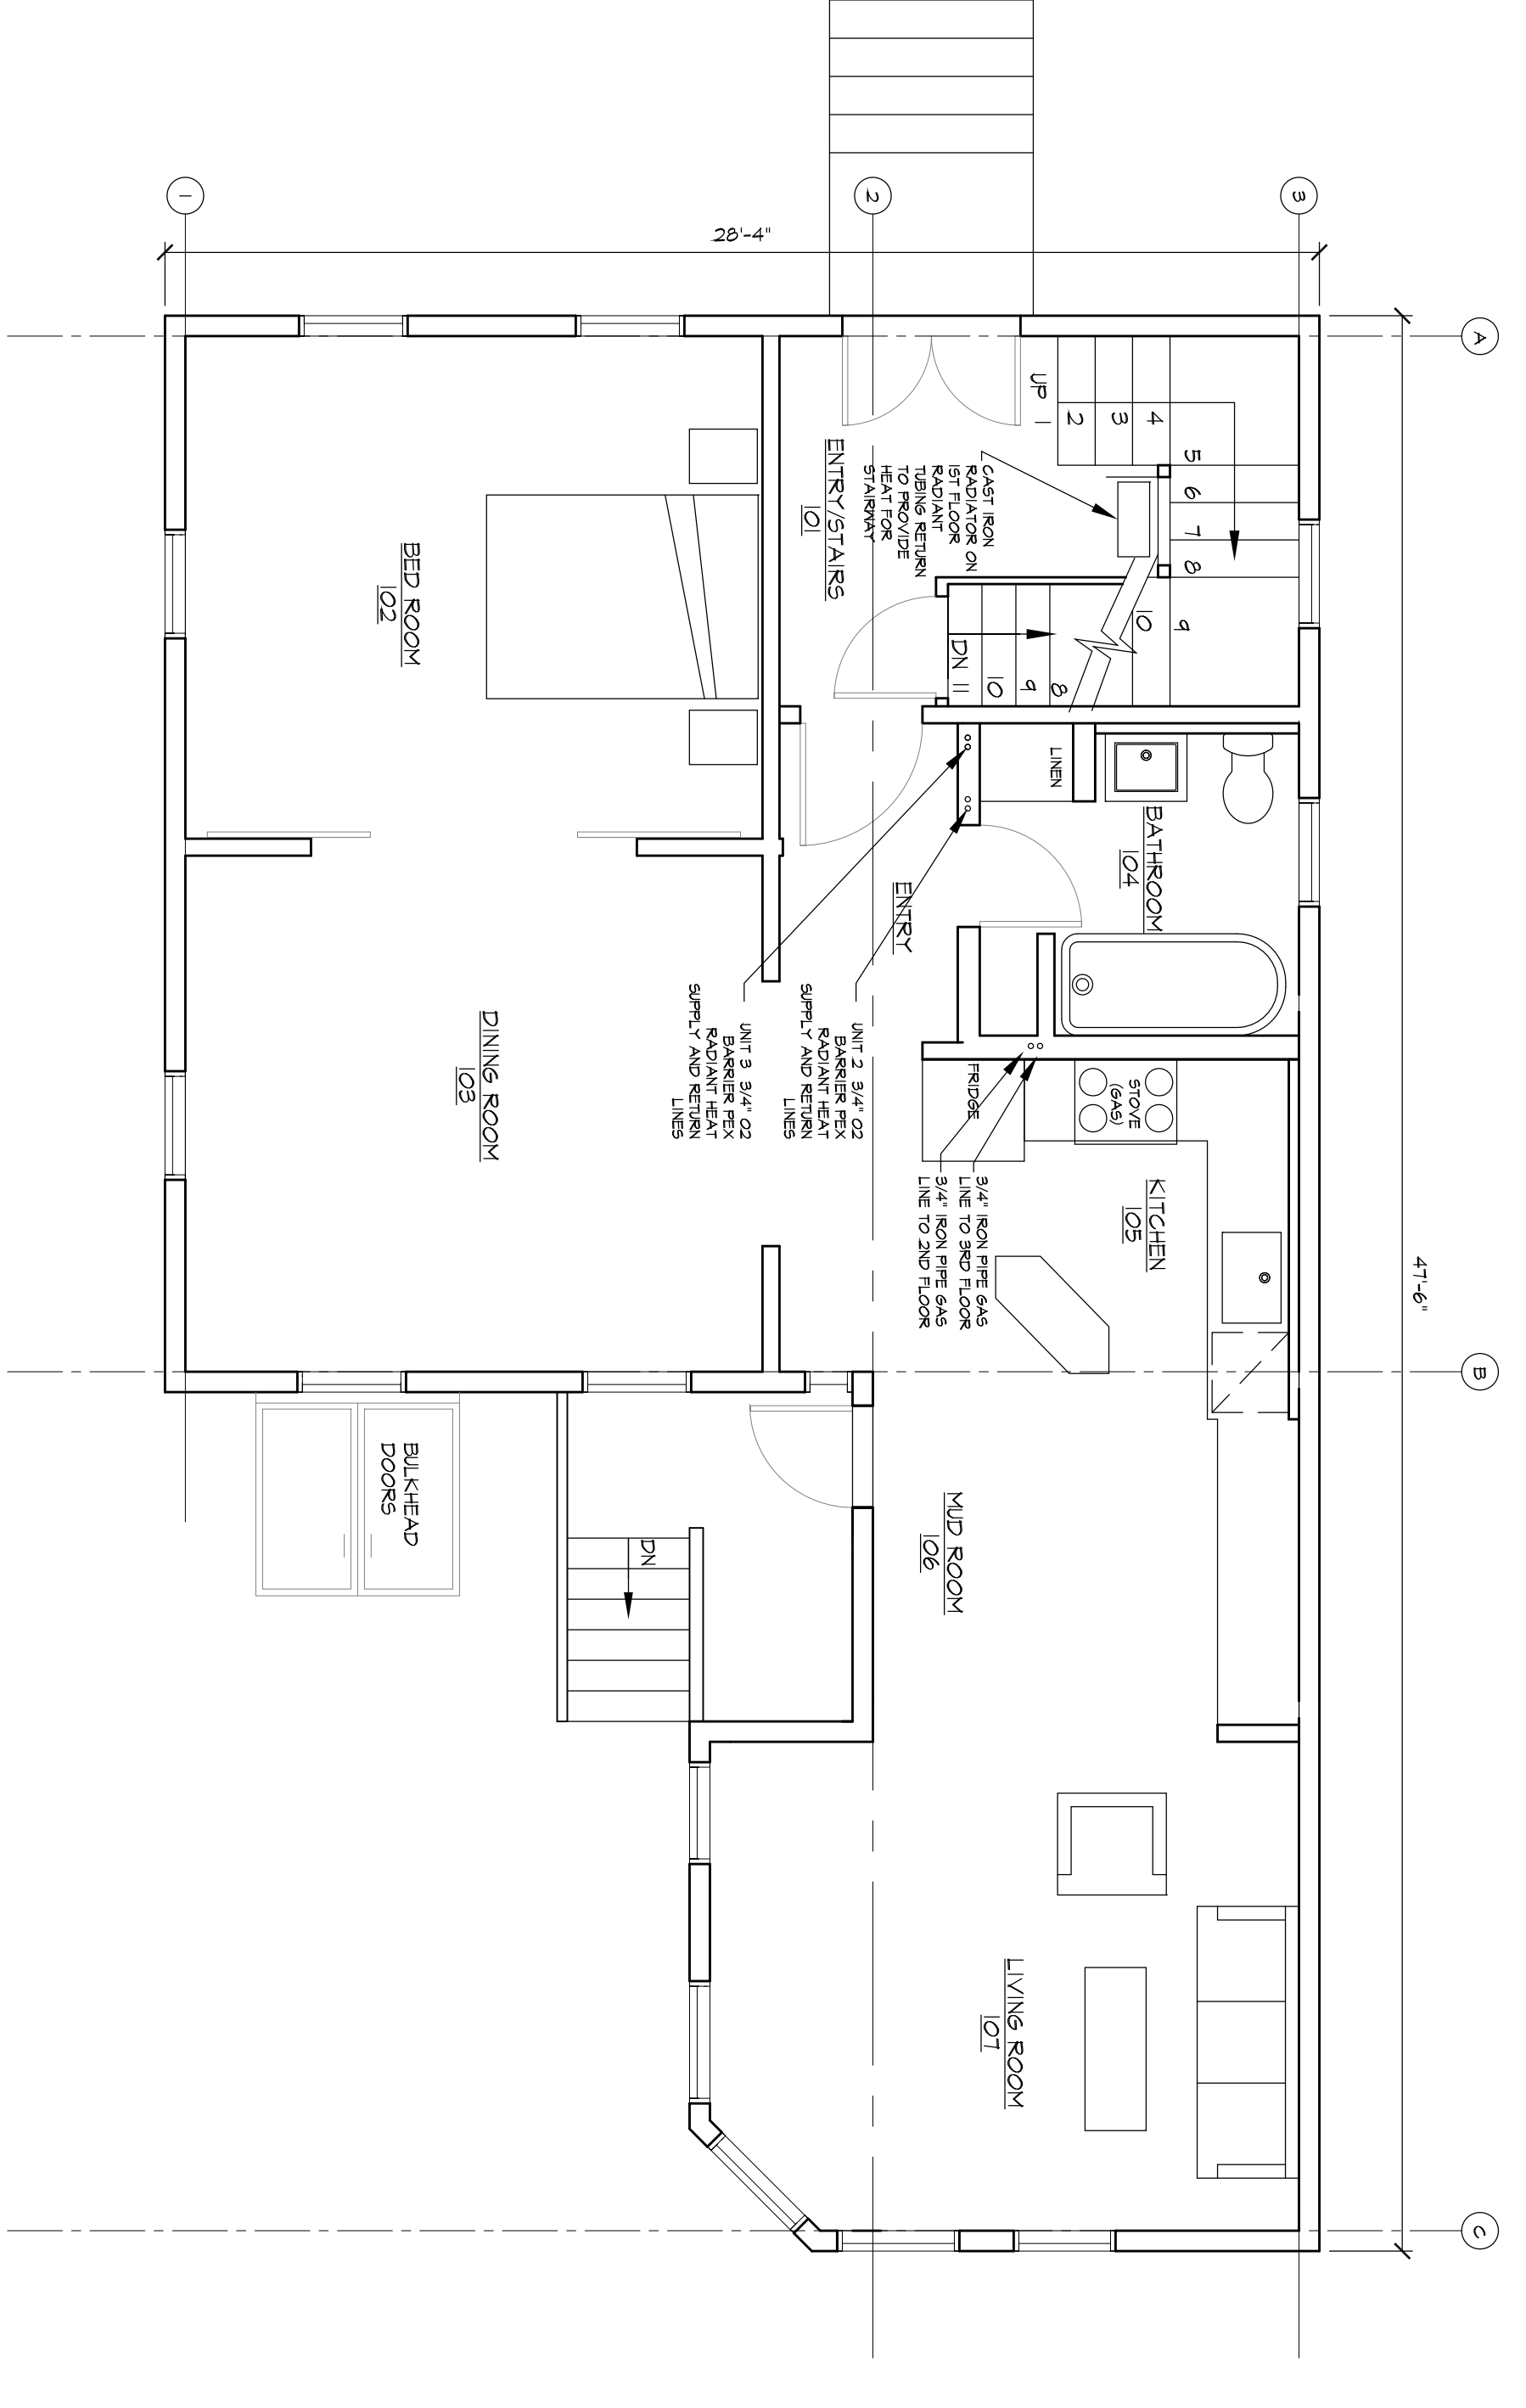

2 FIRST FLOOR MECHANICAL AND GAS PLAN  
SCALE = 1/4" = 1'-0"

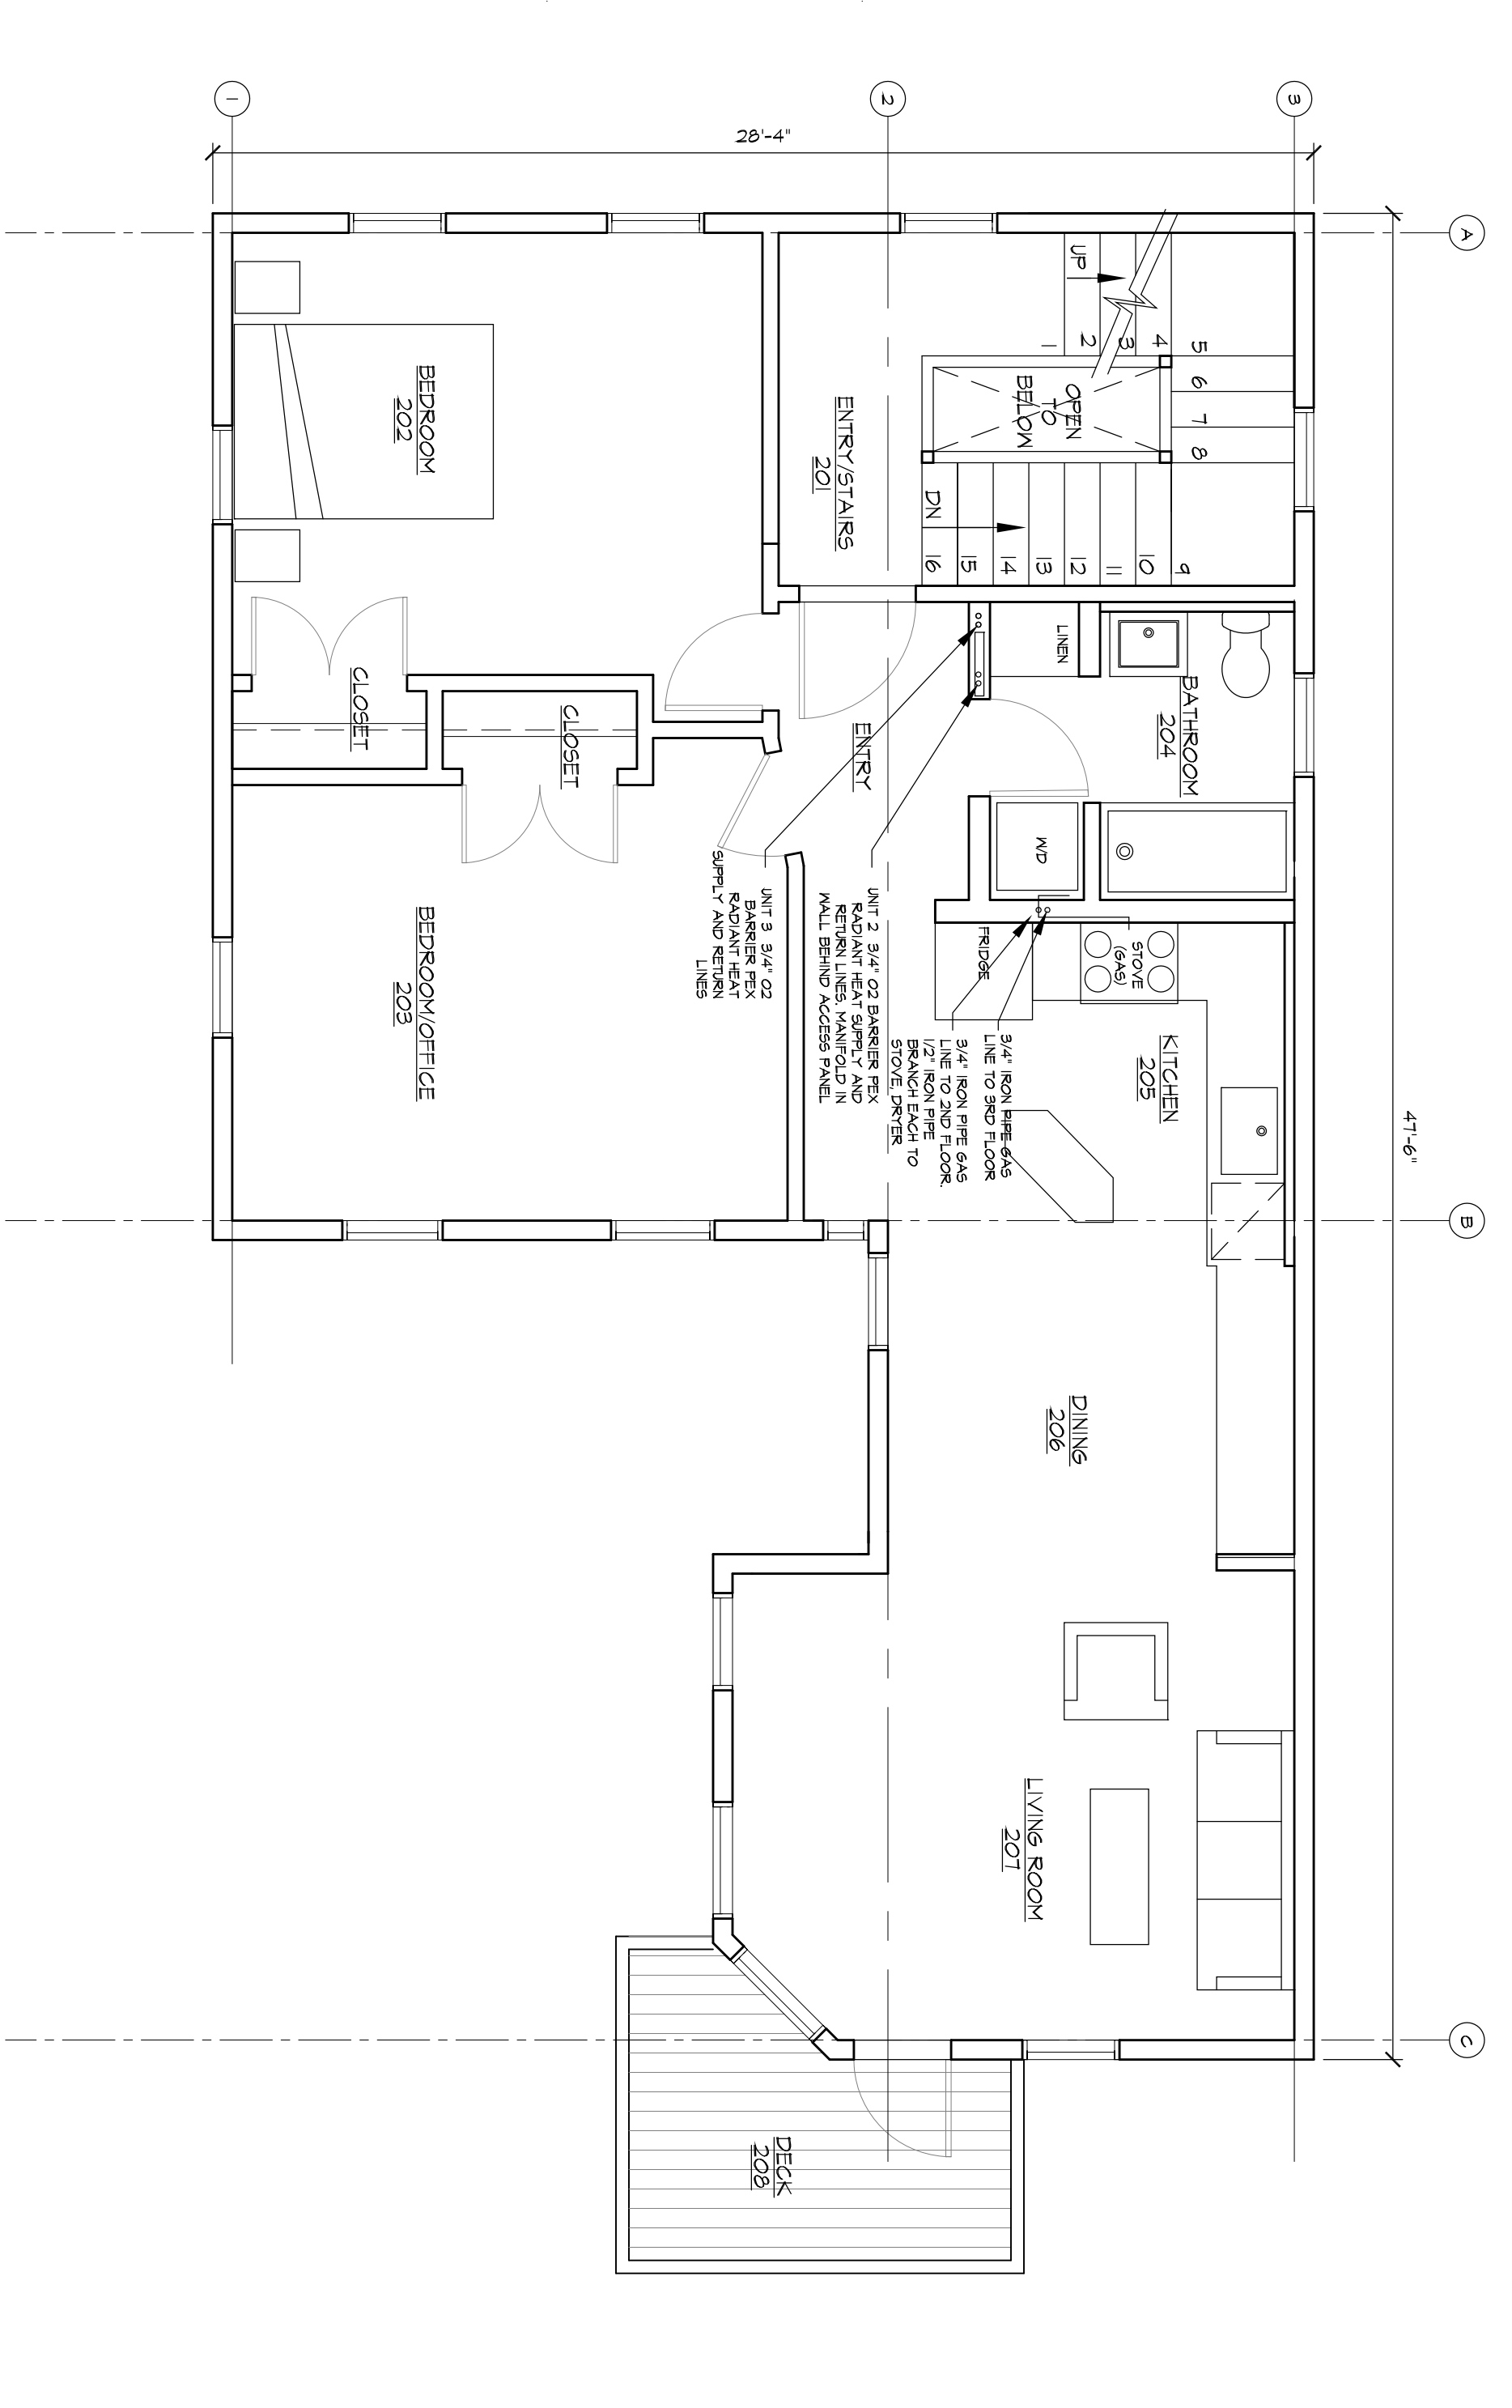

3 SECOND FLOOR MECHANICAL AND GAS PLAN  
SCALE = 1/4" = 1'-0"

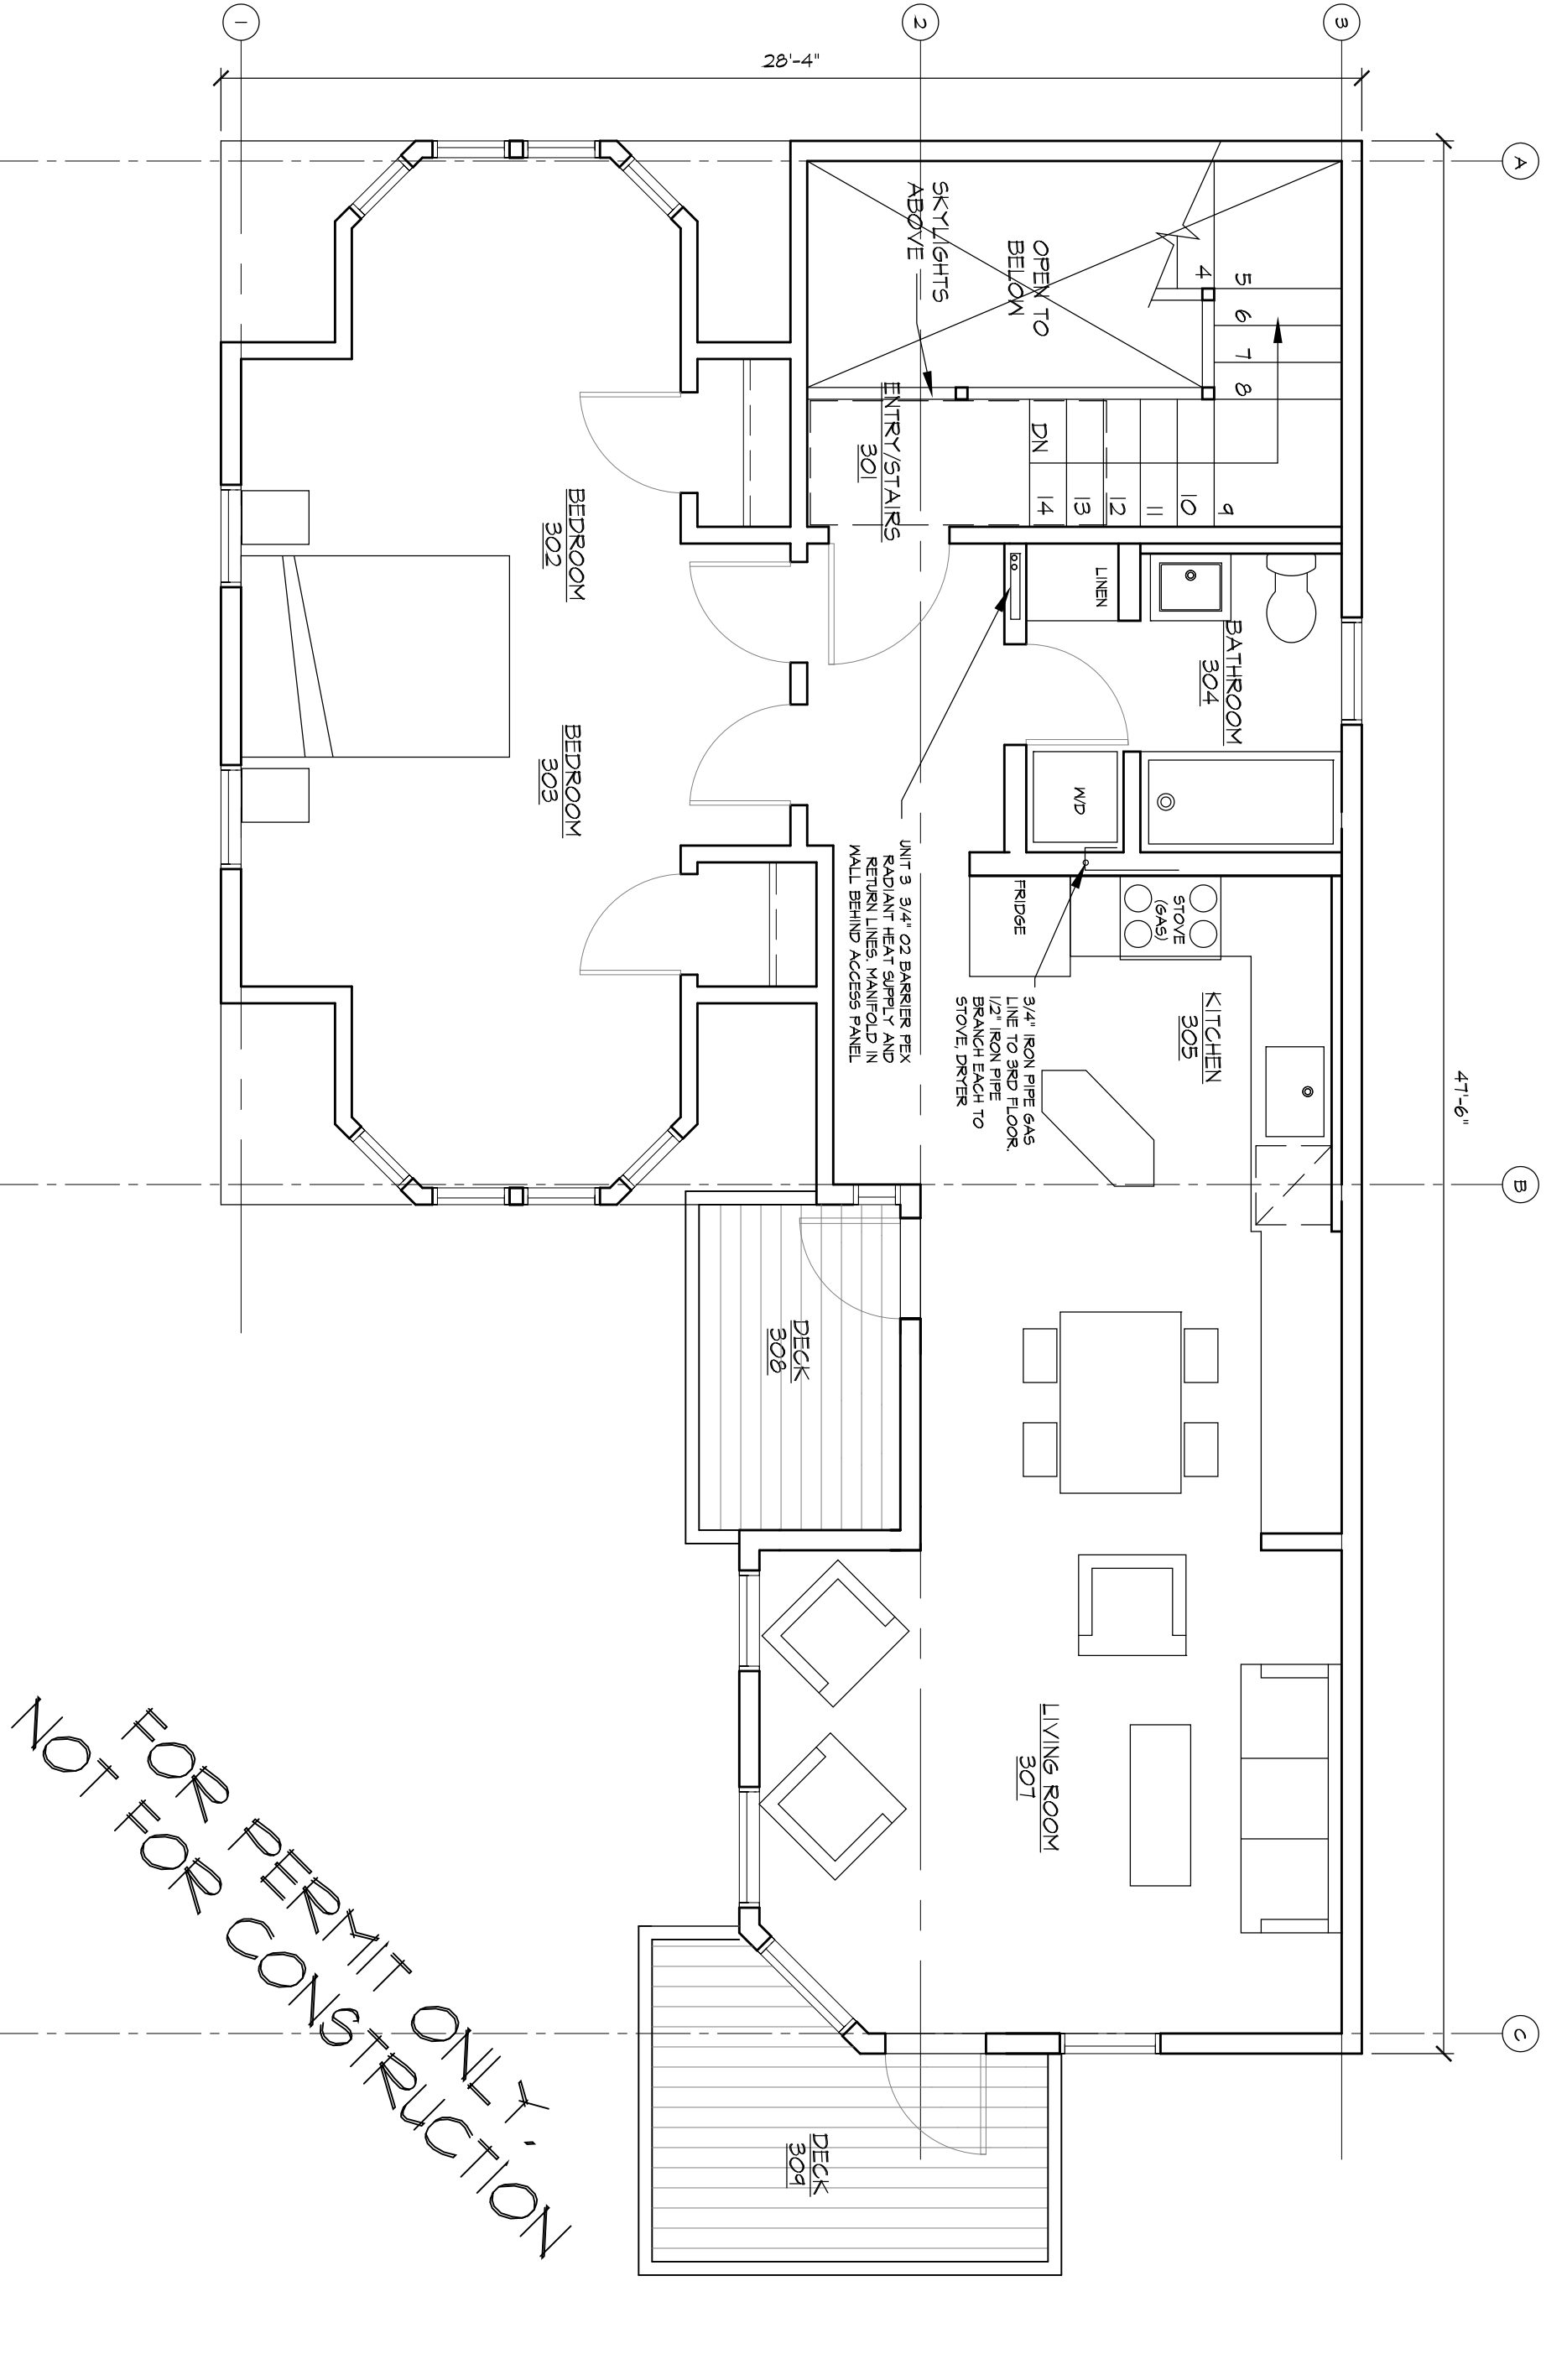

4 THIRD FLOOR MECHANICAL AND GAS PLAN  
SCALE = 1/4" = 1'-0"

MECHANICAL DESIGN/BUILD  
By JIM MICHAUD,  
JIM'S PLUMBING & HEATING,  
201-854-8861

DRAFTED BY LACHMAN ARCHITECTS AND PLANNERS

ALTERATIONS TO  
52 MONUMENT STREET  
PORTLAND, MAINE

TITLE  
MECHANICAL FLOOR PLANS

DATE:  
ORIGINAL: 11/5/13  
REVISION 1:  
REVISION 2:  
REVISION 3:

DESIGNED FOR:  
BUILDING PERMIT SET

DRAWING NO. 11

FOR PERMIT ONLY,  
NOT FOR CONSTRUCTION