




1 BASEMENT PLUMBING PLAN
SCALE = 1/4" = 1'-0"

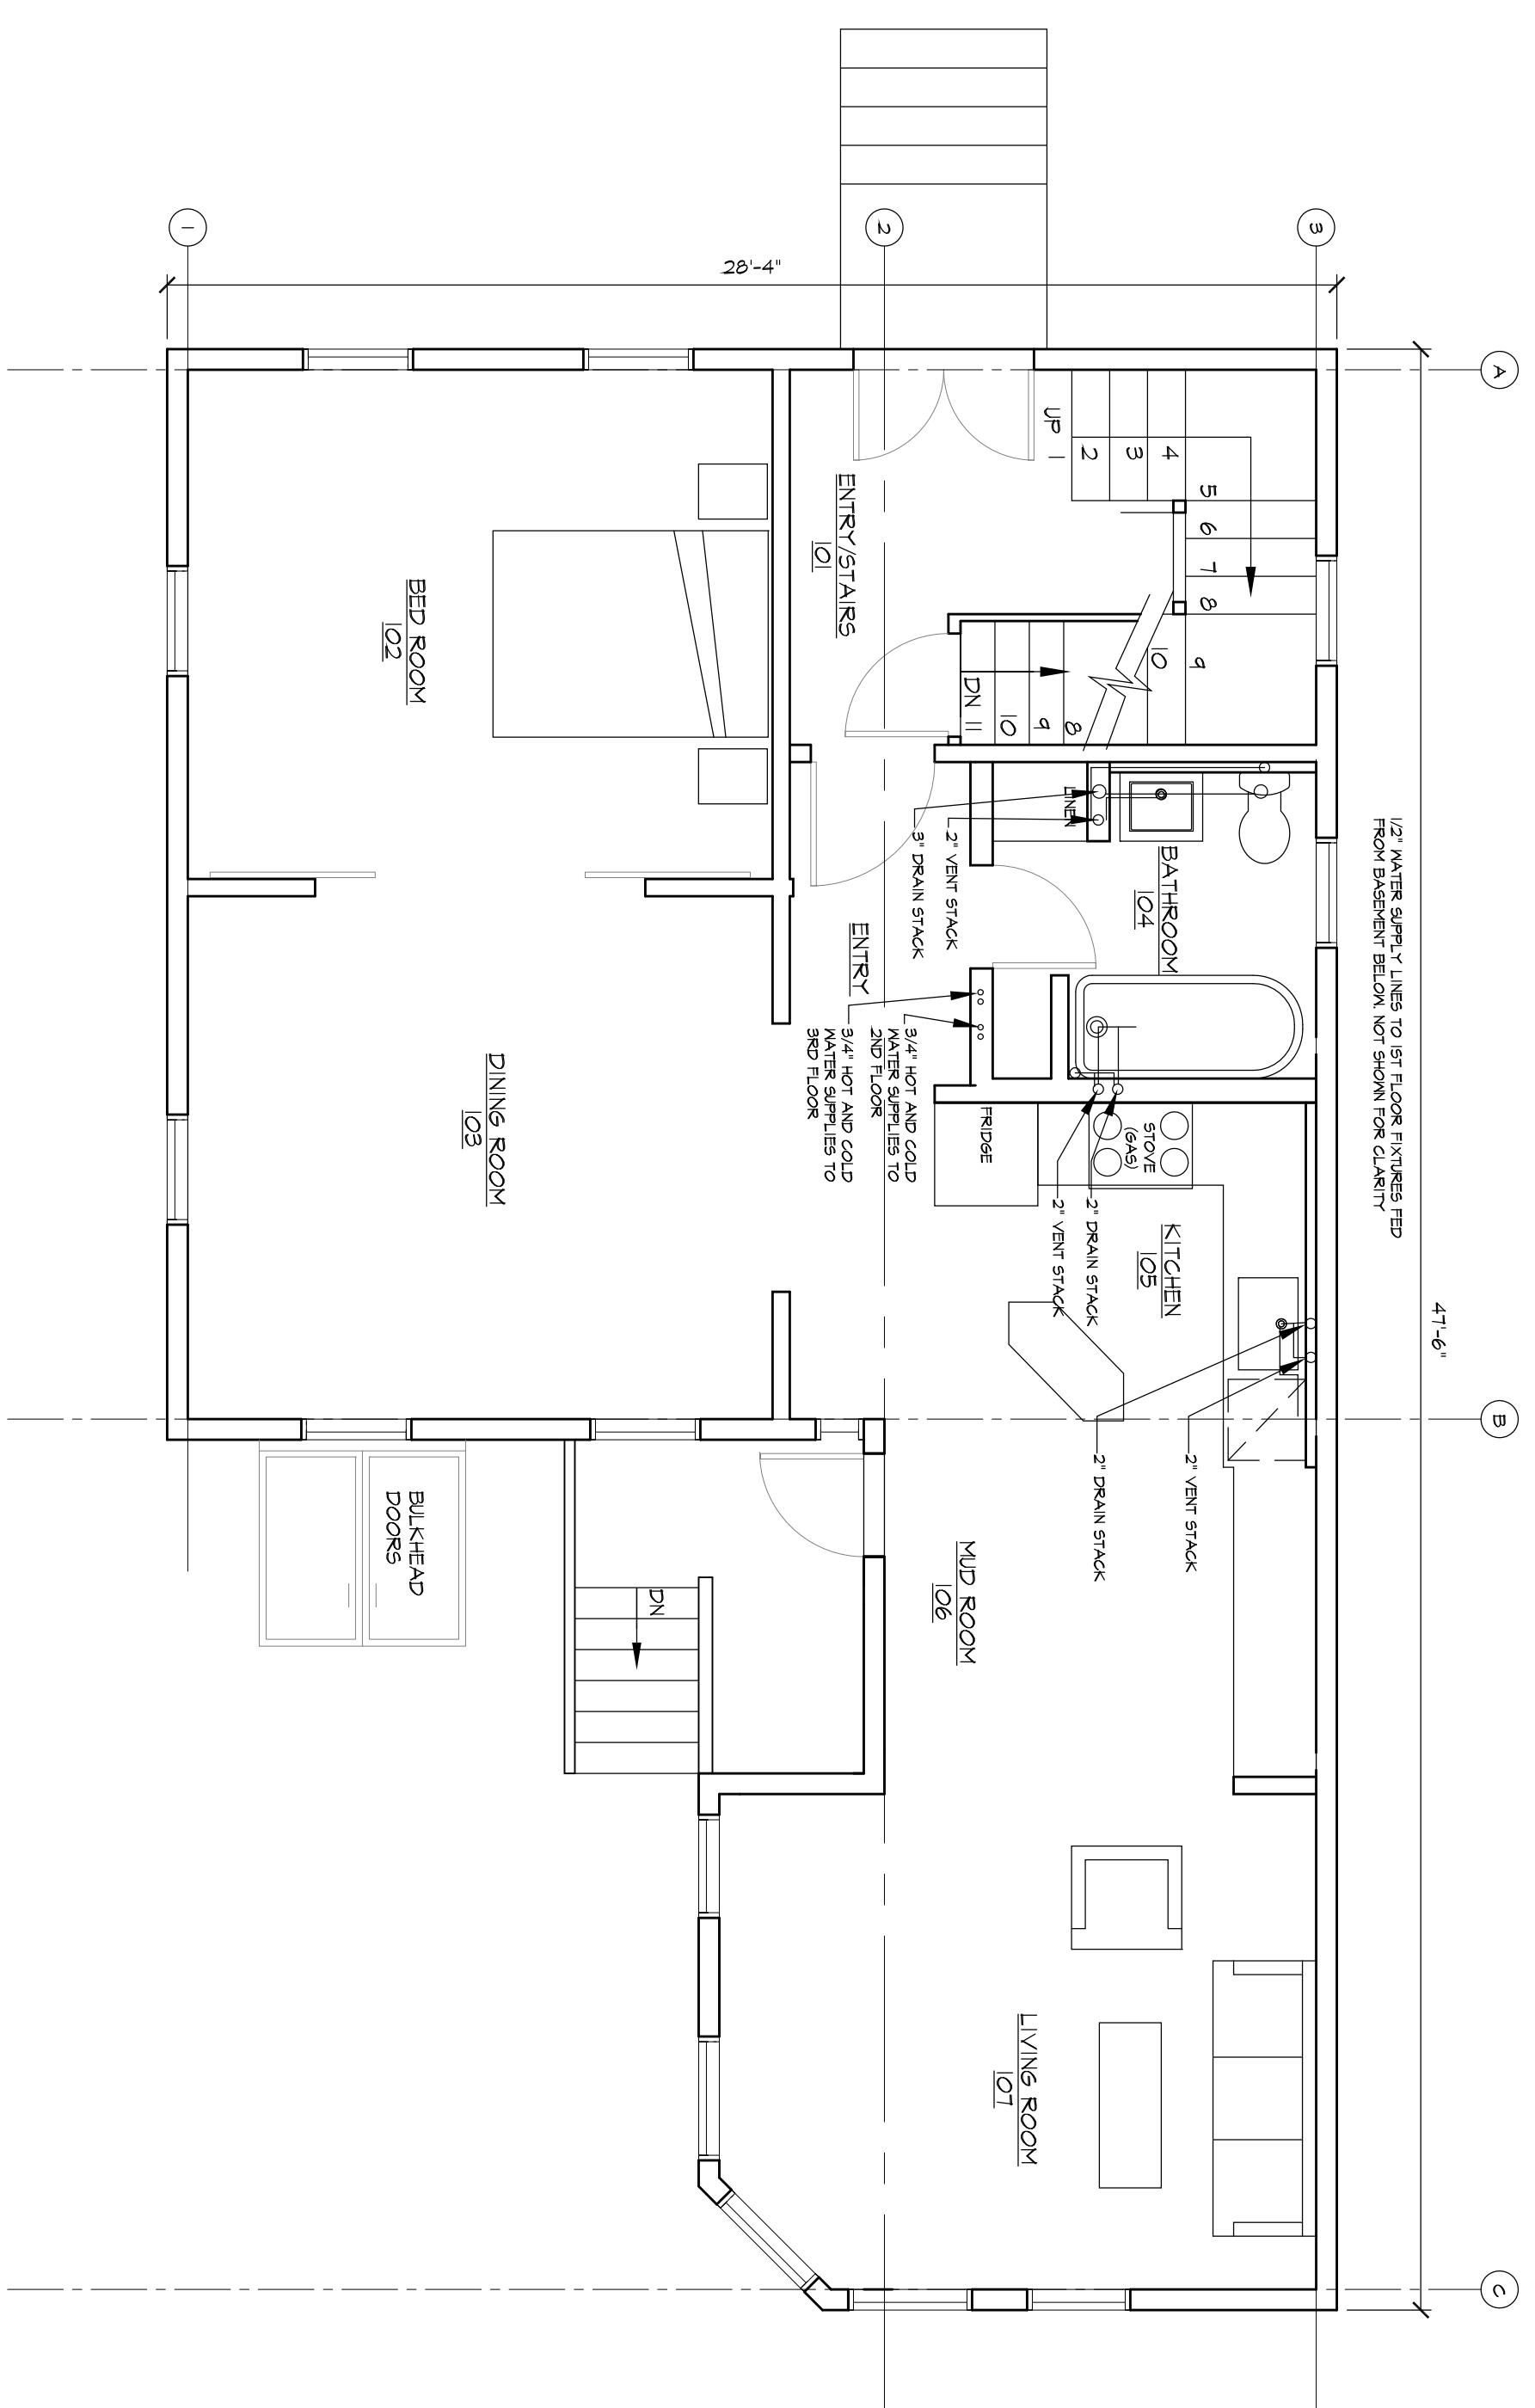

2 FIRST FLOOR PLUMBING PLAN
SCALE = 1/4" = 1'-0"

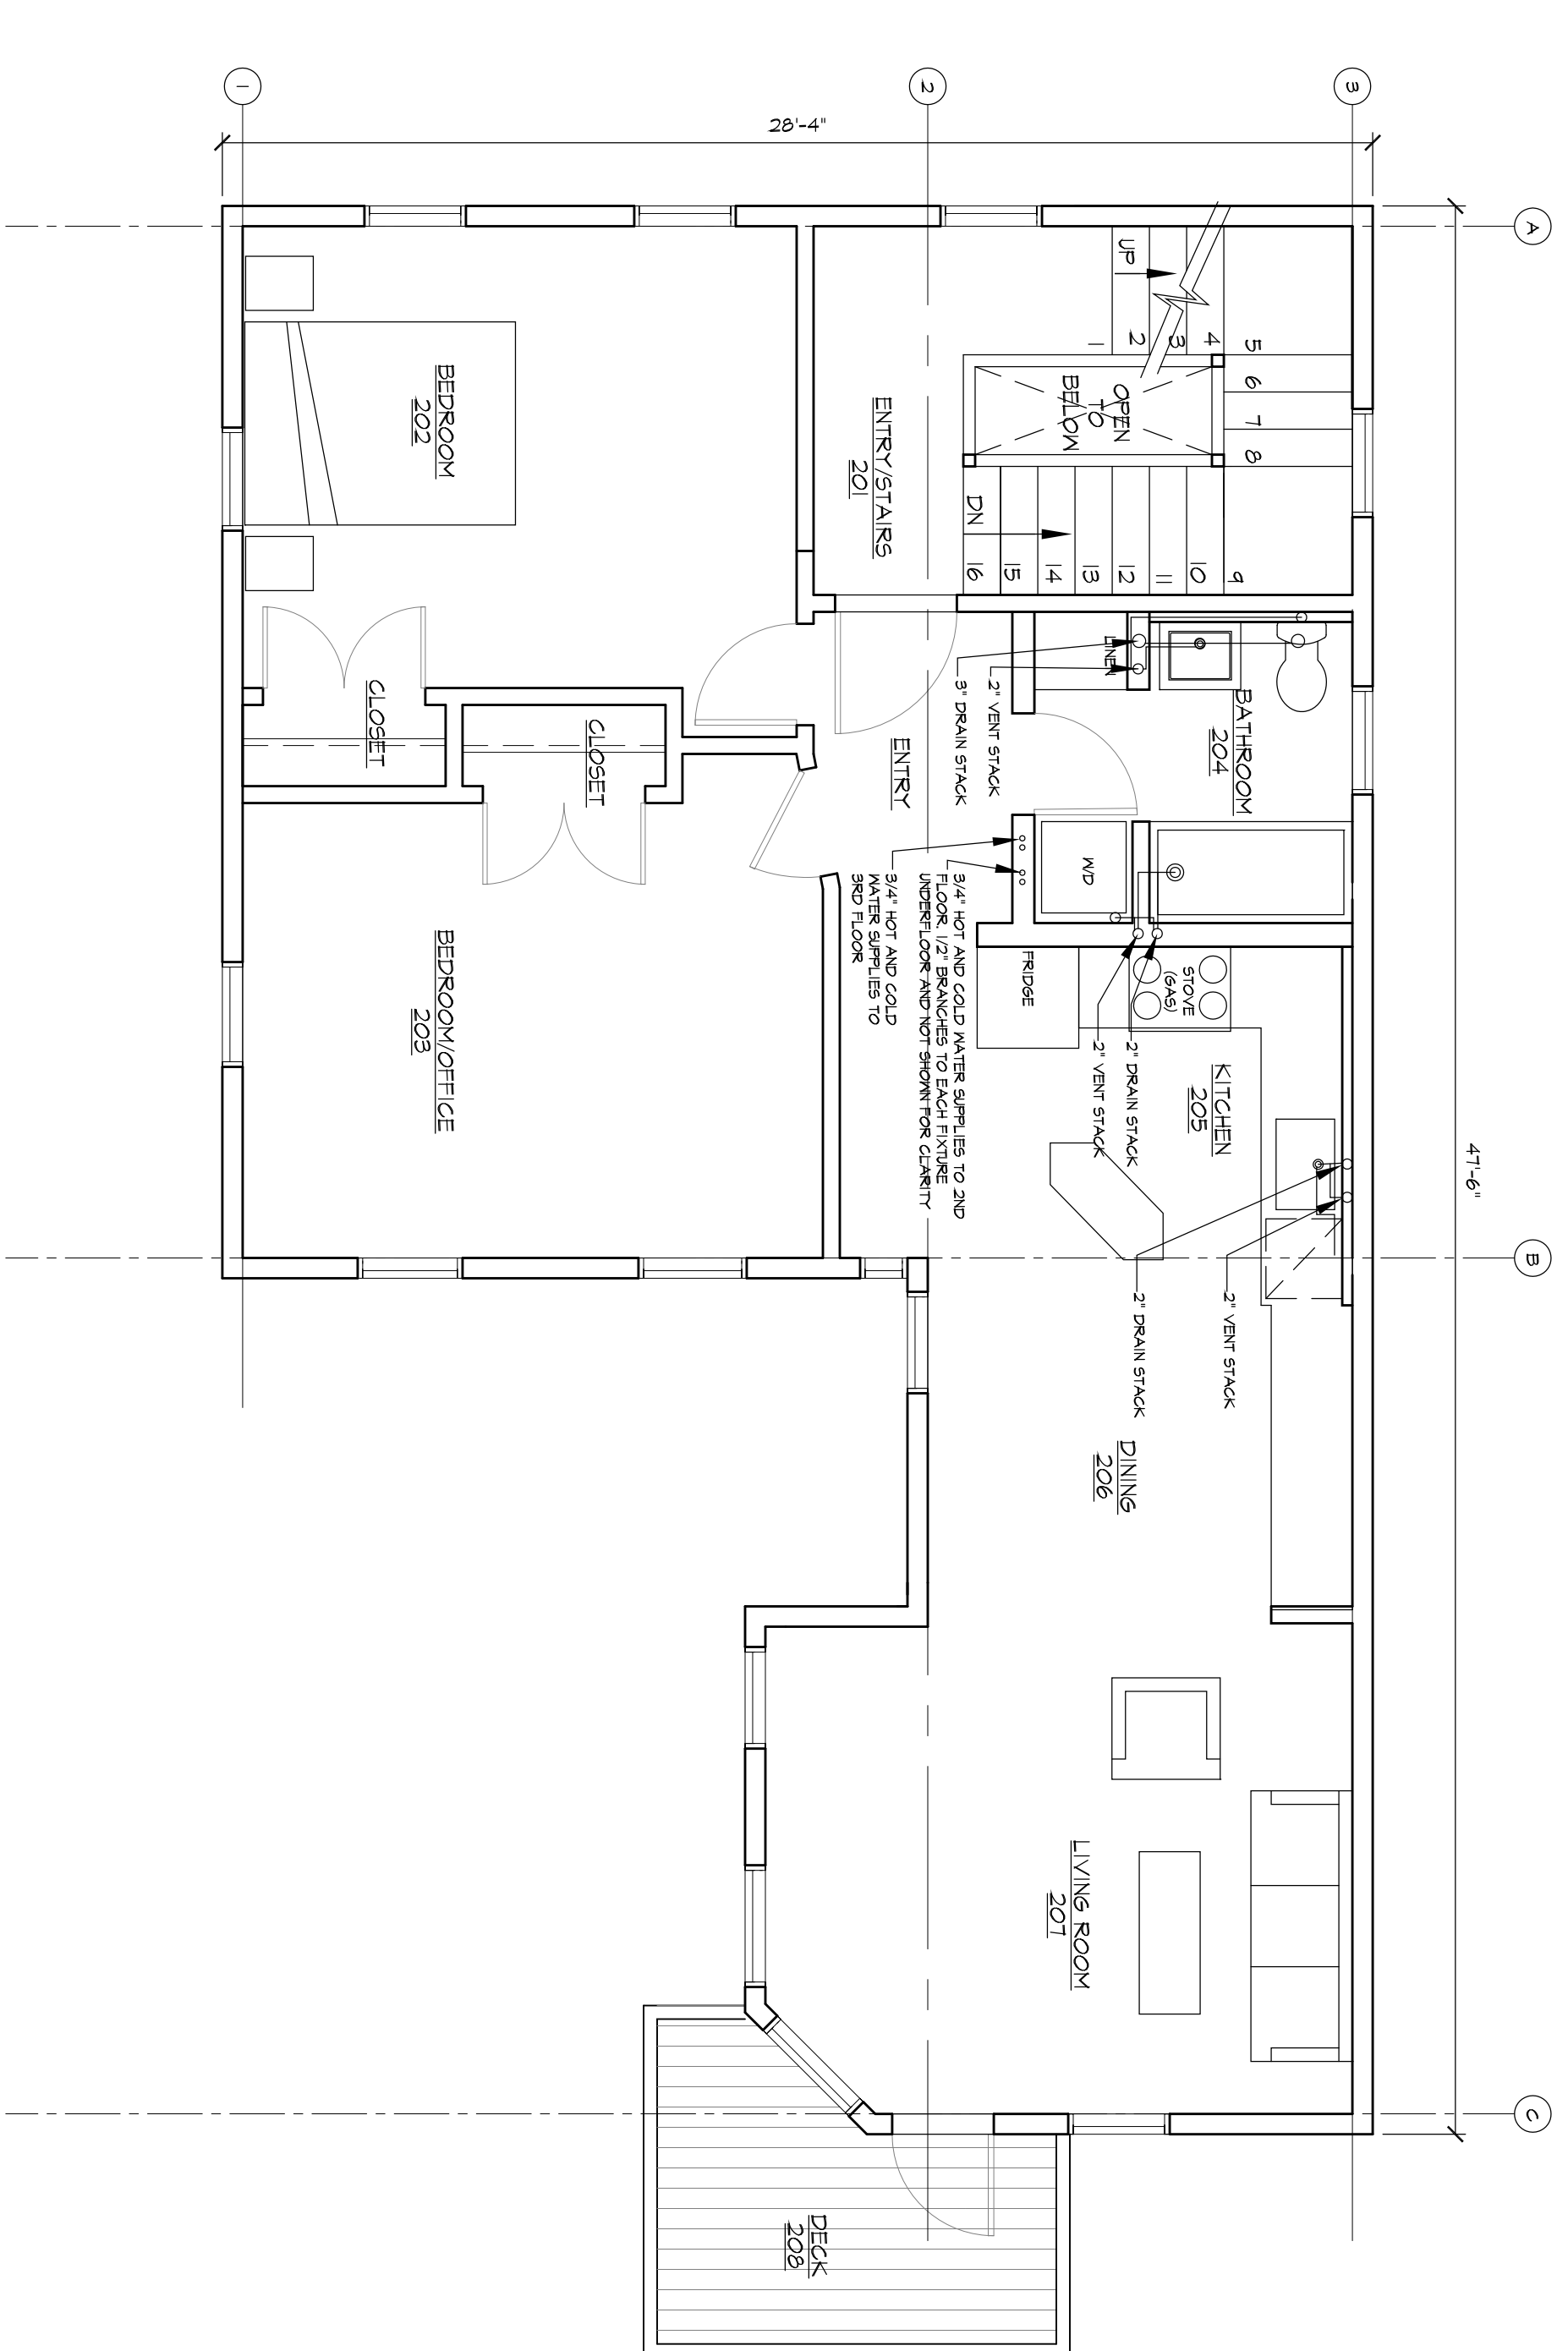

3 SECOND FLOOR PLUMBING PLAN
SCALE = 1/4" = 1'-0"

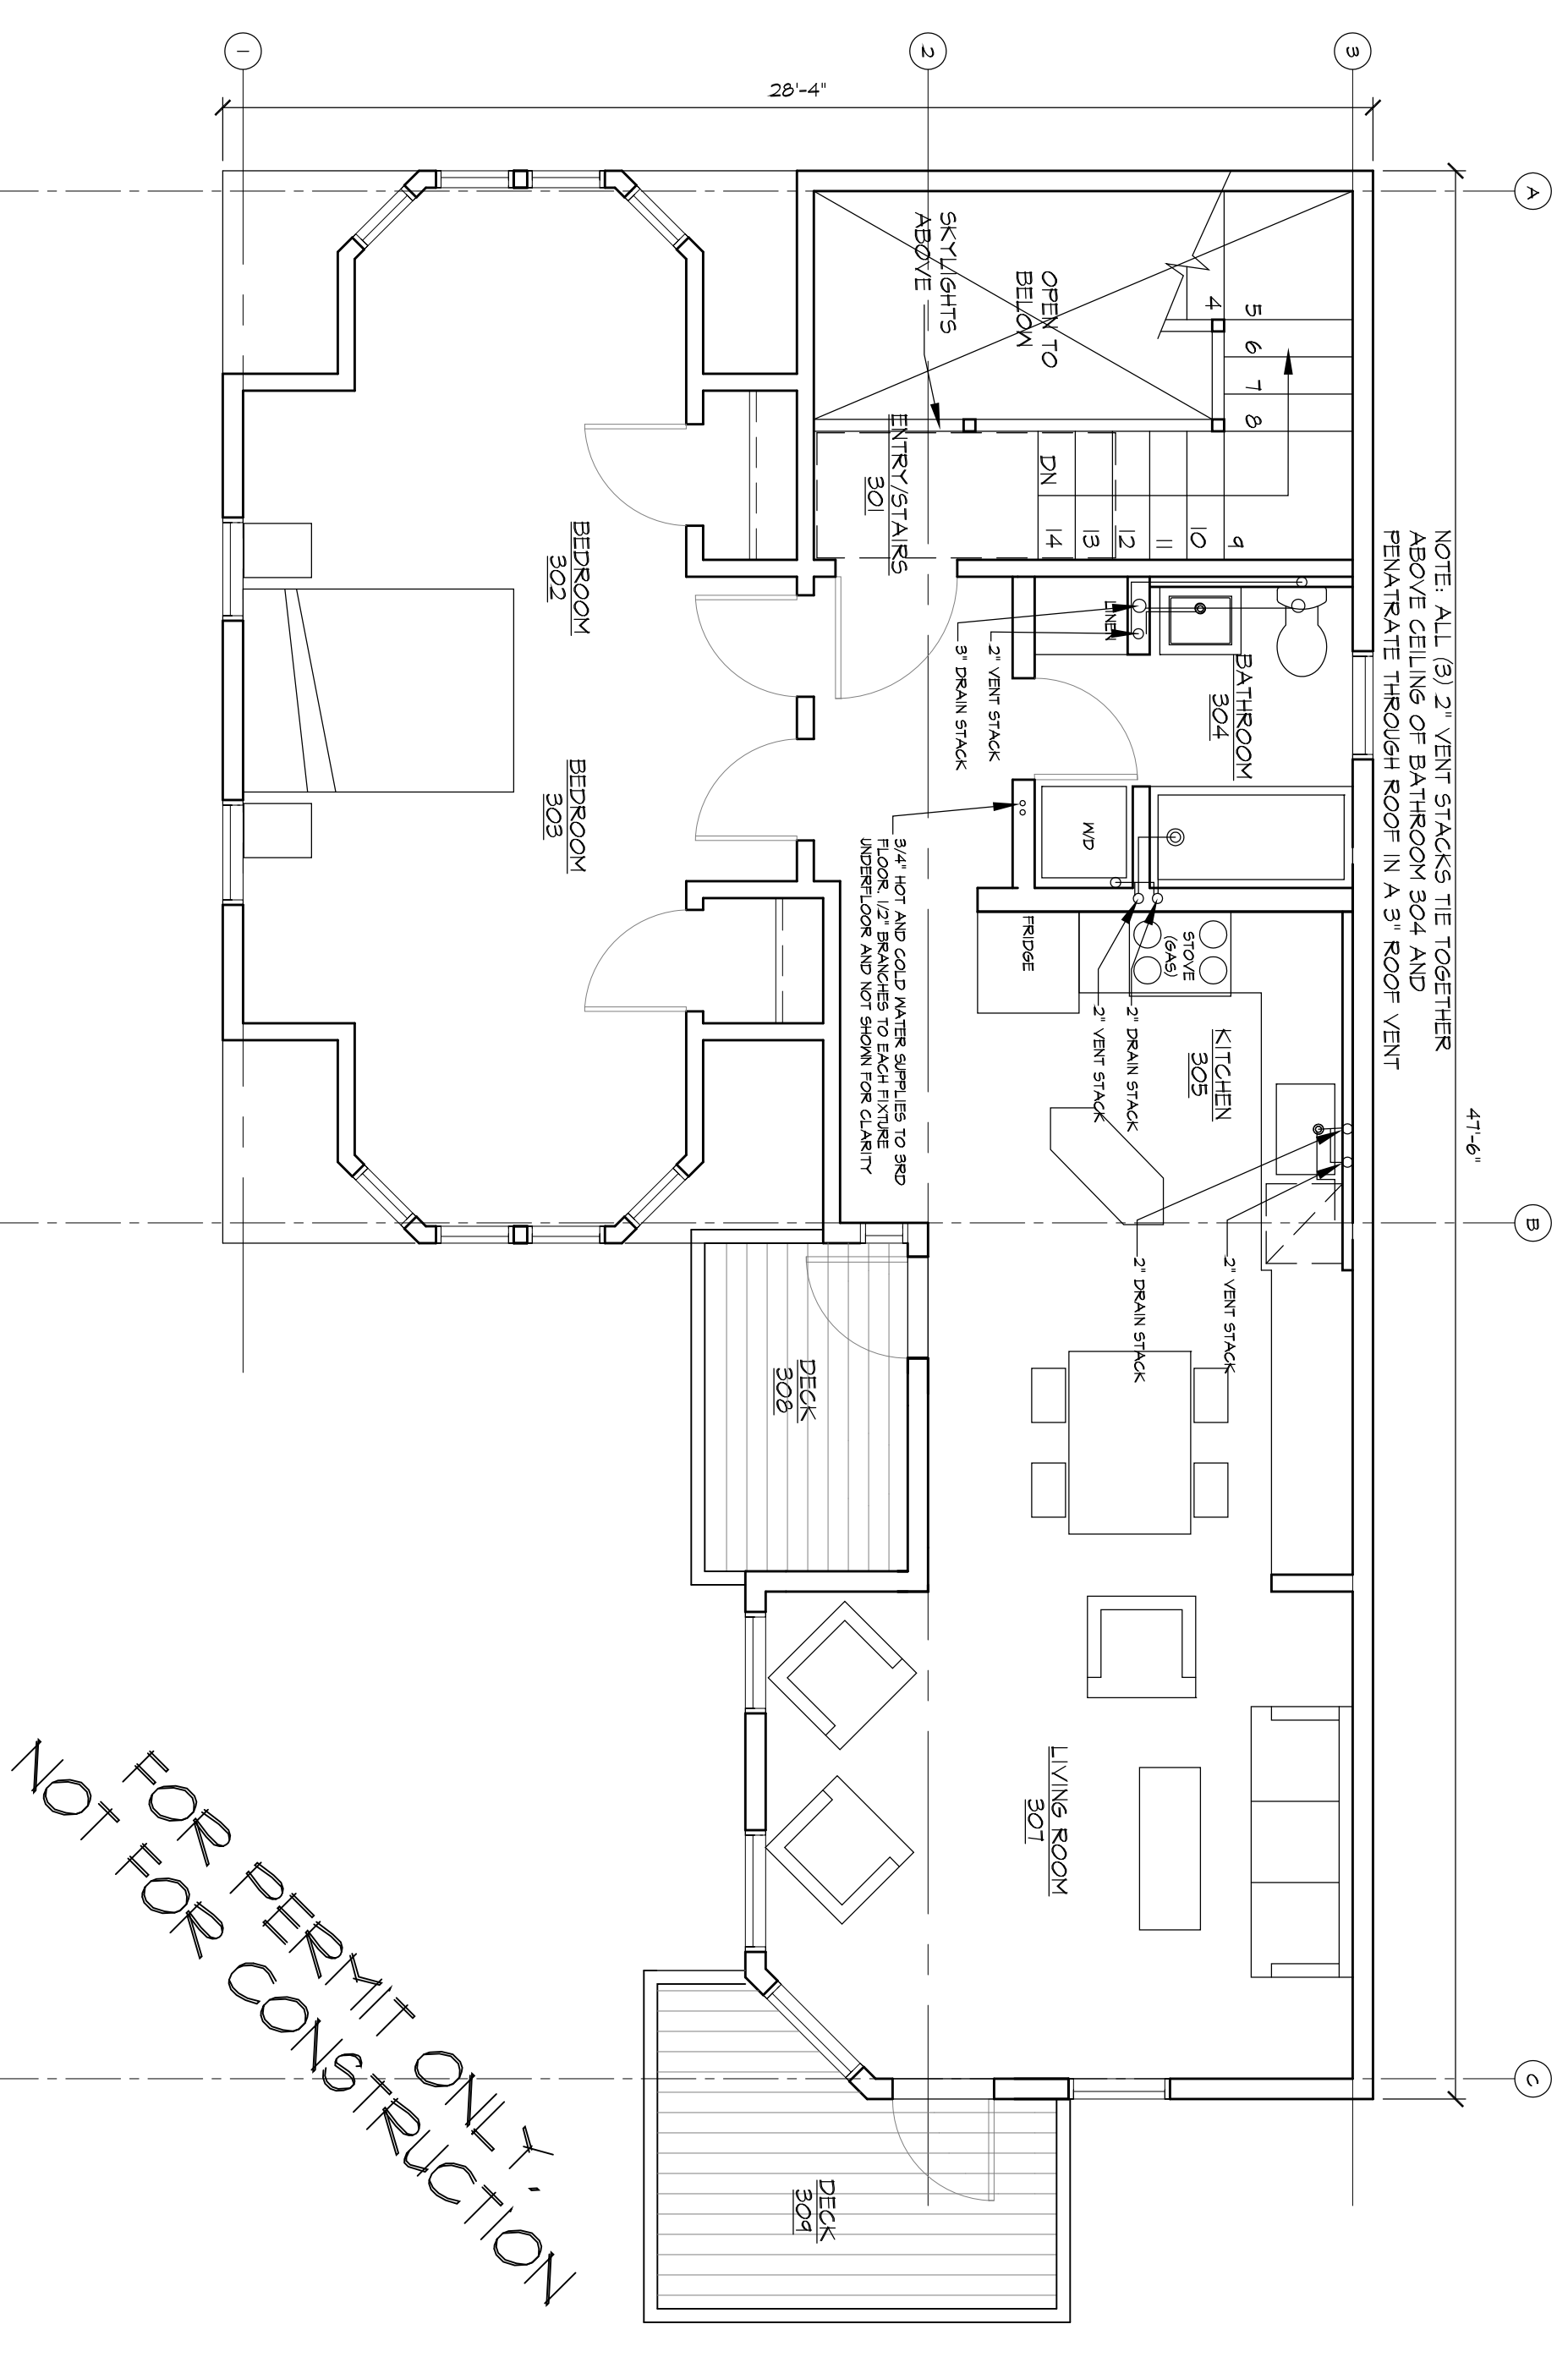

4 THIRD FLOOR PLUMBING PLAN
SCALE = 1/4" = 1'-0"

NOTE: ALL (3) 2" VENT STACKS TIE TOGETHER ABOVE CEILING OF BATHROOM 304 AND PENETRATE THROUGH ROOF IN A 3" ROOF VENT

FOR PERMIT ONLY,
NOT FOR CONSTRUCTION

PLUMBING
DESIGN/BUILD
BY JIM
MICHAUD,
JIM'S
PLUMBING &
HEATING,
201-854-8068

DRAFTED BY
LACHMAN
ARCHITECTS
AND
PLANNERS

ALTERATIONS TO
52 MONUMENT STREET
PORTLAND, MAINE

TITLE
PLUMBING
FLOOR
PLANS

DATE:
ORIGINAL: 11/5/13
REVISION 1:
REVISION 2:
REVISION 3:
DESIGNED FOR:
BUILDING PERMIT SET

DRAWING NO:
1