



THESE DRAWINGS ARE THE PROPERTY OF APPLIED TECHNOLOGY & MANAGEMENT, INC. ANY UNAUTHORIZED REPRODUCTION OR USE IS PROHIBITED AND SUBJECT TO LEGAL PROSECUTION.

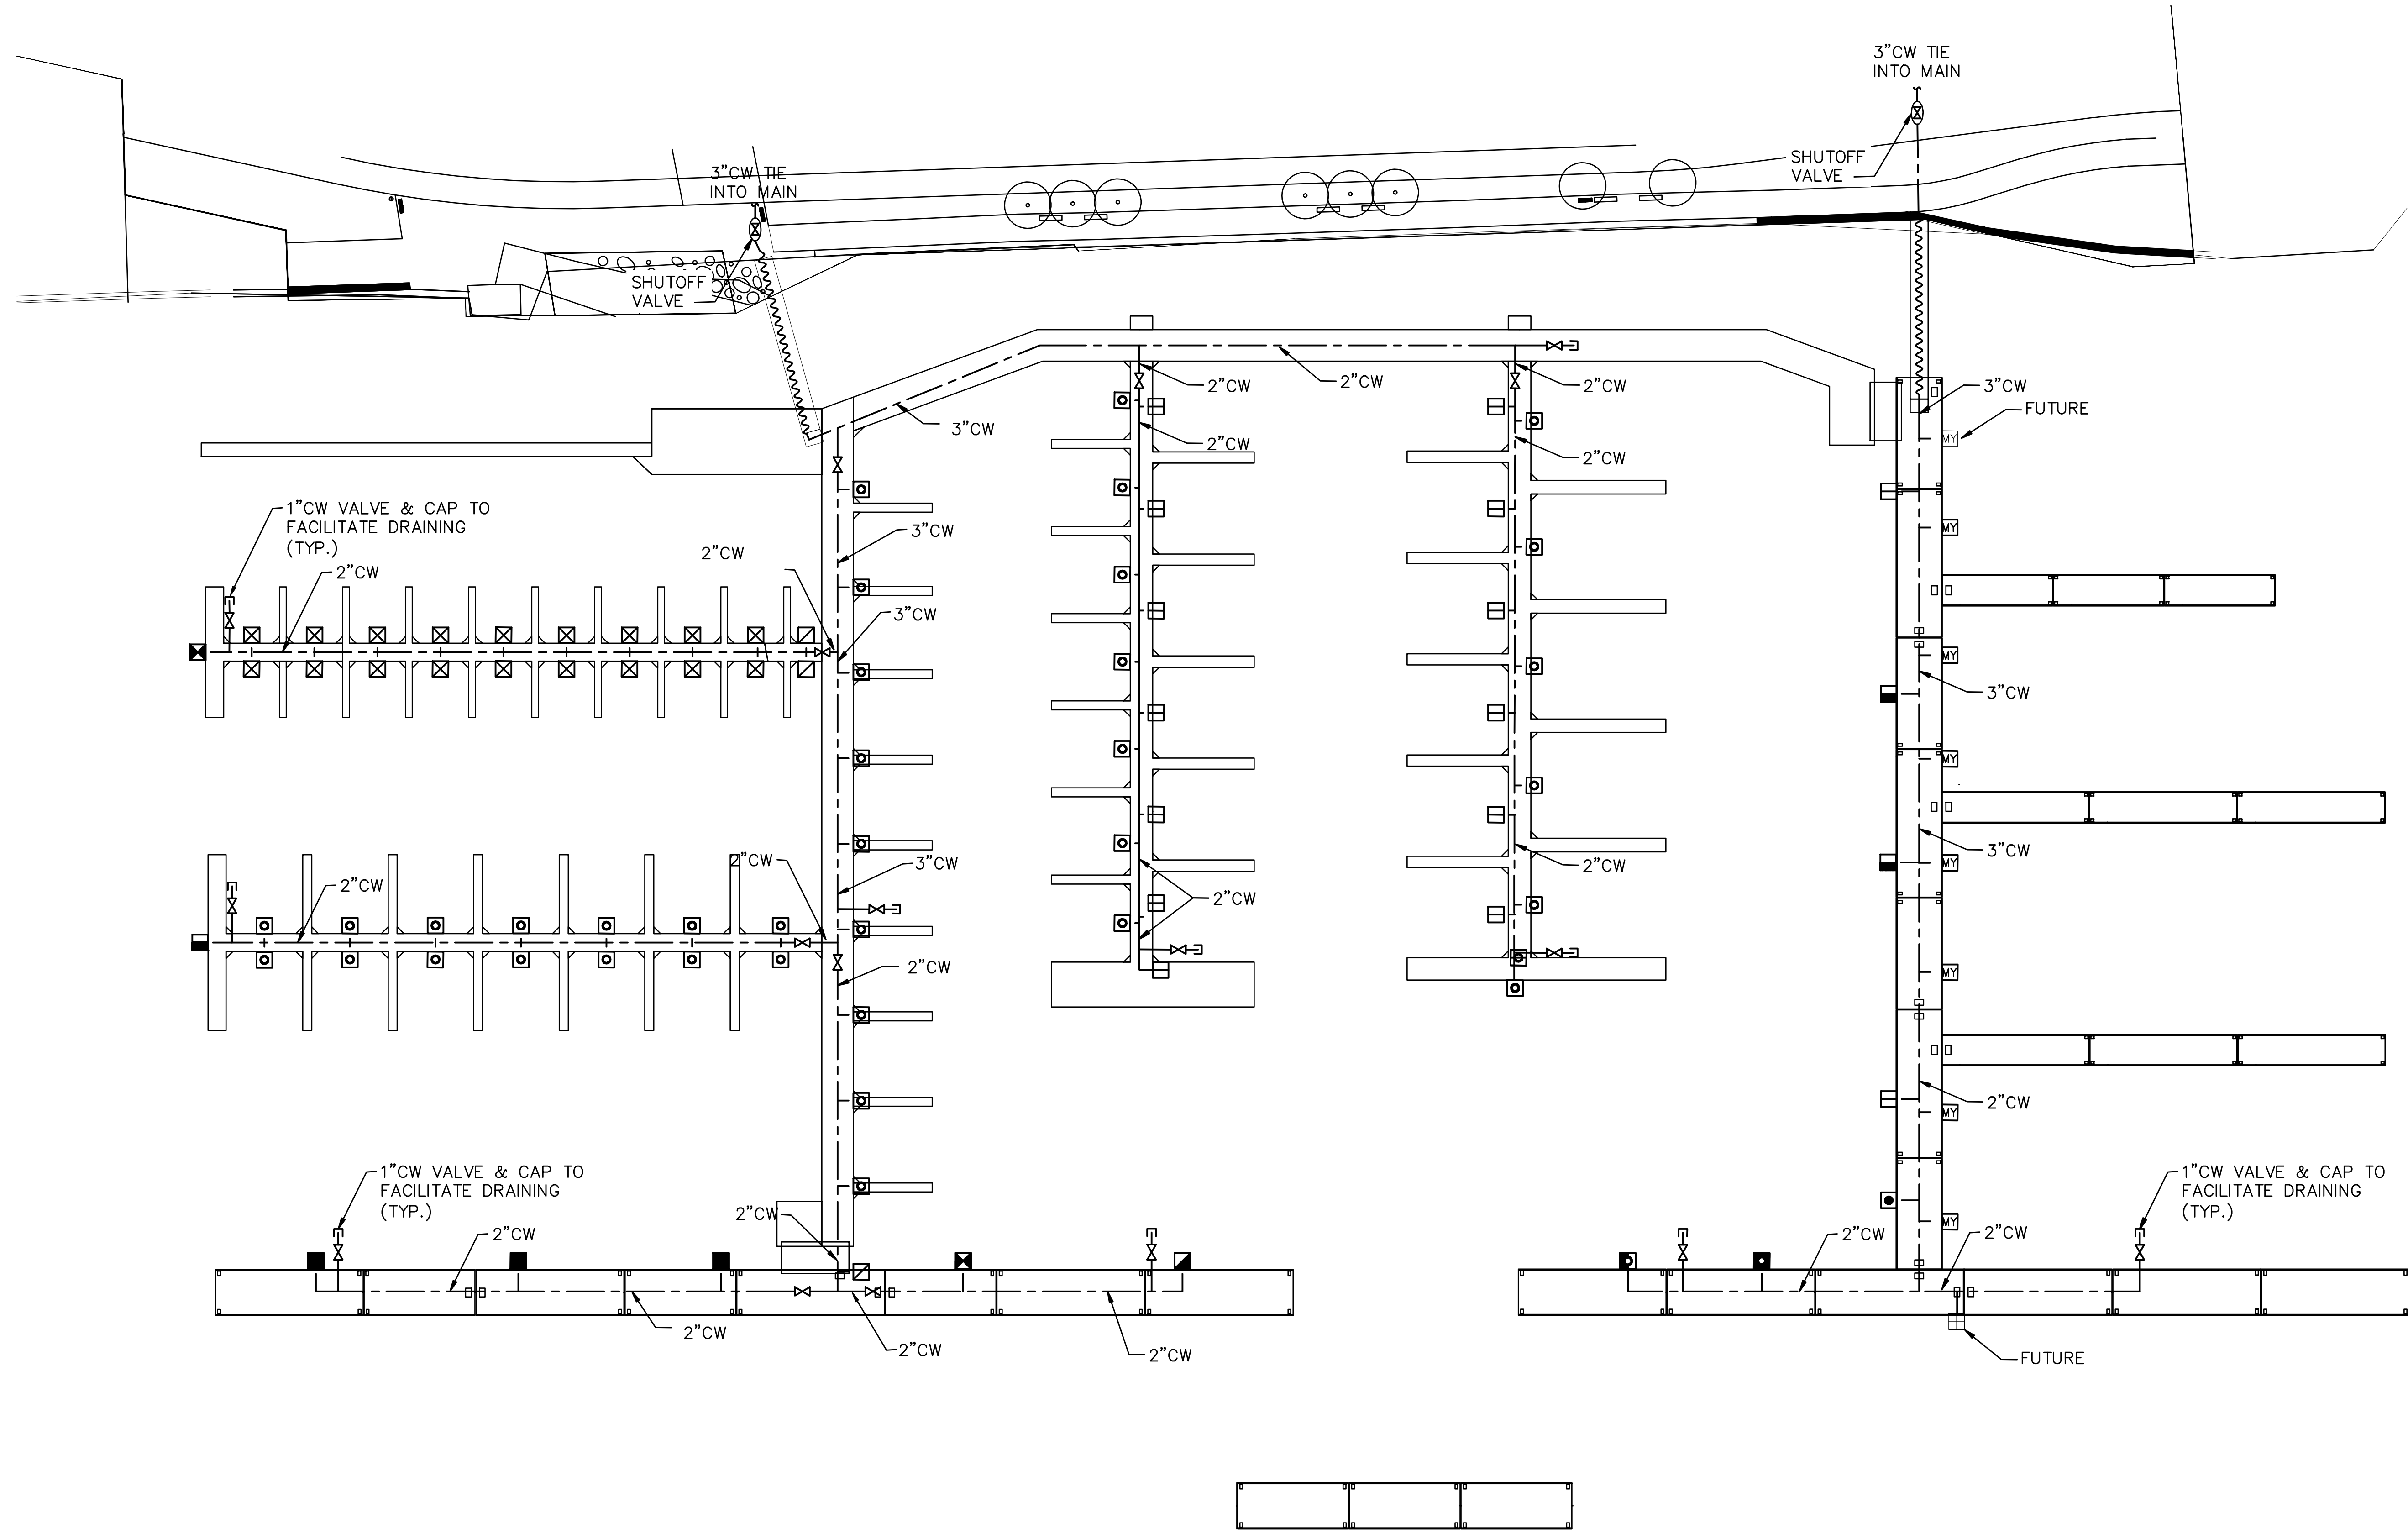

PLUMBING PLAN
 SCALE: 1" = 40'-0"

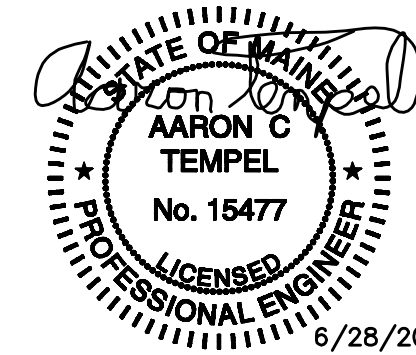

EPIC ENGINEERING INC.
 P.O. BOX 2132 • MT. PLEASANT, SC 29465
 (843) 849-6878 EPIC JOB NO. 18001

COPYRIGHT © 2018 THIS DOCUMENT IS THE PROPERTY OF EPIC ENGINEERING, INC. ANY UNAUTHORIZED REPRODUCTION OR USE IS PROHIBITED AND SUBJECT TO LEGAL PROSECUTION

Applied Technology & Management, Inc.
 941 Houston Northcut Blvd. Suite 201
 Mt Pleasant, SC 29464
 (843) 414-1040
 Certificate of Authorization #00386



FORE POINTS MARINA
 PORTLAND, MAINE
MARINA PLUMBING PLAN
 PORTLAND FORESIDE DEVELOPMENT COMPANY
 PORTLAND, MAINE

DESIGNED	DRAWN	CHECKED
ACT	PND	ACT
DATE: 02/18		
JOB NO. 18001		
SCALE: 1" = 40'-0"		

REV.	DATE	DRAWN	CHKD	BY

REMARKS

Signature
 Aaron C. Tempel, P.E.
 ME Professional Eng. PE15477
 6/28/2018