



VERIFIED BY: AARON C. TEMPEL, P.E. 6/28/2018
 NOTE: THESE DRAWINGS AND DESIGN ARE STRICTLY CONFIDENTIAL AND PROTECTED BY INTERNATIONAL COPYRIGHT LAW. DETAILS MUST NOT BE DISCLOSED, REPRODUCED OR COMMUNICATED TO A THIRD PARTY IN ANY FORM OR MANNER WITHOUT THE PRIOR WRITTEN APPROVAL OF APPLIED TECHNOLOGY & MANAGEMENT.

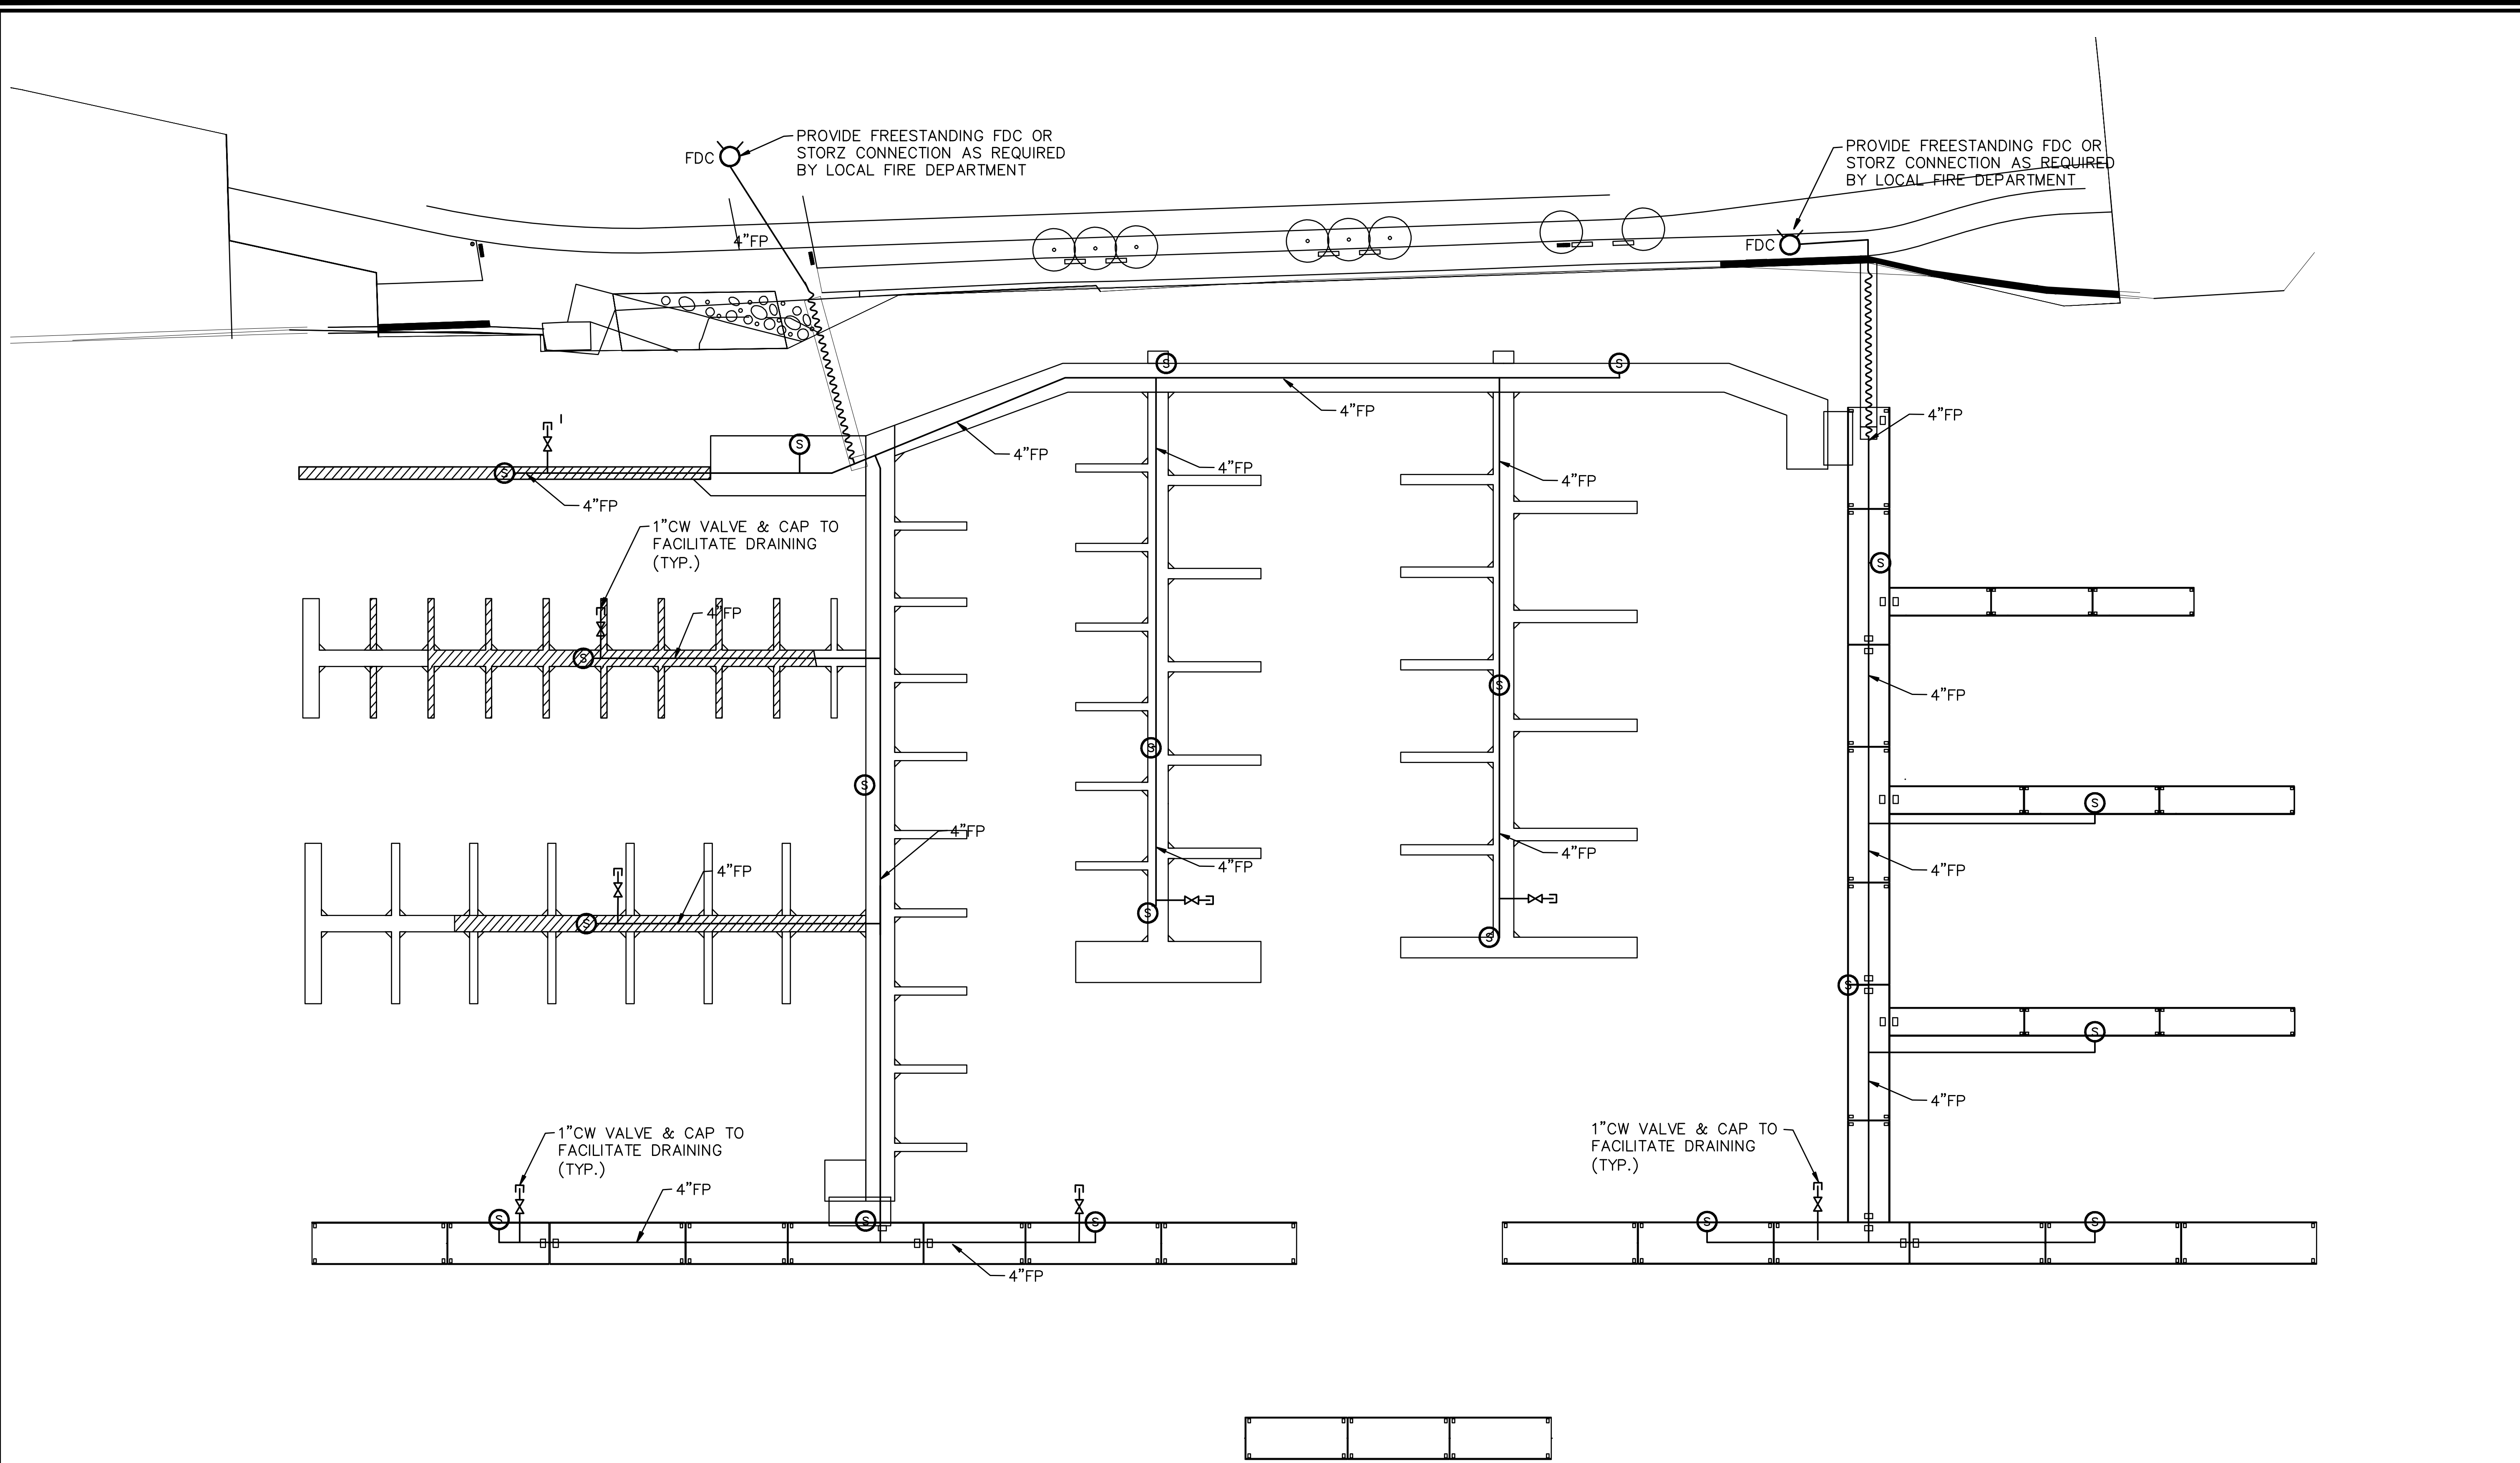

FIRE PROTECTION PLAN
 SCALE: 1"=40'-0"

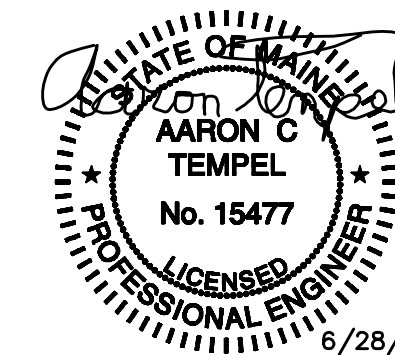

EPIC ENGINEERING INC.
 P.O. BOX 2132 • MT. PLEASANT, SC 29465
 (843) 849-6878 EPIC JOB NO. 18001

COPYRIGHT © 2018 THIS DOCUMENT IS THE PROPERTY OF EPIC ENGINEERING, INC. ANY UNAUTHORIZED REPRODUCTION OR USE IS PROHIBITED AND SUBJECT TO LEGAL PROSECUTION

Applied Technology & Management, Inc.
 941 Houston Northcutt Blvd., Suite 201
 Mt Pleasant, SC 29464
 (843) 414-1040
 Certificate of Authorization #00385



MARINA FIRE PROTECTION PLAN
 FORE POINTS MARINA
 PORTLAND, MAINE
 PORTLAND FORESIDE DEVELOPMENT COMPANY
 PORTLAND, MAINE

DESIGNED	DRAWN	CHECKED
ACT	PAW	ACT

DATE: 02/2018
 JOB NO.: 18001
 SCALE: 1"=40'-0"

REV.	DATE	DRAWN	CHECKED

REVISIONS

Aaron Tempel
 Signature
 Aaron C. Tempel, P.E.
 ME Professional Eng. PE15477
 6/28/2018
 Date