


DEMOLITION PLAN

SCALE: 1/8" = 1'

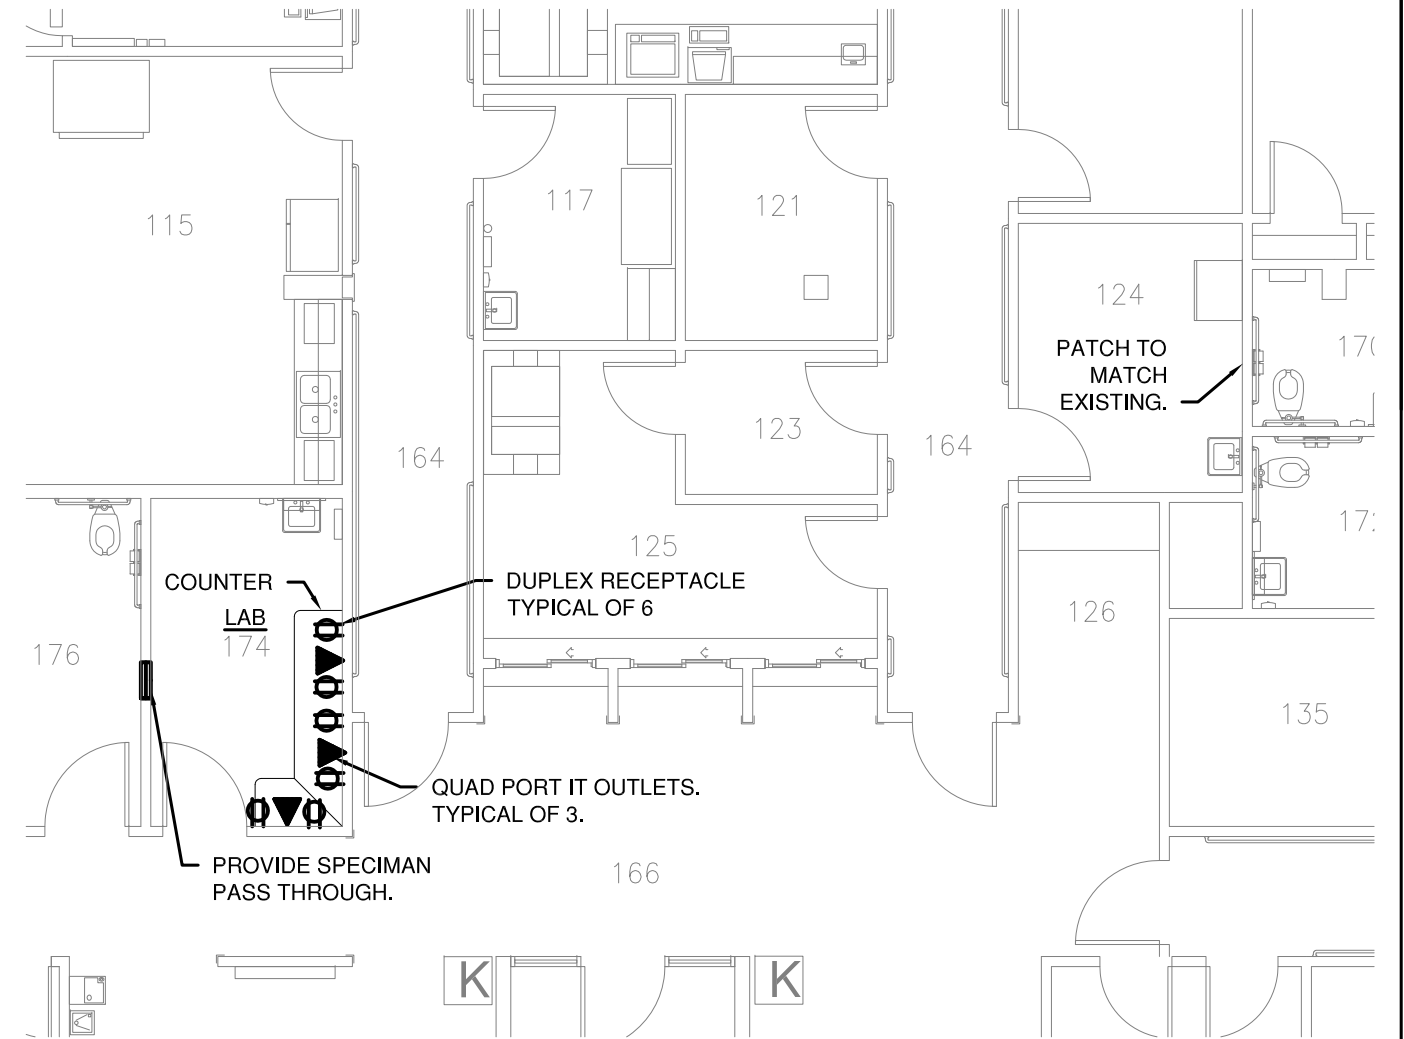

PROPOSED LAYOUT

SCALE: 1/4" = 1'

REV #	DATE	DESCRIPTION	RVWD	APRVD
0	3/26/2014	UPLOAD TO eCMS	KHA	KHA

	SHEET TITLE: FLOOR PLAN			
	BLDG. NO. PROJECT TITLE: PORTLAND FORE STREET CBOC - LAB RELOCATION			
	DRAWN: KHA	CHECKED: 	DATE: 3-3-14	DWG. NO.: A-1
	APPROVED: PROJECT ENGINEER			DWG. 1 OF 1
	APPROVED: SAFETY OFFICER			PROJECT NO.:
APPROVED: CHIEF ENGINEER			402-14-010S	
VETERANS ADMINISTRATION MEDICAL & REGIONAL OFFICE CENTER TOGUS, MAINE 04330				